


**Civil/Structural/
Mechanical/Electrical/
Plumbing Engineering**
8250 College Pkwy, Ste 101
Fort Myers, Florida 33919
Tele: (239)-267-7432
Fax: (239)-267-8704
www.AtlasDesingEngineering.com
CA# 28823

copyright
All ideas, designs, and plans indicated on or represented by these documents are owned by and are property of ATLAS Design & Engineering Inc. ATLAS Design & Engineering Inc. hereby expressly reserves its copyright and other property rights in these documents. These plans and drawings are not to be reproduced, changed or copied in any form or manner whatsoever without first obtaining the express permission and consent of the ATLAS Design & Engineering Inc., nor are they to be assigned to any party without first obtaining said written consent of ATLAS Design & Engineering Inc.
© ATLAS Design & Engineering Inc.

Job Status Note:
Pursuant to Florida Statute 61615-30.003 These drawings are preliminary and not in final form but are being transmitted to the public agency to receive agency reviews, comments and interpretations. The documents may be subsequently revised by the engineer to reflect resolution of issues with the public agency prior to final action by the agency. Changes, revisions and modifications to the project may prompt additional document submitted for agency approval action on the same project.

PRINT	REVISION
Site Plan Rev 1	2021.10.28
Site Plan Rev 2	2021.12.02
Site Plan Rev 3	2021.12.29
Site Plan Rev 3.1	2022.03.11
Site Plan Rev 4	2022.04.08
Rev 4.1 Change Name	2022.04.13
Site Plan Rev 5	2022.05.12
Site Plan Rev 6	2022.08.08

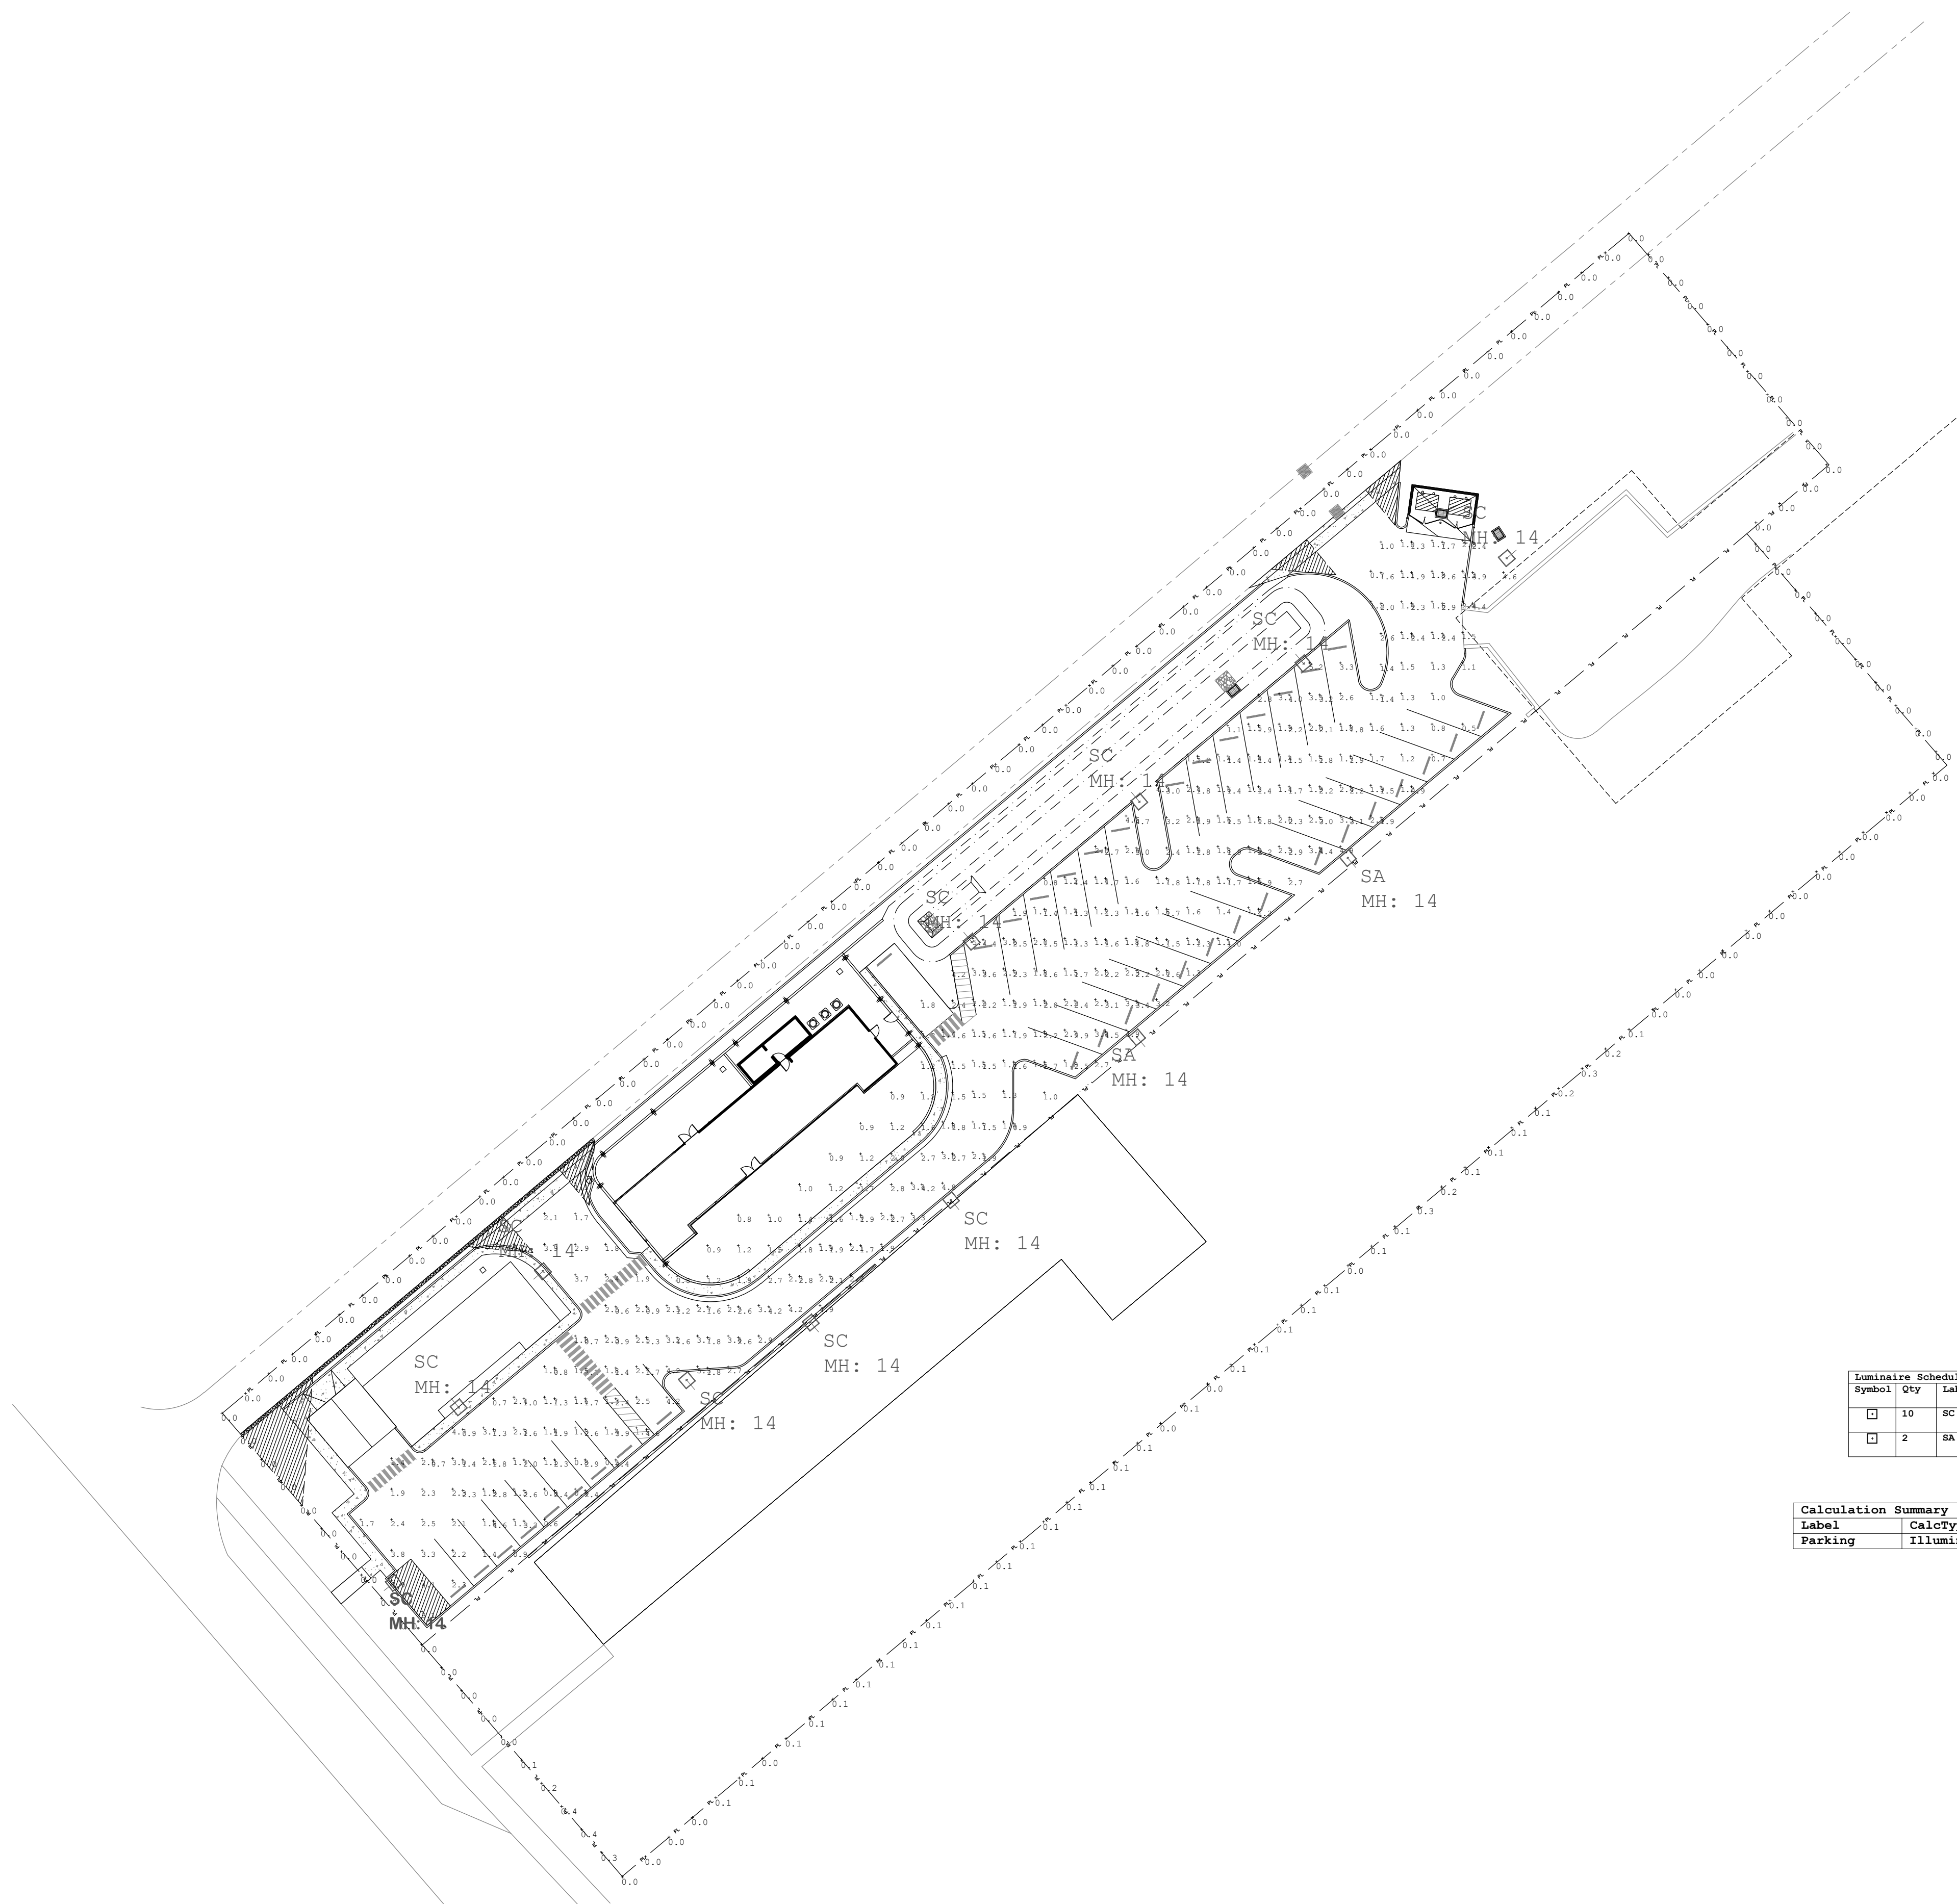

Luminaire Schedule							
Symbol	Qty	Label	Arrangement	Description	LLF	Luminaire Lumens	Luminaire Watts
□	10	SC	Single	ECP-S-32L-530-NM-G2-4 mtd 14' AFG	0.900	7025	55.7
□	2	SA	Single	ECP-S-32L-530-NM-G2-3 mtd 14' AFG	0.900	6715	55.7

Calculation Summary							
Label	CalcType	Units	Avg	Max	Min	Avg/Min	Max/Min
Parking	Illuminance	Fc	2.18	5.9	0.4	5.45	14.75

N SITE LIGHTING PLAN
SCALE: 1"=30'



JOB # 21-4473
**Lo' Key Island Grill
Plaza Redevelopment**
5620 Gulf of Mexico Drive
Longboat Key, FL
SITE LIGHTING PLAN

Drawings are considered preliminary unless signed and sealed.

Tao Wang, PE# 92032

| Skewed |
| SHEET NUMBER |

C1.8