



GULF OF MEXICO

MEAN HIGH WATER LINE
SEPT. 25, 1972
1.40' ABOVE M.S.L.

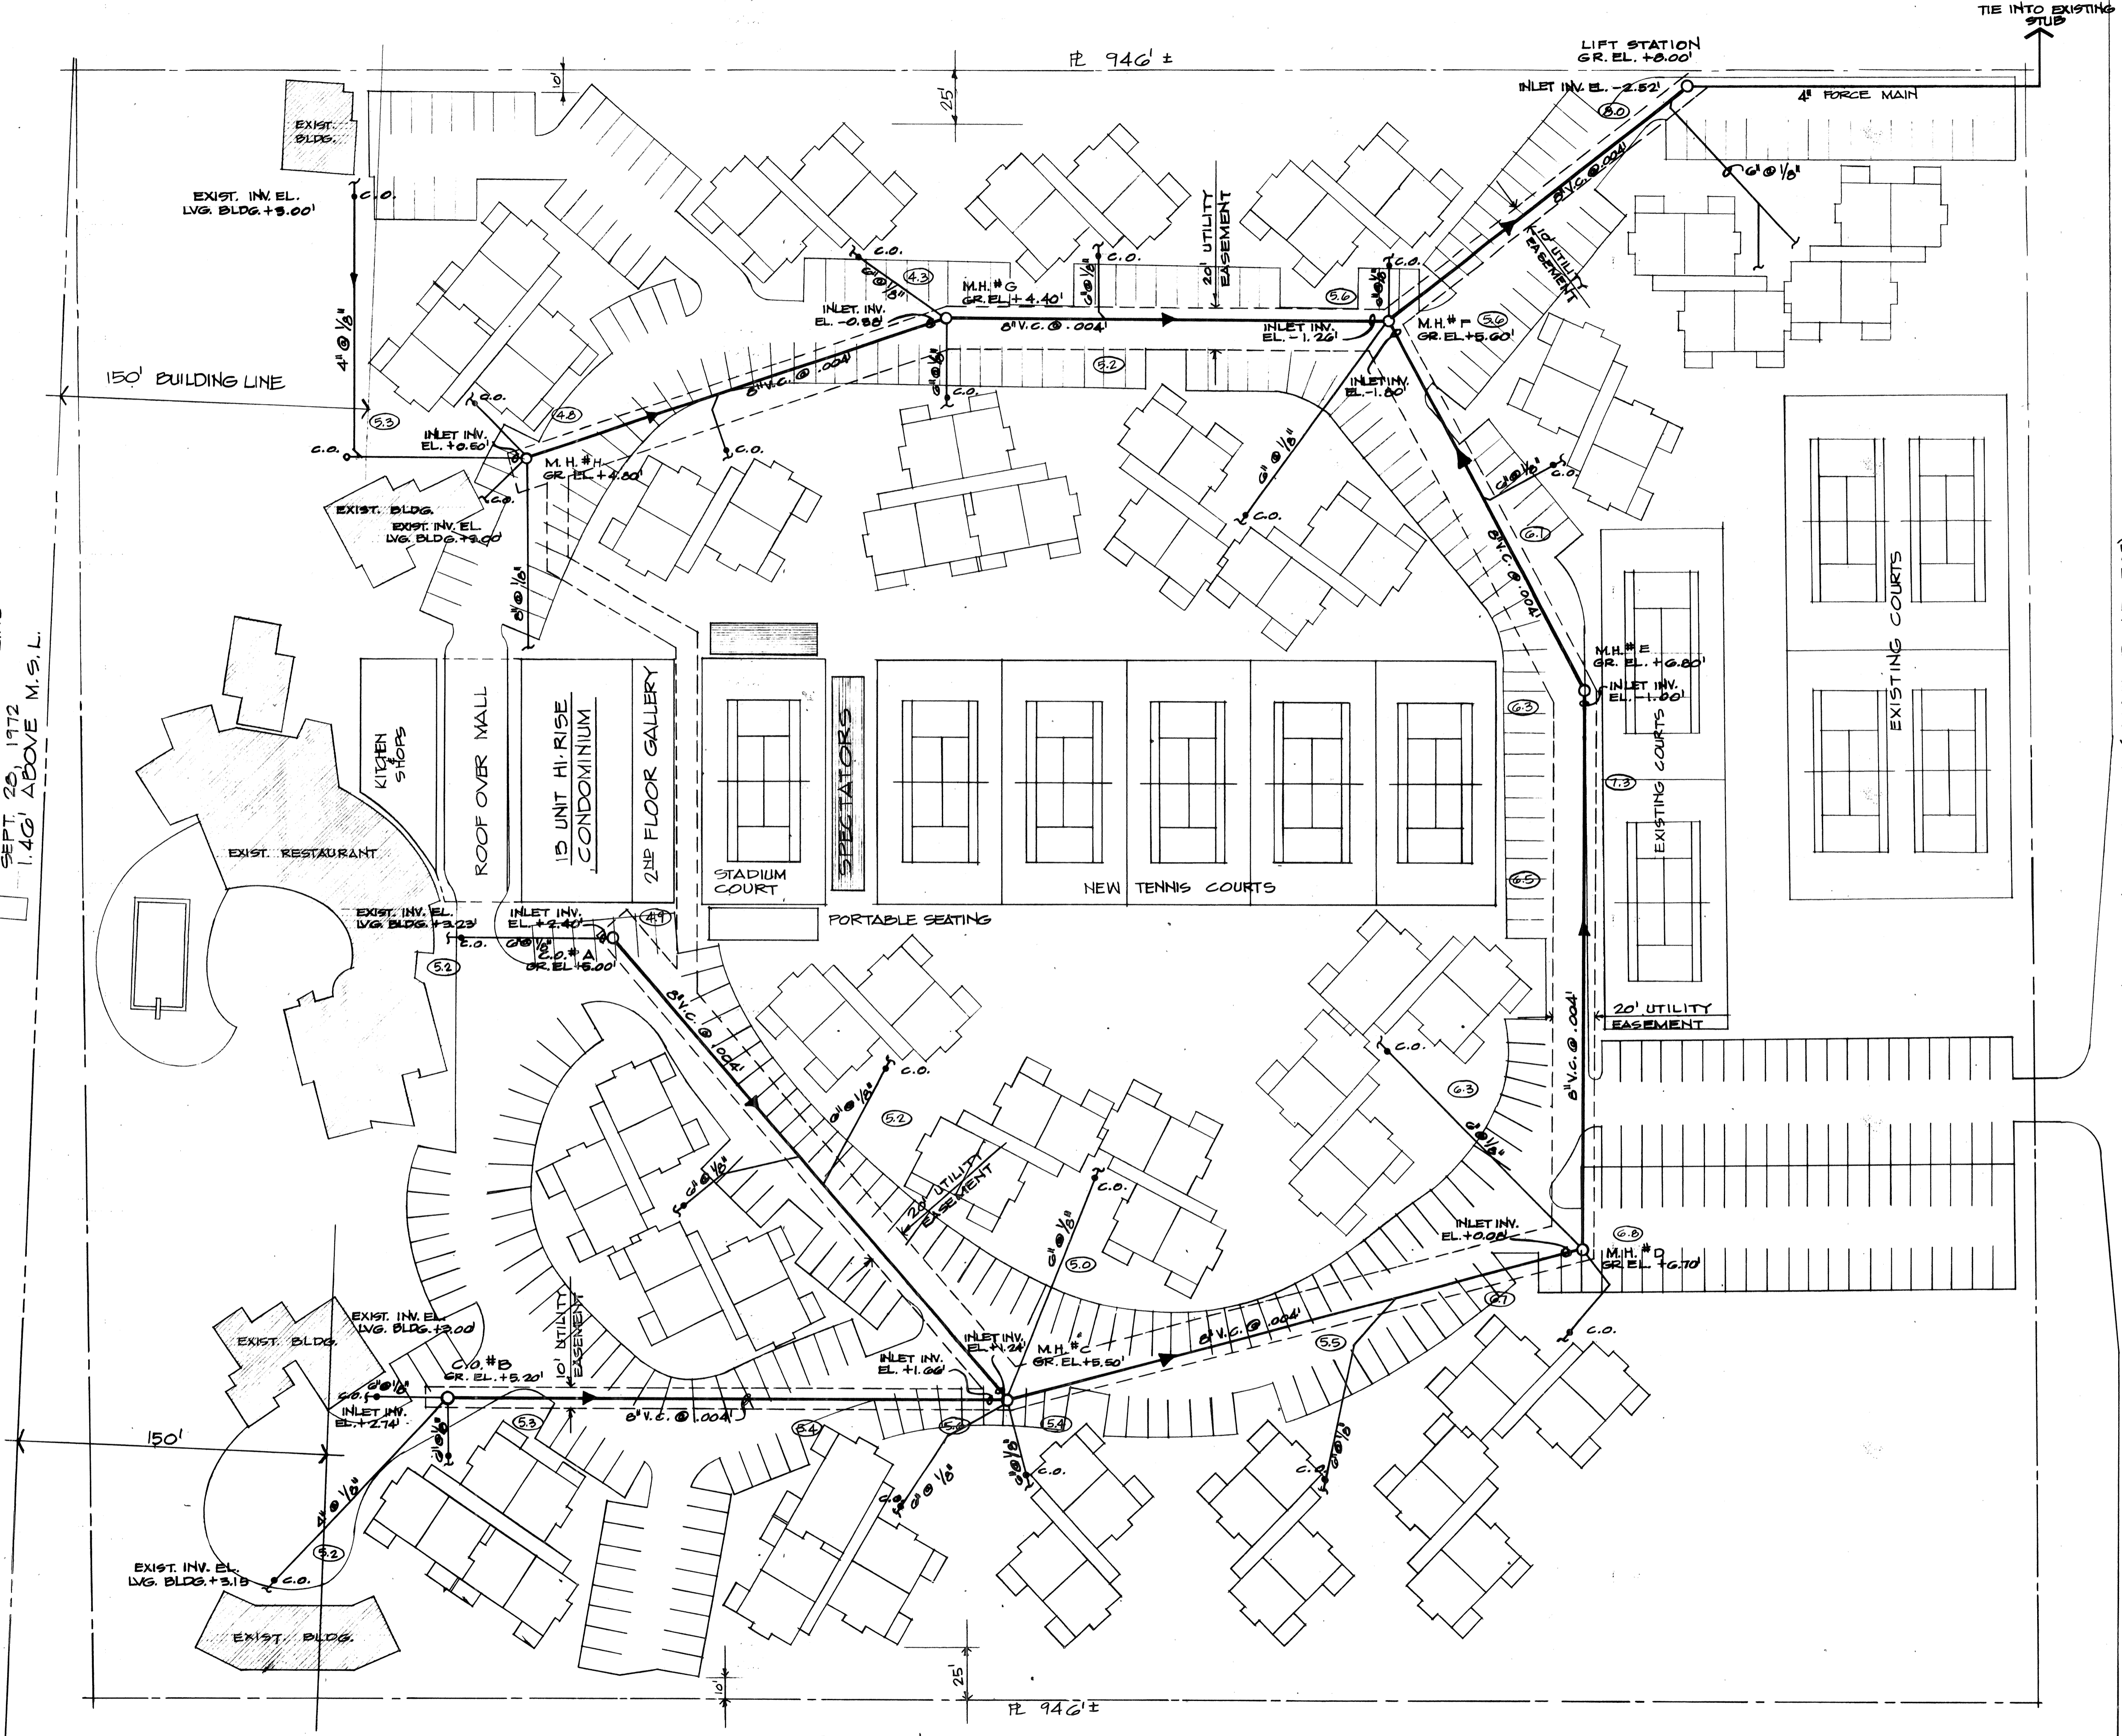

SITE PLAN
SHOWING "AS BUILT" WASTEWATER COLLECTION SYSTEM

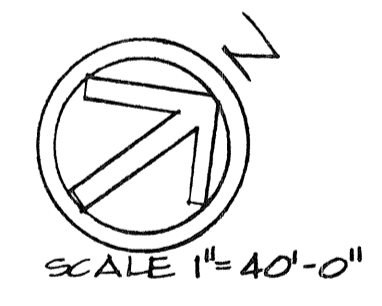

- LEGEND**
- M.H. SANITARY MANHOLE
 - HYD. FIRE HYDRANT
 - C.O. CLEAN OUT @ GRADE
 - (52) FINAL GRADE ELEV.

DEB

PROJECT ENGINEER D.E. BRITTS ASSOC. INC. 1048 N. FEDERAL HWY. PALM BEACH, FLA. FLA. REG. NO. 4795 FILE # 0217	DESIGNED BY	DATE:	SCALE:	REVISION	LTR.	DATE
CHECKED BY PROJECT NO.	DRAWN BY					
TOWN OF LONGBOAT KEY, FLORIDA						
COLONY BEACH & TENNIS CLUB						
LONGBOAT KEY SARASOTA FLORIDA						
ENGINEER LOCATION						
SHEET NUMBER	78-B					
REVISION						
T.L.K. FILE NO.	G-1217-380					