


GULF OF MEXICO



VILLA DI LANCIA

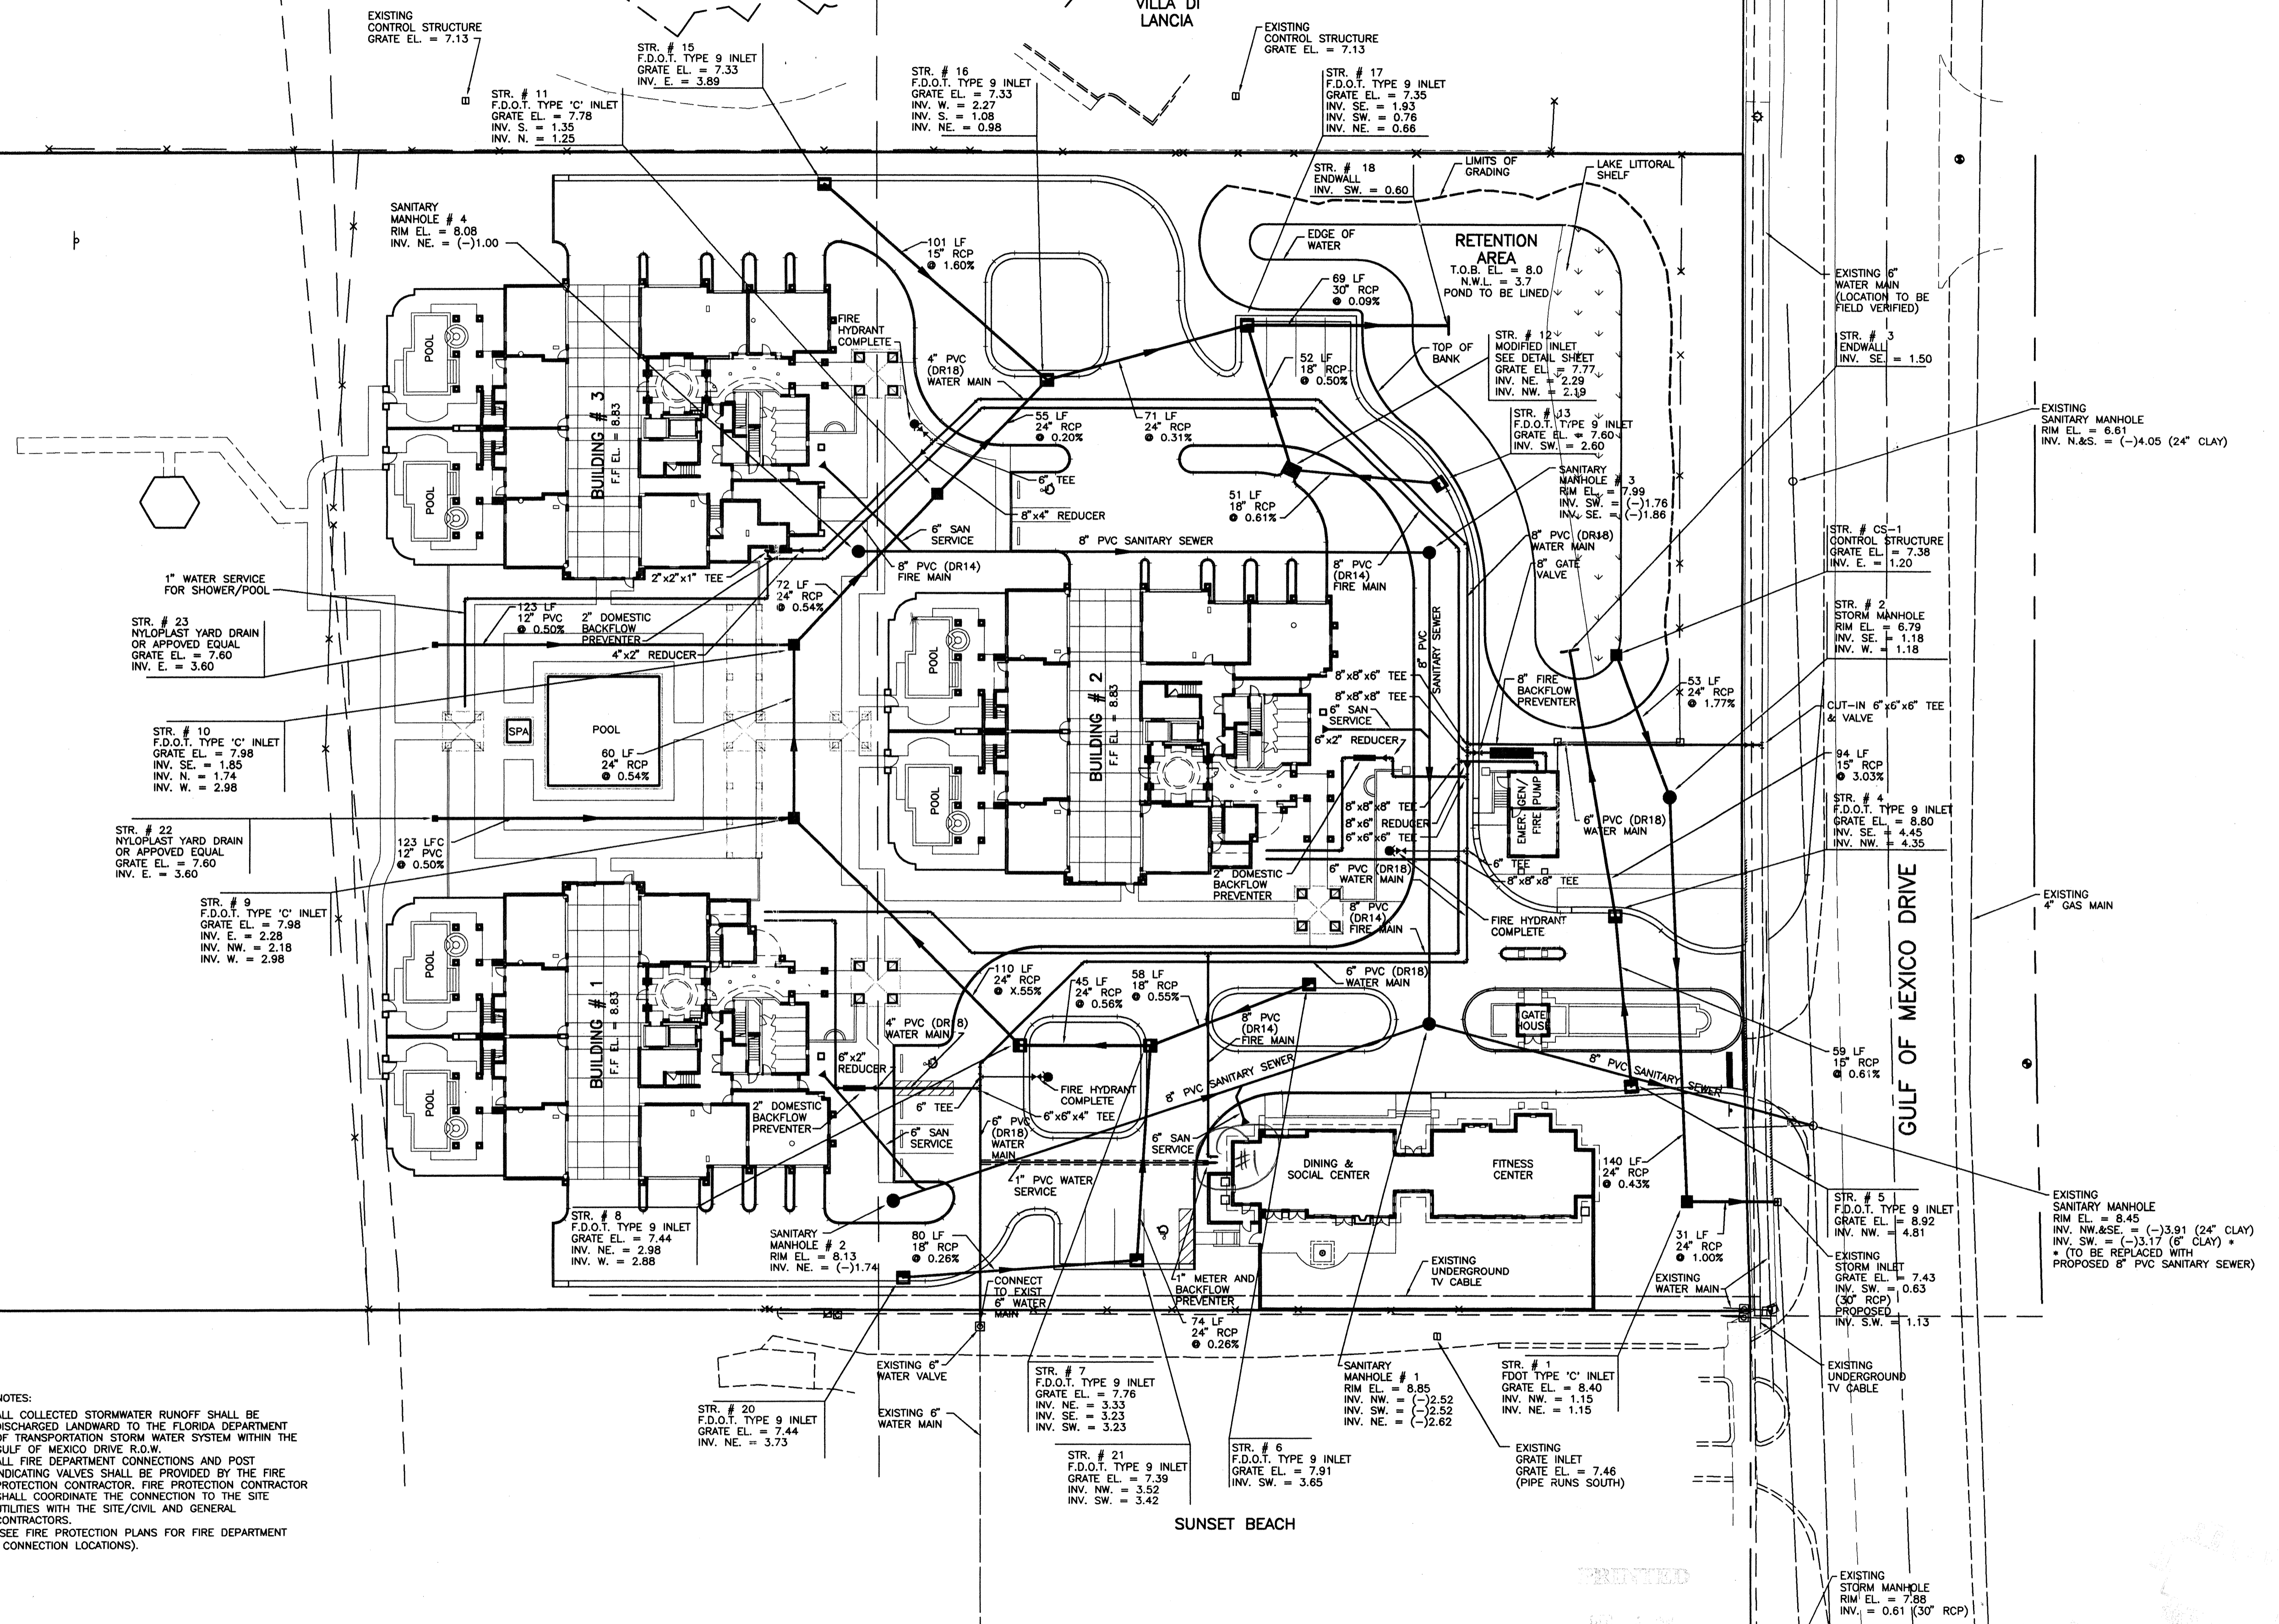

NOTES:

- ALL COLLECTED STORMWATER RUNOFF SHALL BE DISCHARGED LANDWARD TO THE FLORIDA DEPARTMENT OF TRANSPORTATION STORM WATER SYSTEM WITHIN THE GULF OF MEXICO DRIVE R.O.W.
- ALL FIRE DEPARTMENT CONNECTIONS AND POST INDICATING VALVES SHALL BE PROVIDED BY THE FIRE PROTECTION CONTRACTOR. FIRE PROTECTION CONTRACTOR SHALL COORDINATE THE CONNECTION TO THE SITE UTILITIES WITH THE SITE/CIVIL AND GENERAL CONTRACTORS. (SEE FIRE PROTECTION PLANS FOR FIRE DEPARTMENT CONNECTION LOCATIONS).

GULF OF MEXICO DRIVE

SUNSET BEACH

REV	DATE	BY	DESCRIPTION
D	12/5/00	DKL/1239	REVISED PER TOWN OF LONGBOAT KEY COMMENTS - ADD/RELOCATE FIRE HYDRANTS
C	8/15/00	DKL/1239	ADD YARD DRAINS WEST OF POOL DECK - DRAINAGE NOTE
A	6/7/00	DKL/1239	REVISE PER TOWN OF LONGBOAT KEY AND F.D.O.T. COMMENTS

WilsonMiller
 Planners • Engineers • Ecologists • Surveyors • Landscape Architects • Transportation Consultants
 Naples • Fort Myers • Sarasota • Bradenton • Tampa
 6900 Professional Parkway East, Suite 100 • Sarasota, Florida 34240-9466 • Phone 941-557-5900 • Fax 941-557-6910 • Web Site www.wilsonmiller.com

CLIENT: LAURELTON MERRICK CORPORATION
 PROJECT: EN PROVENCE

DATE: 4/00
 HORIZONTAL SCALE: 1" = 30'
 VERTICAL SCALE: 1" = 10'

TITLE: DRAINAGE AND UTILITY PLAN
 SHEET NUMBER: 4 OF 12
 PROJECT NUMBER: 03317-000-000-FLPCP
 CROSS REFERENCE FILE NO.: 17 36S 17E 331702M1

12/6/00
 MILLARU J. YODER, P.E.
 FLORIDA CERTIFICATE NO. 33765
 INDEX NUMBER: D-03317-000-000023
 SHEET NUMBER: 4 OF 12