


- LEGEND**
- SANITARY SEWER
 - - - STORM SEWER LINE
 - WATER MAIN
 - - - PROPANE GAS LINE
 - - - ELECTRICAL CABLE
 - MH-2H SANITARY MANHOLE
 - STA STORM SEWER MANHOLE
 - C.O. CLEAN OUT
 - RD-4 ROOF DRAIN
 - S13A CATCH BASIN

SANITARY SEWER PROFILE SHEET NO. 251-545 AB
 STORM SEWER PROFILE SHEET NO. 251-509 AB

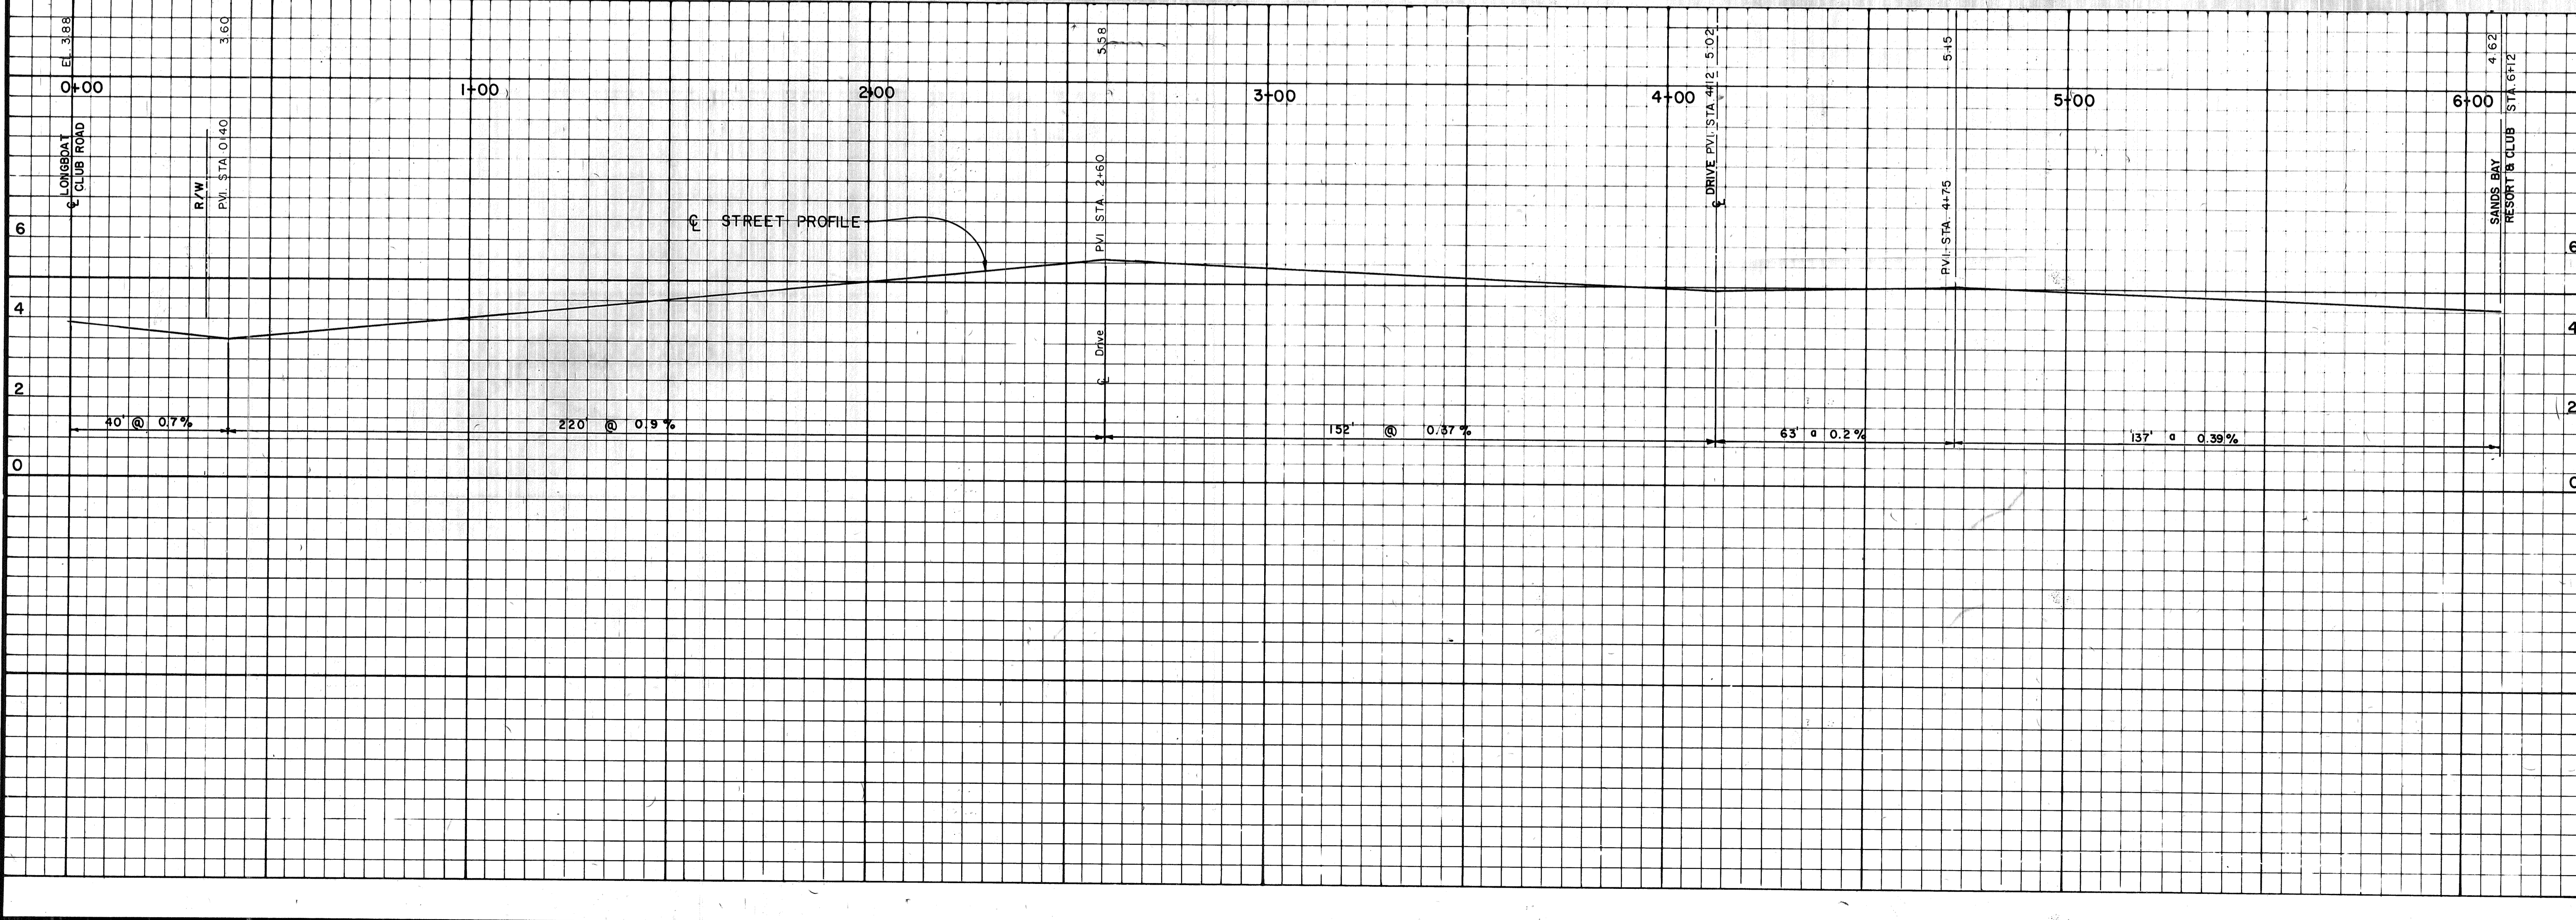

TOWN OF LONGBOAT KEY, FLORIDA
 ARVIDA CORPORATION
 INN ON THE BEACH (FORMERLY LONGBOAT KEY RESORT & CLUB)
 SANDS POINT ROAD PLAN AND PROFILE
 BENNETT & BISHOP, INC. - CONSULTING ENGINEERS & SURVEYORS - 4509 BEE RIDGE RD. SARASOTA, FLORIDA

DESIGNED BY: [] ENGINEER
 CHECKED BY: []
 DATE: 11-17-83
 SCALE: HORIZ. 1"=20'
 VERT. 1"=2'

BY: []
 REVISION: []
 LTR. DATE: []

SHEET NUMBER: 251-515AB
 REVISION: []