


**LEGEND**

- SANITARY SEWER
- STORM SEWER LINE
- WATER MAIN
- PROPANE GAS LINE
- ELECTRICAL CABLE
- MH2H SANITARY MANHOLE
- S7A STORM SEWER MANHOLE
- C.O. CLEAN OUT
- RD-4 ROOF DRAIN
- S13A CATCH BASIN

SANITARY SEWER PROFILE SHEET NO. 251-545 AB  
 STORM SEWER PROFILE SHEET NO. 251-509 AB

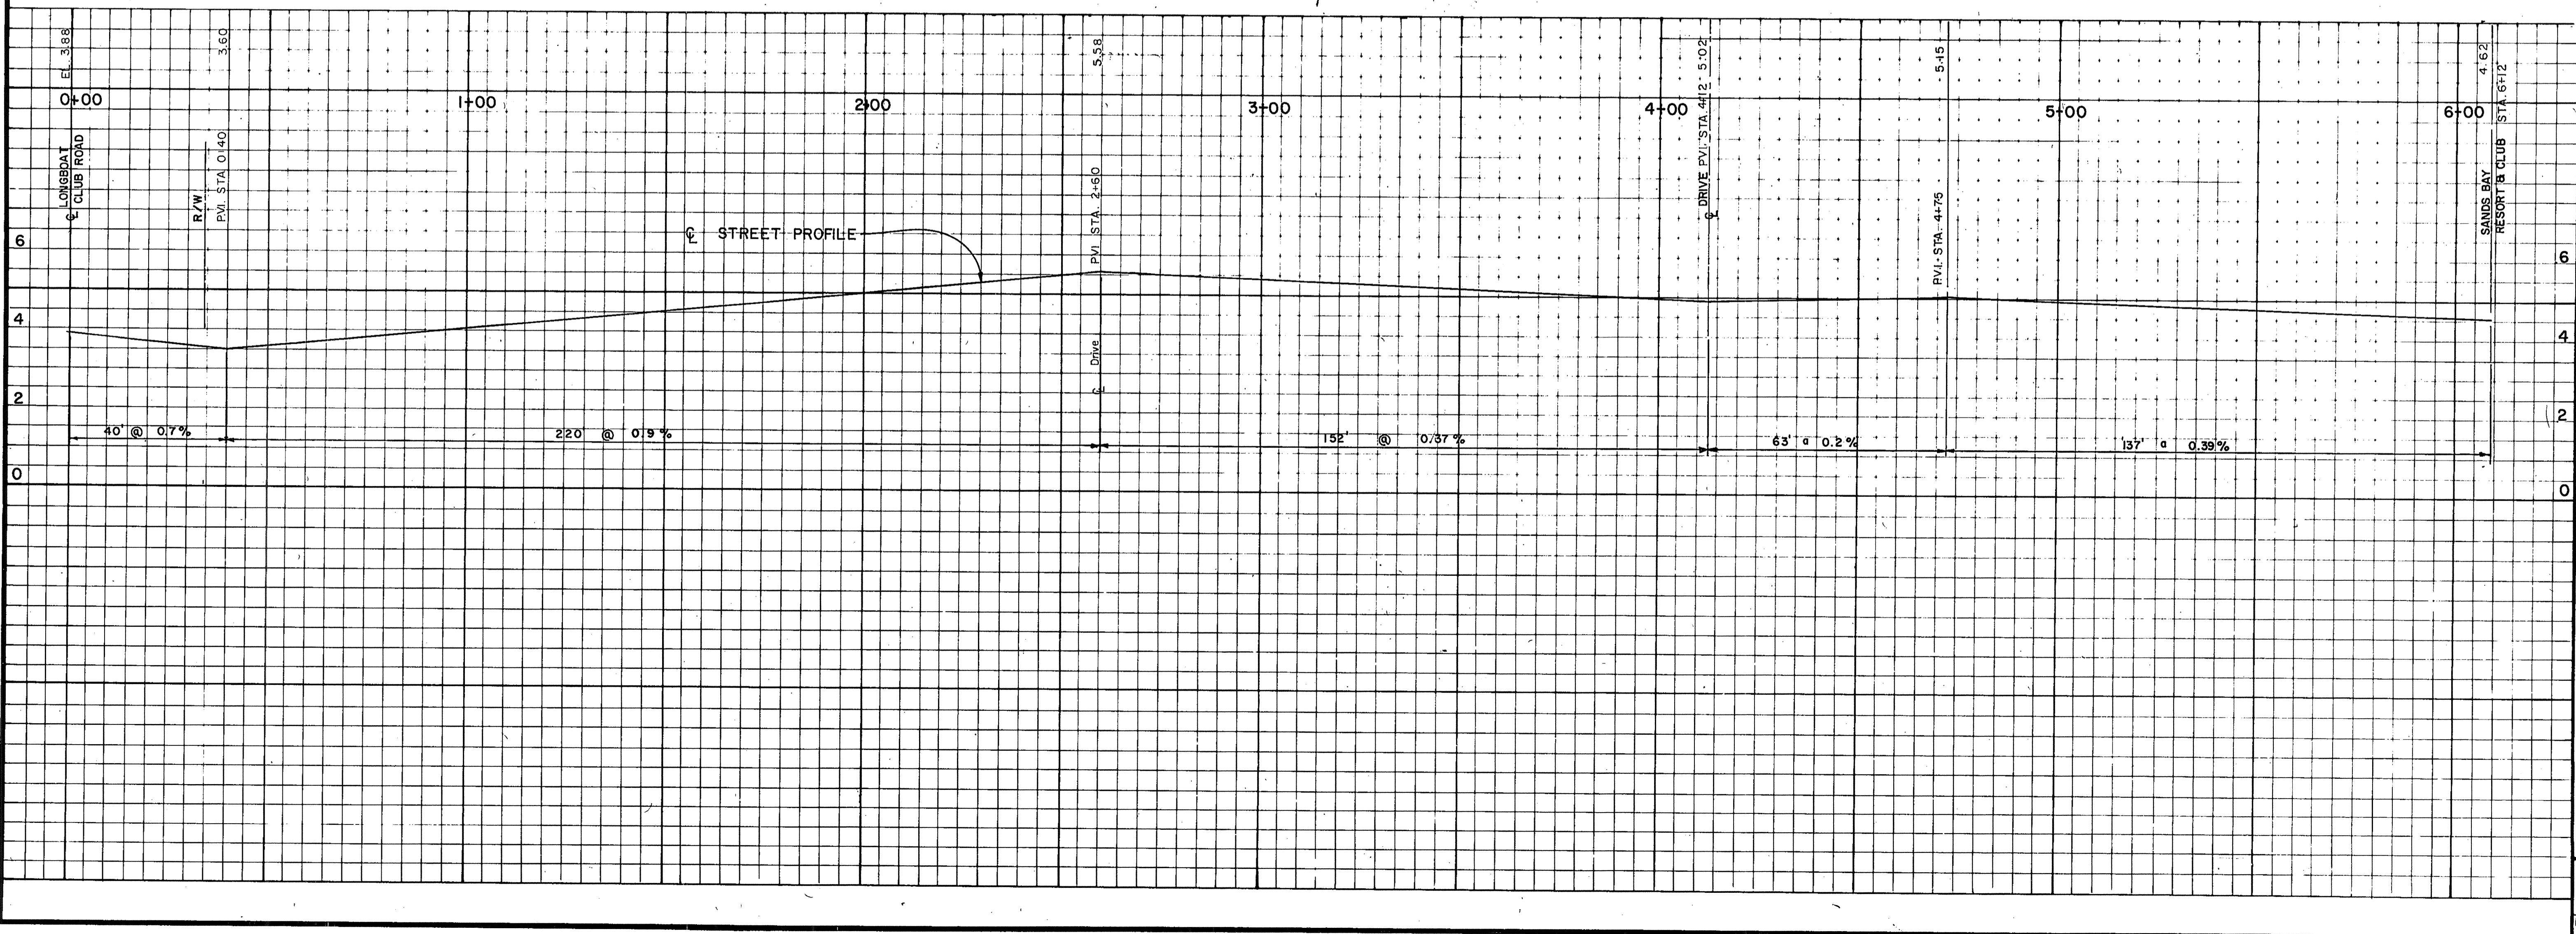

**TOWN OF LONGBOAT KEY, FLORIDA**  
 ARVIDA CORPORATION  
 INN ON THE BEACH ( FORMERLY LONGBOAT KEY RESORT & CLUB )  
 SANDS POINT ROAD PLAN AND PROFILE

ENGINEER & SURVEYOR  
 BENNETT & BISHOP, INC. — CONSULTING ENGINEERS & SURVEYORS — 4509 BEE RIDGE RD. SARASOTA, FLORIDA

DESIGNED BY: [ ]  
 CHECKED BY: [ ]  
 DRAWN BY: [ ]  
 SCALE: 1"=20'  
 HORIZ. 1"=20'  
 VERT. 1"=2'

REVISION: [ ] DATE: [ ] LTR. DATE: [ ]

SHEET NUMBER  
**251-515 AB**  
 REVISION: [ ]

T.L.K. FILE NO.