



NOTE: THIS PLAN IS SOLELY INTENDED FOR USE AS SANITARY PLAN + PROFILE ONLY.

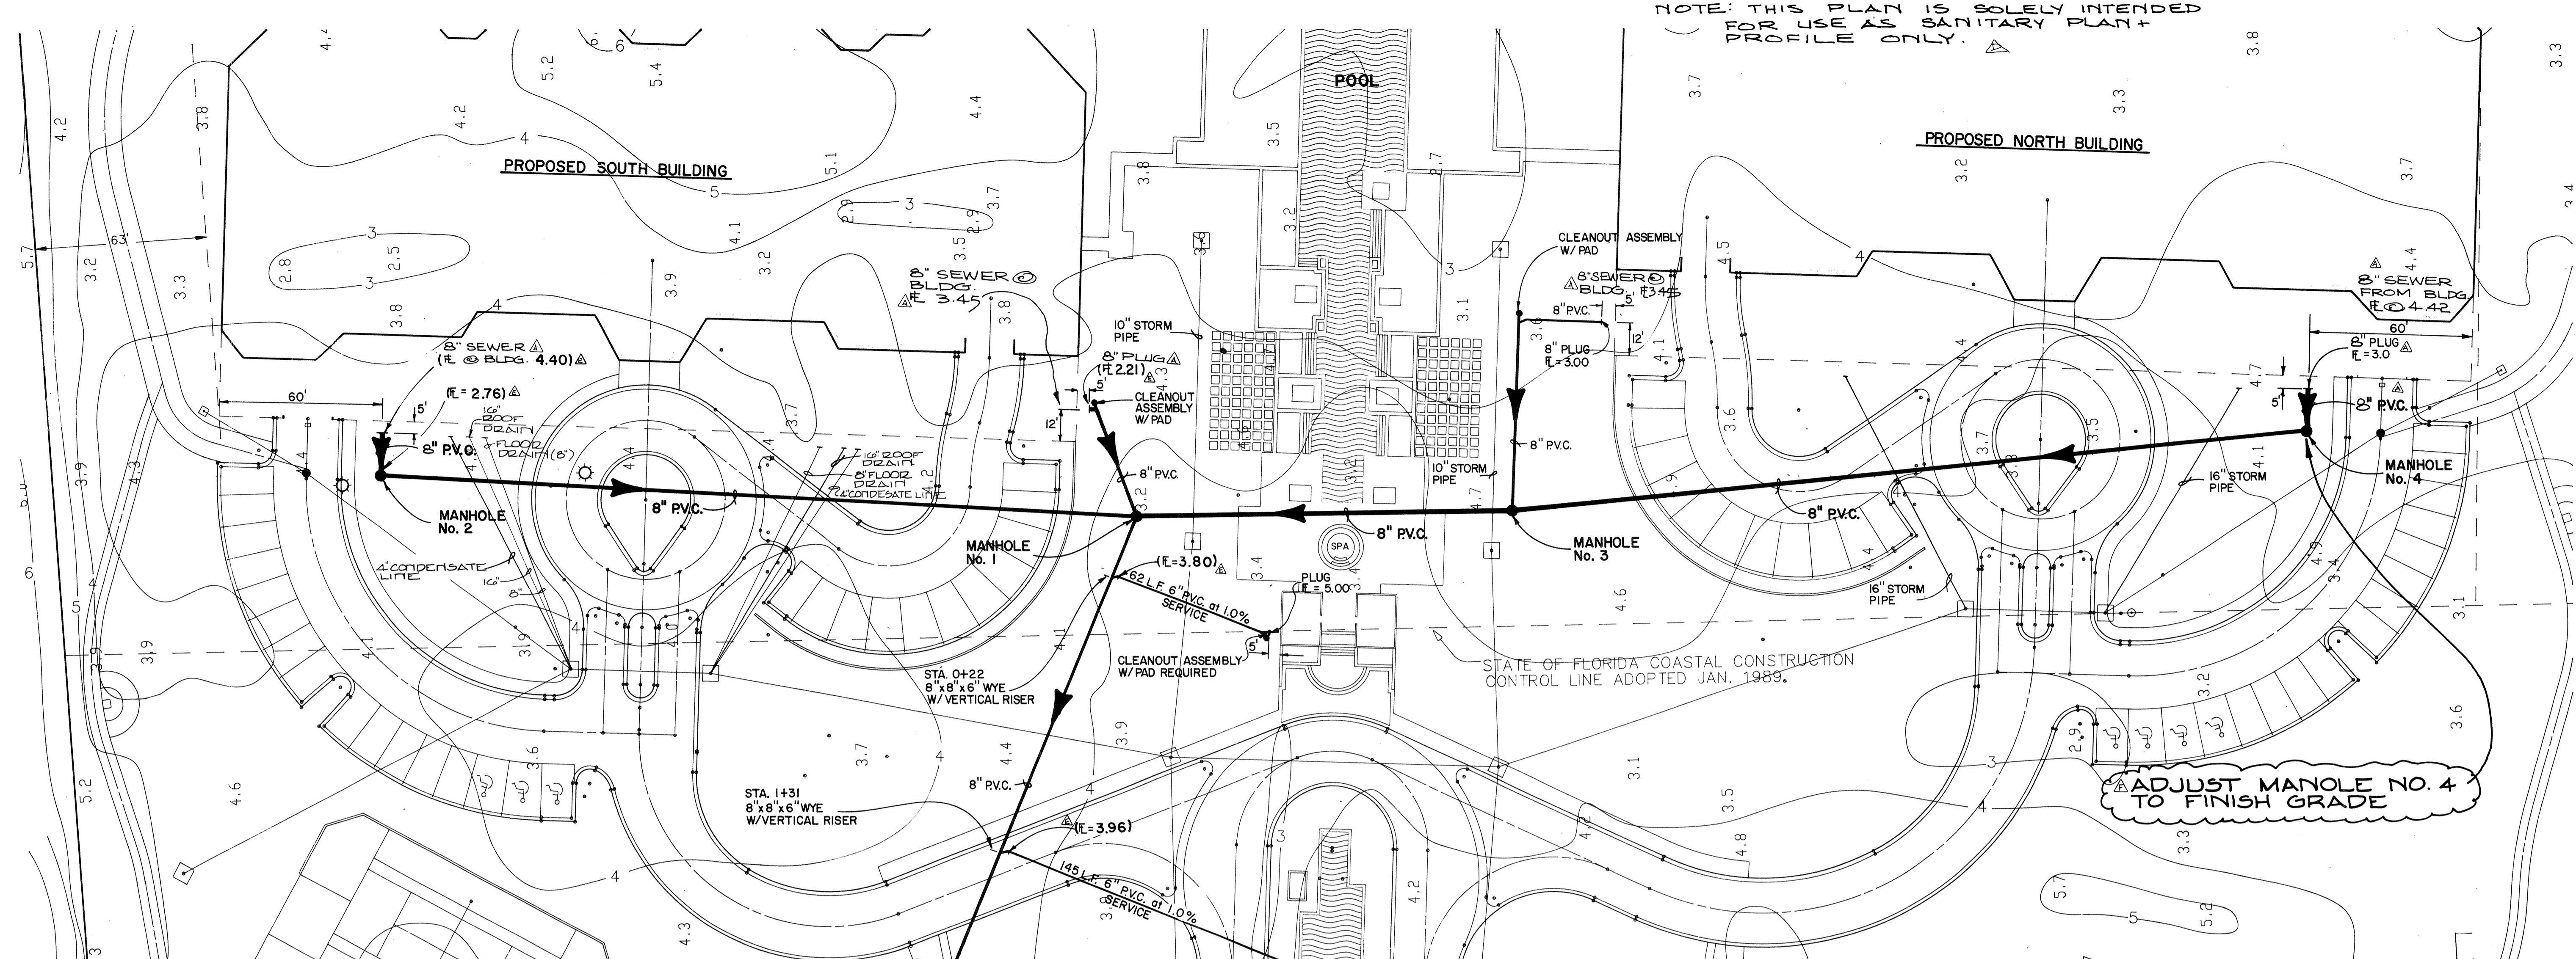

DATA IN BRACKETS CONFORM DRAWINGS TO CONSTRUCTION RECORDS BY TRI-D SEPTEMBER 1992

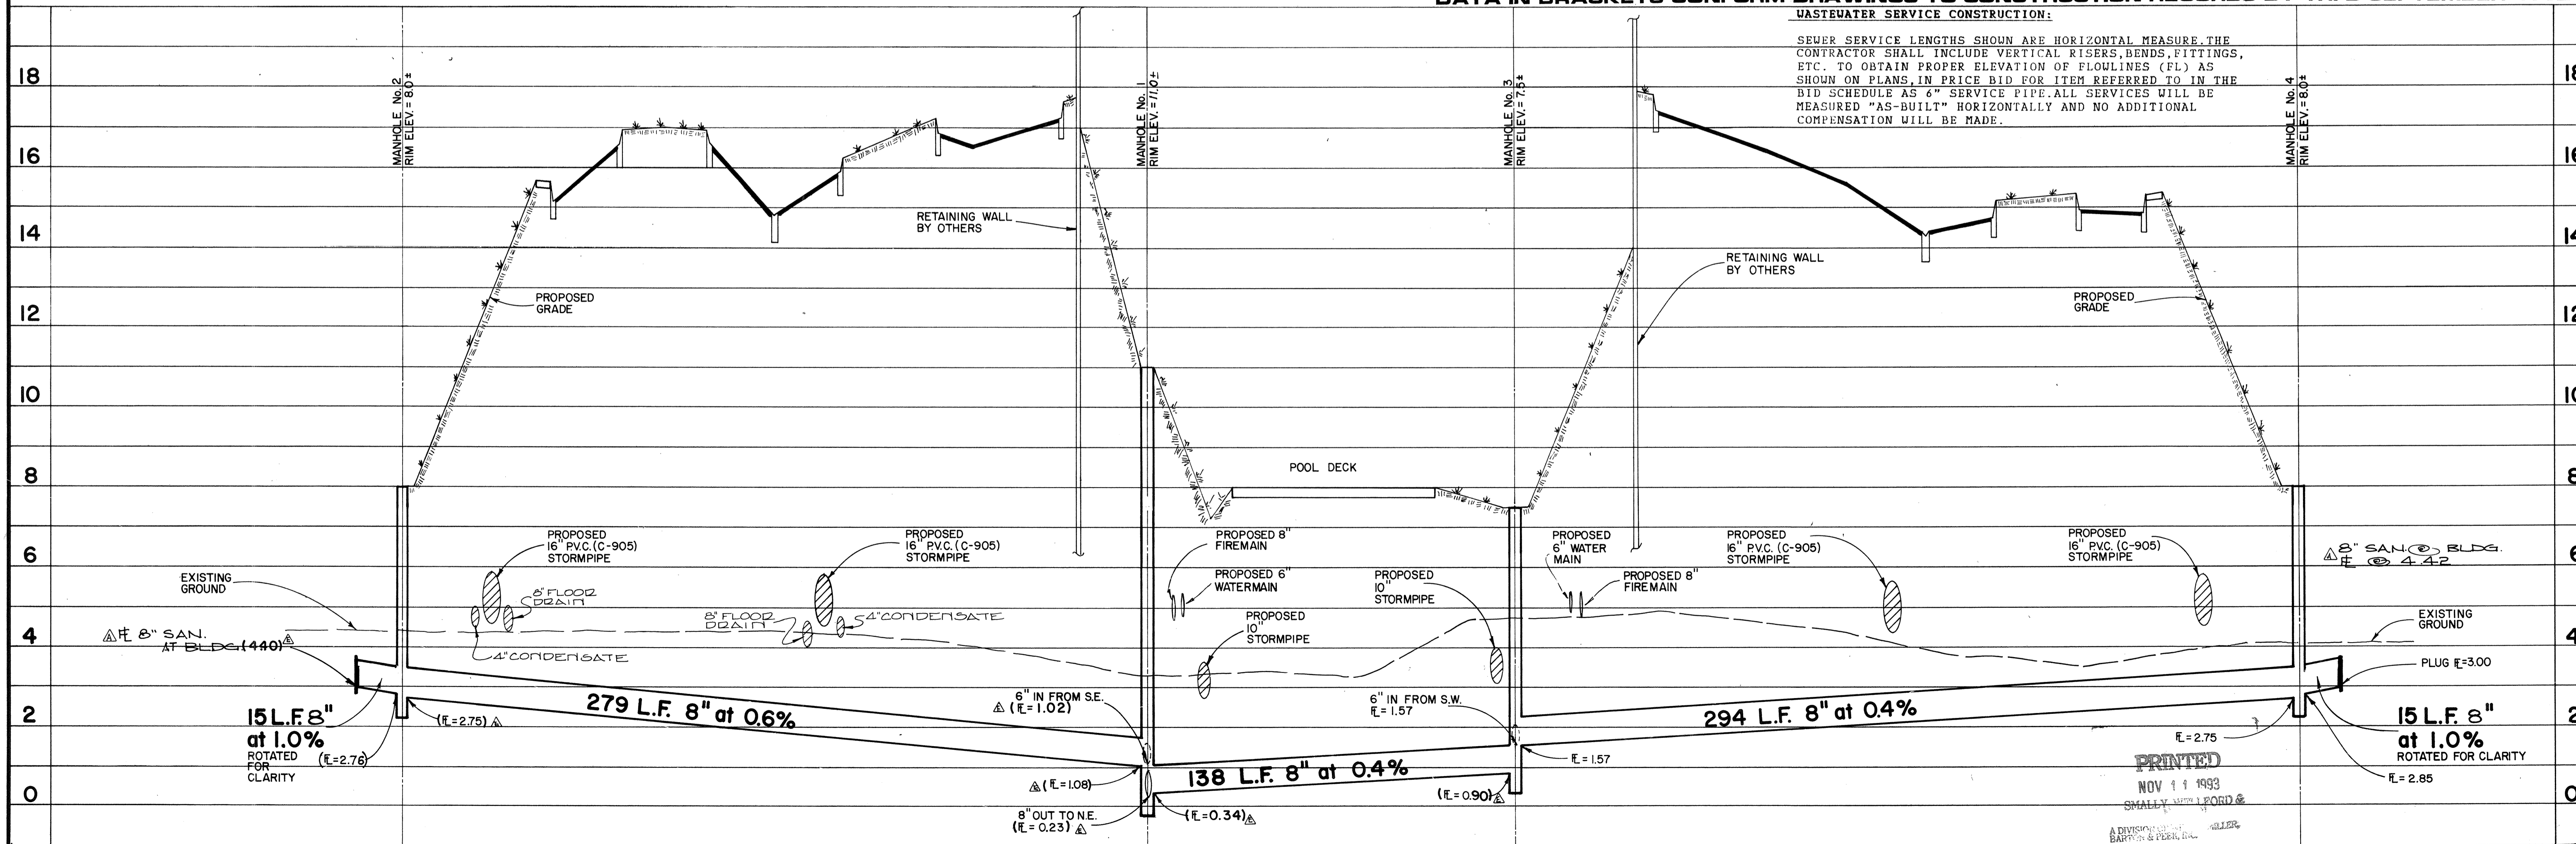

**WASTEWATER SERVICE CONSTRUCTION:**  
SEWER SERVICE LENGTHS SHOWN ARE HORIZONTAL MEASURE. THE CONTRACTOR SHALL INCLUDE VERTICAL RISERS, BENDS, FITTINGS, ETC. TO OBTAIN PROPER ELEVATION OF FLOWLINES (FL) AS SHOWN ON PLANS, IN PRICE BID FOR ITEM REFERRED TO IN THE BID SCHEDULE AS 6" SERVICE PIPE. ALL SERVICES WILL BE MEASURED "AS-BUILT" HORIZONTALLY AND NO ADDITIONAL COMPENSATION WILL BE MADE.

PRINTED  
NOV 11 1993  
SMALLY, WELLFORD & NALVEN, INC.

L.T.R.	DATE	REVISION	BY	SCALE	DATE	DESIGNED BY
	11-01-93	1. REVISE SIZE AS INDICATED	J.M.B.	1" = 30'	7/90	J.M.B.
	11-10-92	2. REVISE PER PERMITS		1" = 2'		
	11-06-92	3. ADD NOTES TO CONSTRUCTION RECORDS				
	10-16-92	4. ADD NOTE RE: MANHOLE GRADE				
FOR: YALE PROPERTIES						
L'AMBIANCE						
SANITARY SEWER PLAN & PROFILE						
SMALLY, WELLFORD & NALVEN, INC.						
CONSULTING ENGINEERS & SURVEYORS						
133 SOUTH MCINTOSH RD.						
SARASOTA, FLA. 33562						
DRAWING NUMBER						
15						
REVISION						
F						
DRAWN BY CHECKED BY PROJECT NO. MILLARD J. YODER FL. CERT. # 33765						
2590						