



NOTE: THIS PLAN IS SOLELY INTENDED FOR USE AS SANITARY PLAN + PROFILE ONLY.

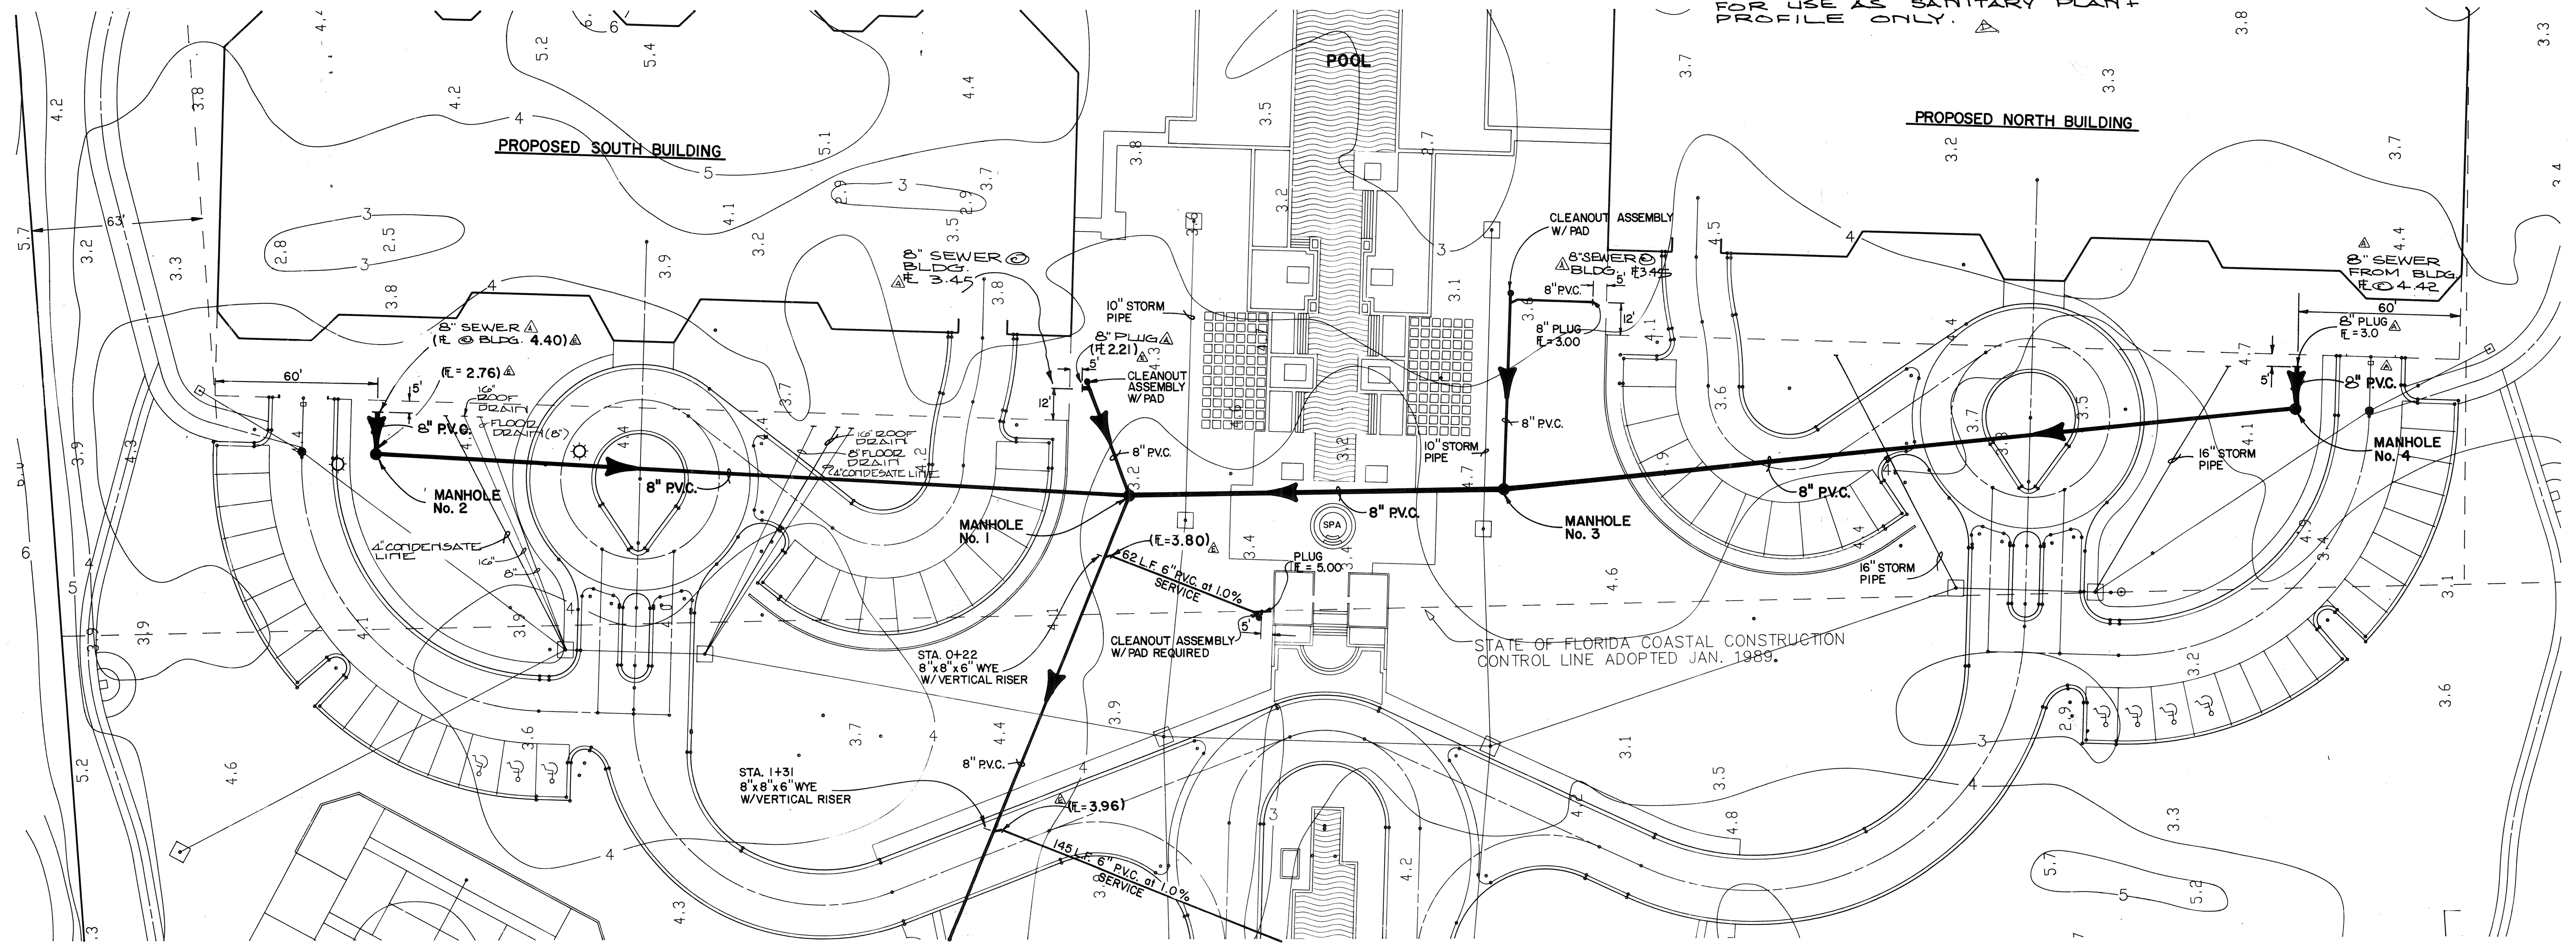

DATA IN BRACKETS CONFORM DRAWINGS TO CONSTRUCTION RECORDS BY TRI-D SEPTEMBER 1992

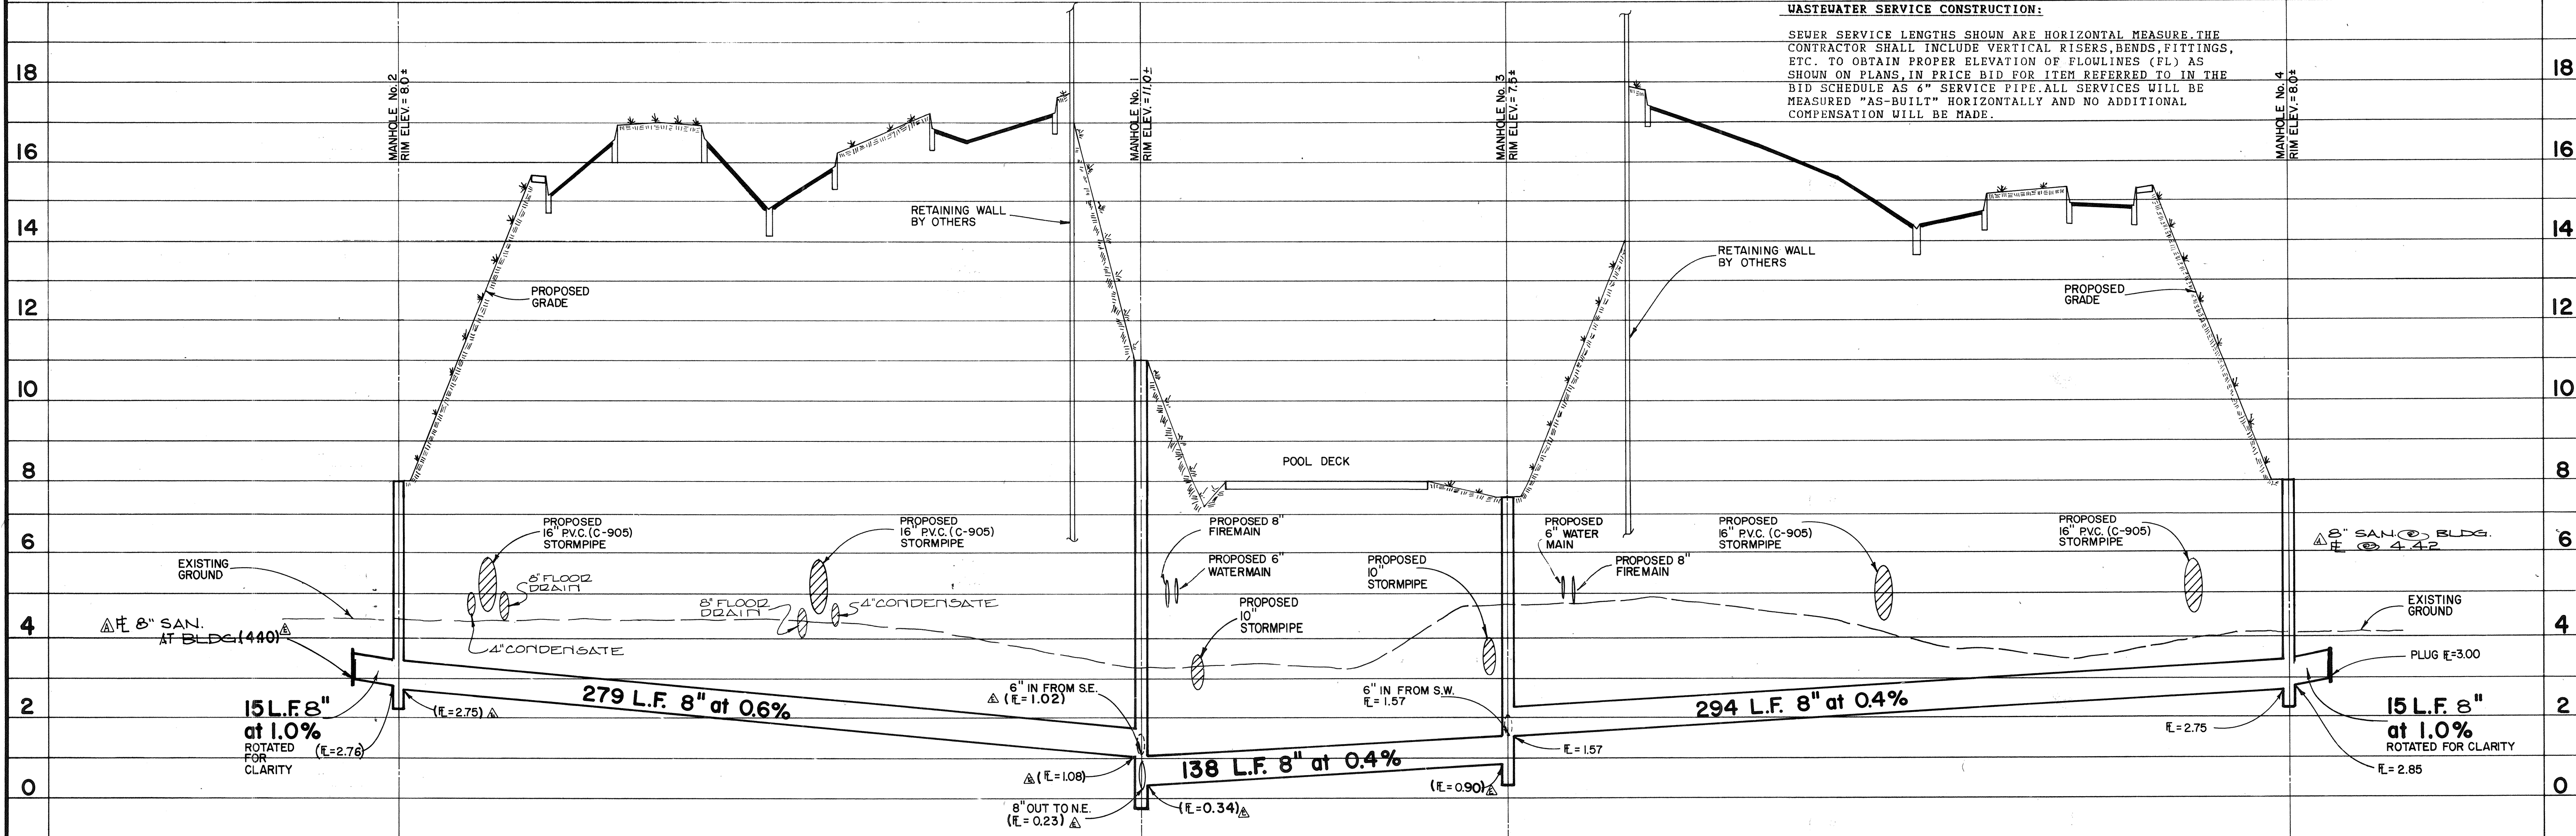

WASTEWATER SERVICE CONSTRUCTION:  
SEWER SERVICE LENGTHS SHOWN ARE HORIZONTAL MEASURE. THE CONTRACTOR SHALL INCLUDE VERTICAL RISERS, BENDS, FITTINGS, ETC. TO OBTAIN PROPER ELEVATION OF FLOWLINES (FL) AS SHOWN ON PLANS. IN PRICE BID FOR ITEM REFERRED TO IN THE BID SCHEDULE AS 4" SERVICE PIPE, ALL SERVICES WILL BE MEASURED "AS-BUILT" HORIZONTALLY AND NO ADDITIONAL COMPENSATION WILL BE MADE.

DATE	REVISION	BY	SCALE	DATE	DESIGNED BY
10/15/92	1. ADD SEWER SERVICE LENGTHS AS INDICATED IN PROFILE. 2. REVISE WATER LINE ELEVATIONS AS INDICATED IN PROFILE. 3. REVISE STORM PIPE ELEVATIONS AS INDICATED IN PROFILE. 4. REVISE MANHOLE ELEVATIONS AS INDICATED IN PROFILE. 5. REVISE CLEANOUT ASSEMBLY ELEVATIONS AS INDICATED IN PROFILE. 6. REVISE PLUG ELEVATIONS AS INDICATED IN PROFILE. 7. REVISE SPA ELEVATION AS INDICATED IN PROFILE. 8. REVISE 8\"/> <td>W.P.</td> <td>1" = 30' HOR. 1" = 2' VER.</td> <td>7/90</td> <td>J.M.B.</td>	W.P.	1" = 30' HOR. 1" = 2' VER.	7/90	J.M.B.
		DRWN BY		CHECKED BY	PROJECT NO.
		R.B.K.		2590	MILLARD J. YODER
					FL. CERT. # 33765
CONSULTING ENGINEERS & SURVEYORS					
SMALLY, WELLFORD & NALVEN, INC.					
133 SOUTH MCINTOSH RD. SARASOTA, FLA. 33562					
FOR: YALE PROPERTIES					
L'AMBIANCE					
SANITARY SEWER PLAN & PROFILE					
DRAWING NUMBER					
15					
REVISION					
E					