



NOTE: THIS PLAN IS SOLELY INTENDED FOR USE AS SANITARY PLAN + PROFILE ONLY.

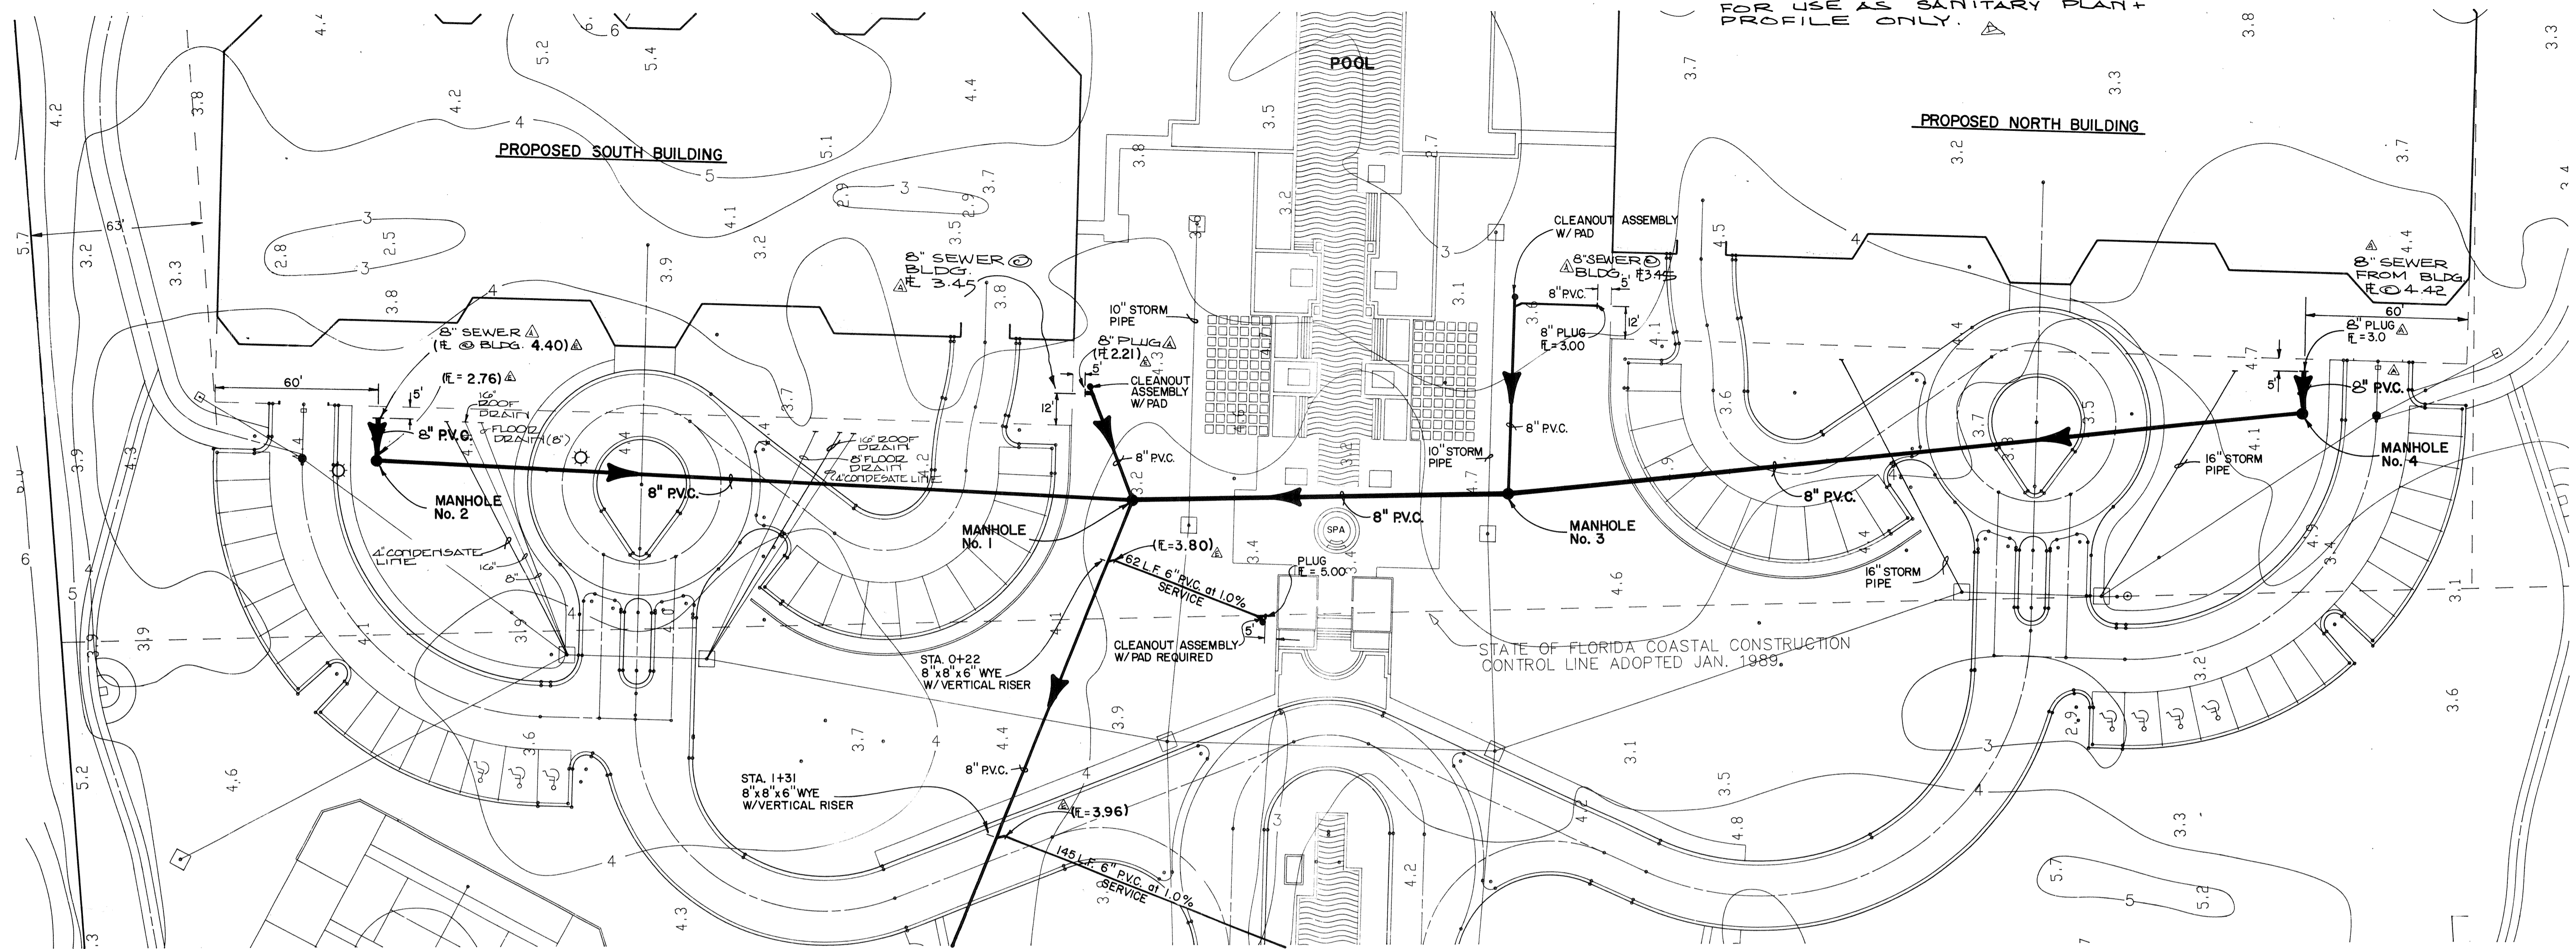

DATA IN BRACKETS CONFORM DRAWINGS TO CONSTRUCTION RECORDS BY TRI-D SEPTEMBER 1992

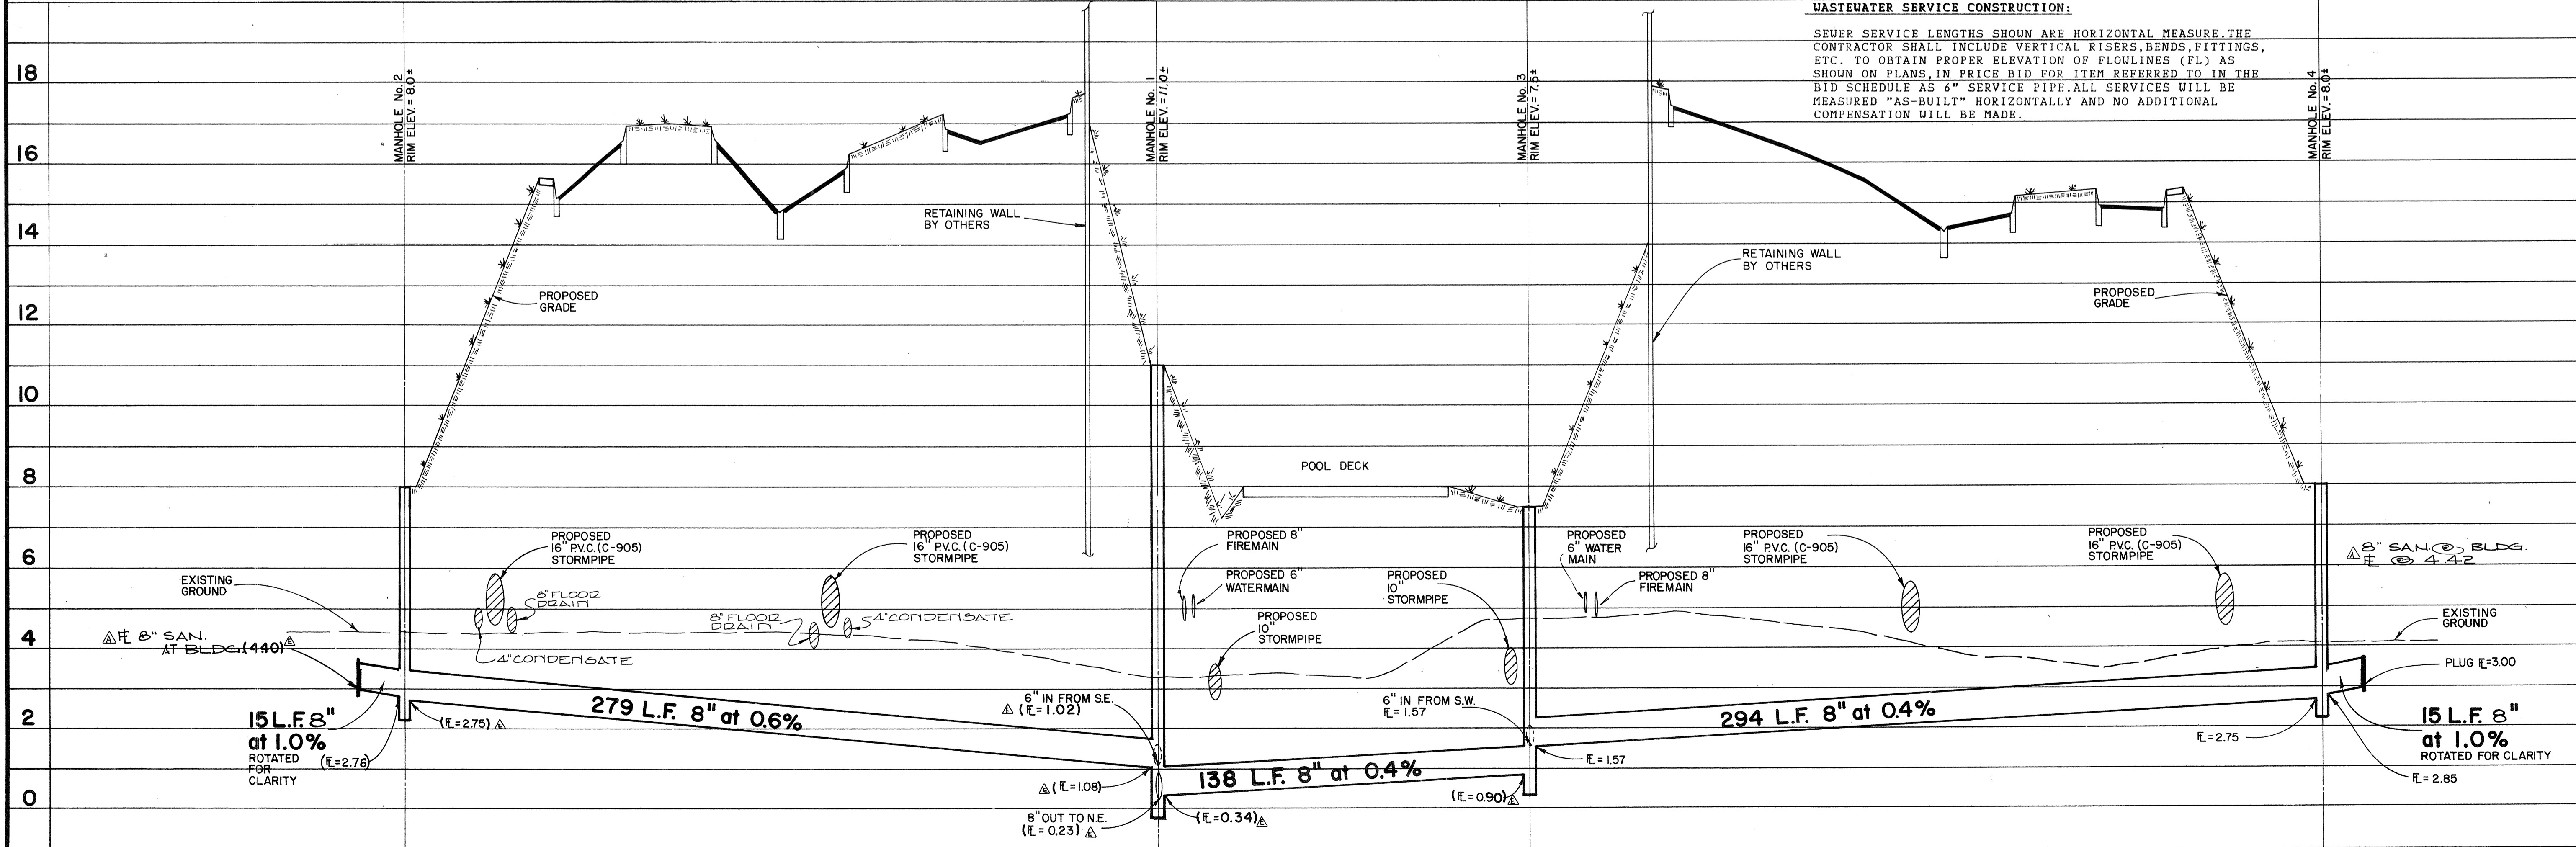

DATE	7/12	REVISION	1	BY	R.B.K.	SCALE	1" = 30'	DATE	7/90	DESIGNED BY	J.M.B.
LTR.	1	DATE	7/12	BY	R.B.K.	SCALE	1" = 30'	DATE	7/90	DESIGNED BY	J.M.B.
<p>FOR: YALE PROPERTIES L'AMBIANCE SANITARY SEWER PLAN & PROFILE SMALLY, WELLFORD & NALVEN, INC.</p>											
<p>CONSULTING ENGINEERS & SURVEYORS 133 SOUTH MCINTOSH RD. SARASOTA, FLA. 33582</p>											
<p>INDEX NO. 6-2591-020</p>											