

STORM SEWER SCHEDULE

STR. NO.	TYPE	RIM EL.	INV. IN	INV. OUT	FROM	TO	LENGTH	SIZE AND TYPE
S-10	EX. CURB IN	6.22	0.22	0.22	0-10	5-12	120 LF	8" PVC
S-11	JUNCT. BOX	5.50	0.22	0.22	5-11	5-12	10 LF	18" DIA.
S-12	JUNCT. BOX	6.07	0.22	0.22	4-12	5-13	10 LF	18" DIA.
S-13	JUNCT. BOX	5.78	0.22	0.22	5-13	5-14	10 LF	18" DIA.
S-14	CURB INLET	5.57	0.22	0.22	5-14	5-15	10 LF	18" DIA.
S-15	CURB INLET	6.11	0.22	0.22	5-15	5-16	10 LF	18" DIA.
S-16	CURB INLET	5.78	0.22	0.22	5-16	5-17	10 LF	18" DIA.
S-17	CURB INLET	6.11	0.22	0.22	5-17	5-18	10 LF	18" DIA.
S-18	CURB INLET	6.11	0.22	0.22	5-18	5-19	10 LF	18" DIA.
S-19	CURB INLET	5.78	0.22	0.22	5-19	5-20	10 LF	18" DIA.
S-20	CURB INLET	5.78	0.22	0.22	5-20	5-21	33 LF	18" DIA.
S-21	CURB INLET	6.42	0.22	0.22				
S-13	CURB INLET	5.78	0.22	0.22	S-13	5-18	41 LF	18" DIA.
S-18	CURB INLET	5.57	0.22	0.22	S-18	5-19	77 LF	18" DIA.
S-19	CURB INLET	6.07	0.22	0.22	S-19	5-22	67 LF	18" DIA.
S-22	YARD DRAIN	3.70	0.22	0.22				


SANITARY SEWER SCHEDULE

STR. NO.	TYPE	RIM EL.	INV. IN	INV. OUT	FROM	TO	LENGTH	SIZE AND TYPE
2H 1.4	EXIST. M.H.	4.68	-0.99	-0.99	2H 1.4	2H 1.5	156 LF	10" PVC
2H 1.5	MANHOLE	5.69	-0.55	-0.55	2H 1.5	1	133 LF	8" PVC
1	MANHOLE	6.24	-0.02	-0.02	1	2	86 LF	8" PVC
2	MANHOLE	5.90	0.33	0.33	2	3	114 LF	8" PVC
3	MANHOLE	6.45	0.76	0.76	3	4	66 LF	8" PVC
4	MANHOLE	6.82	1.05	1.05	4	5	96 LF	8" PVC
5	MANHOLE	6.89	1.43	1.43	5	6	75 LF	8" PVC
6	MANHOLE	6.92	2.14	2.14	6	7	62 LF	8" PVC
7	MANHOLE	6.31	2.79	2.79	7	8	120 LF	8" PVC
8	MANHOLE	6.66	4.11	4.11				

LEGEND

- WM — PROP. WATERMAIN w/HYD.
- SD — PROP. STORM DRAIN w/INLET
- SAN — PROP. SANITARY SEWER w/MH
- SP — PROP. SPOT ELEVATION
- GM — PROP. GASMAIN
- PR — PROP. PAVEMENT REMOVAL AREA TO BE REPLACED WITH LANDSCAPING
- PI — PROP. PAVEMENT IMPROVEMENTS

INVESTIGATE BEFORE YOU EXCAVATE
"CALL CANDY"
 1-800-282-8881
 FL STATUTE 353.853 (1979) REQUIRES MIN. OF 3 DAYS AND MAX. OF 5 DAYS NOTICE BEFORE YOU EXCAVATE.

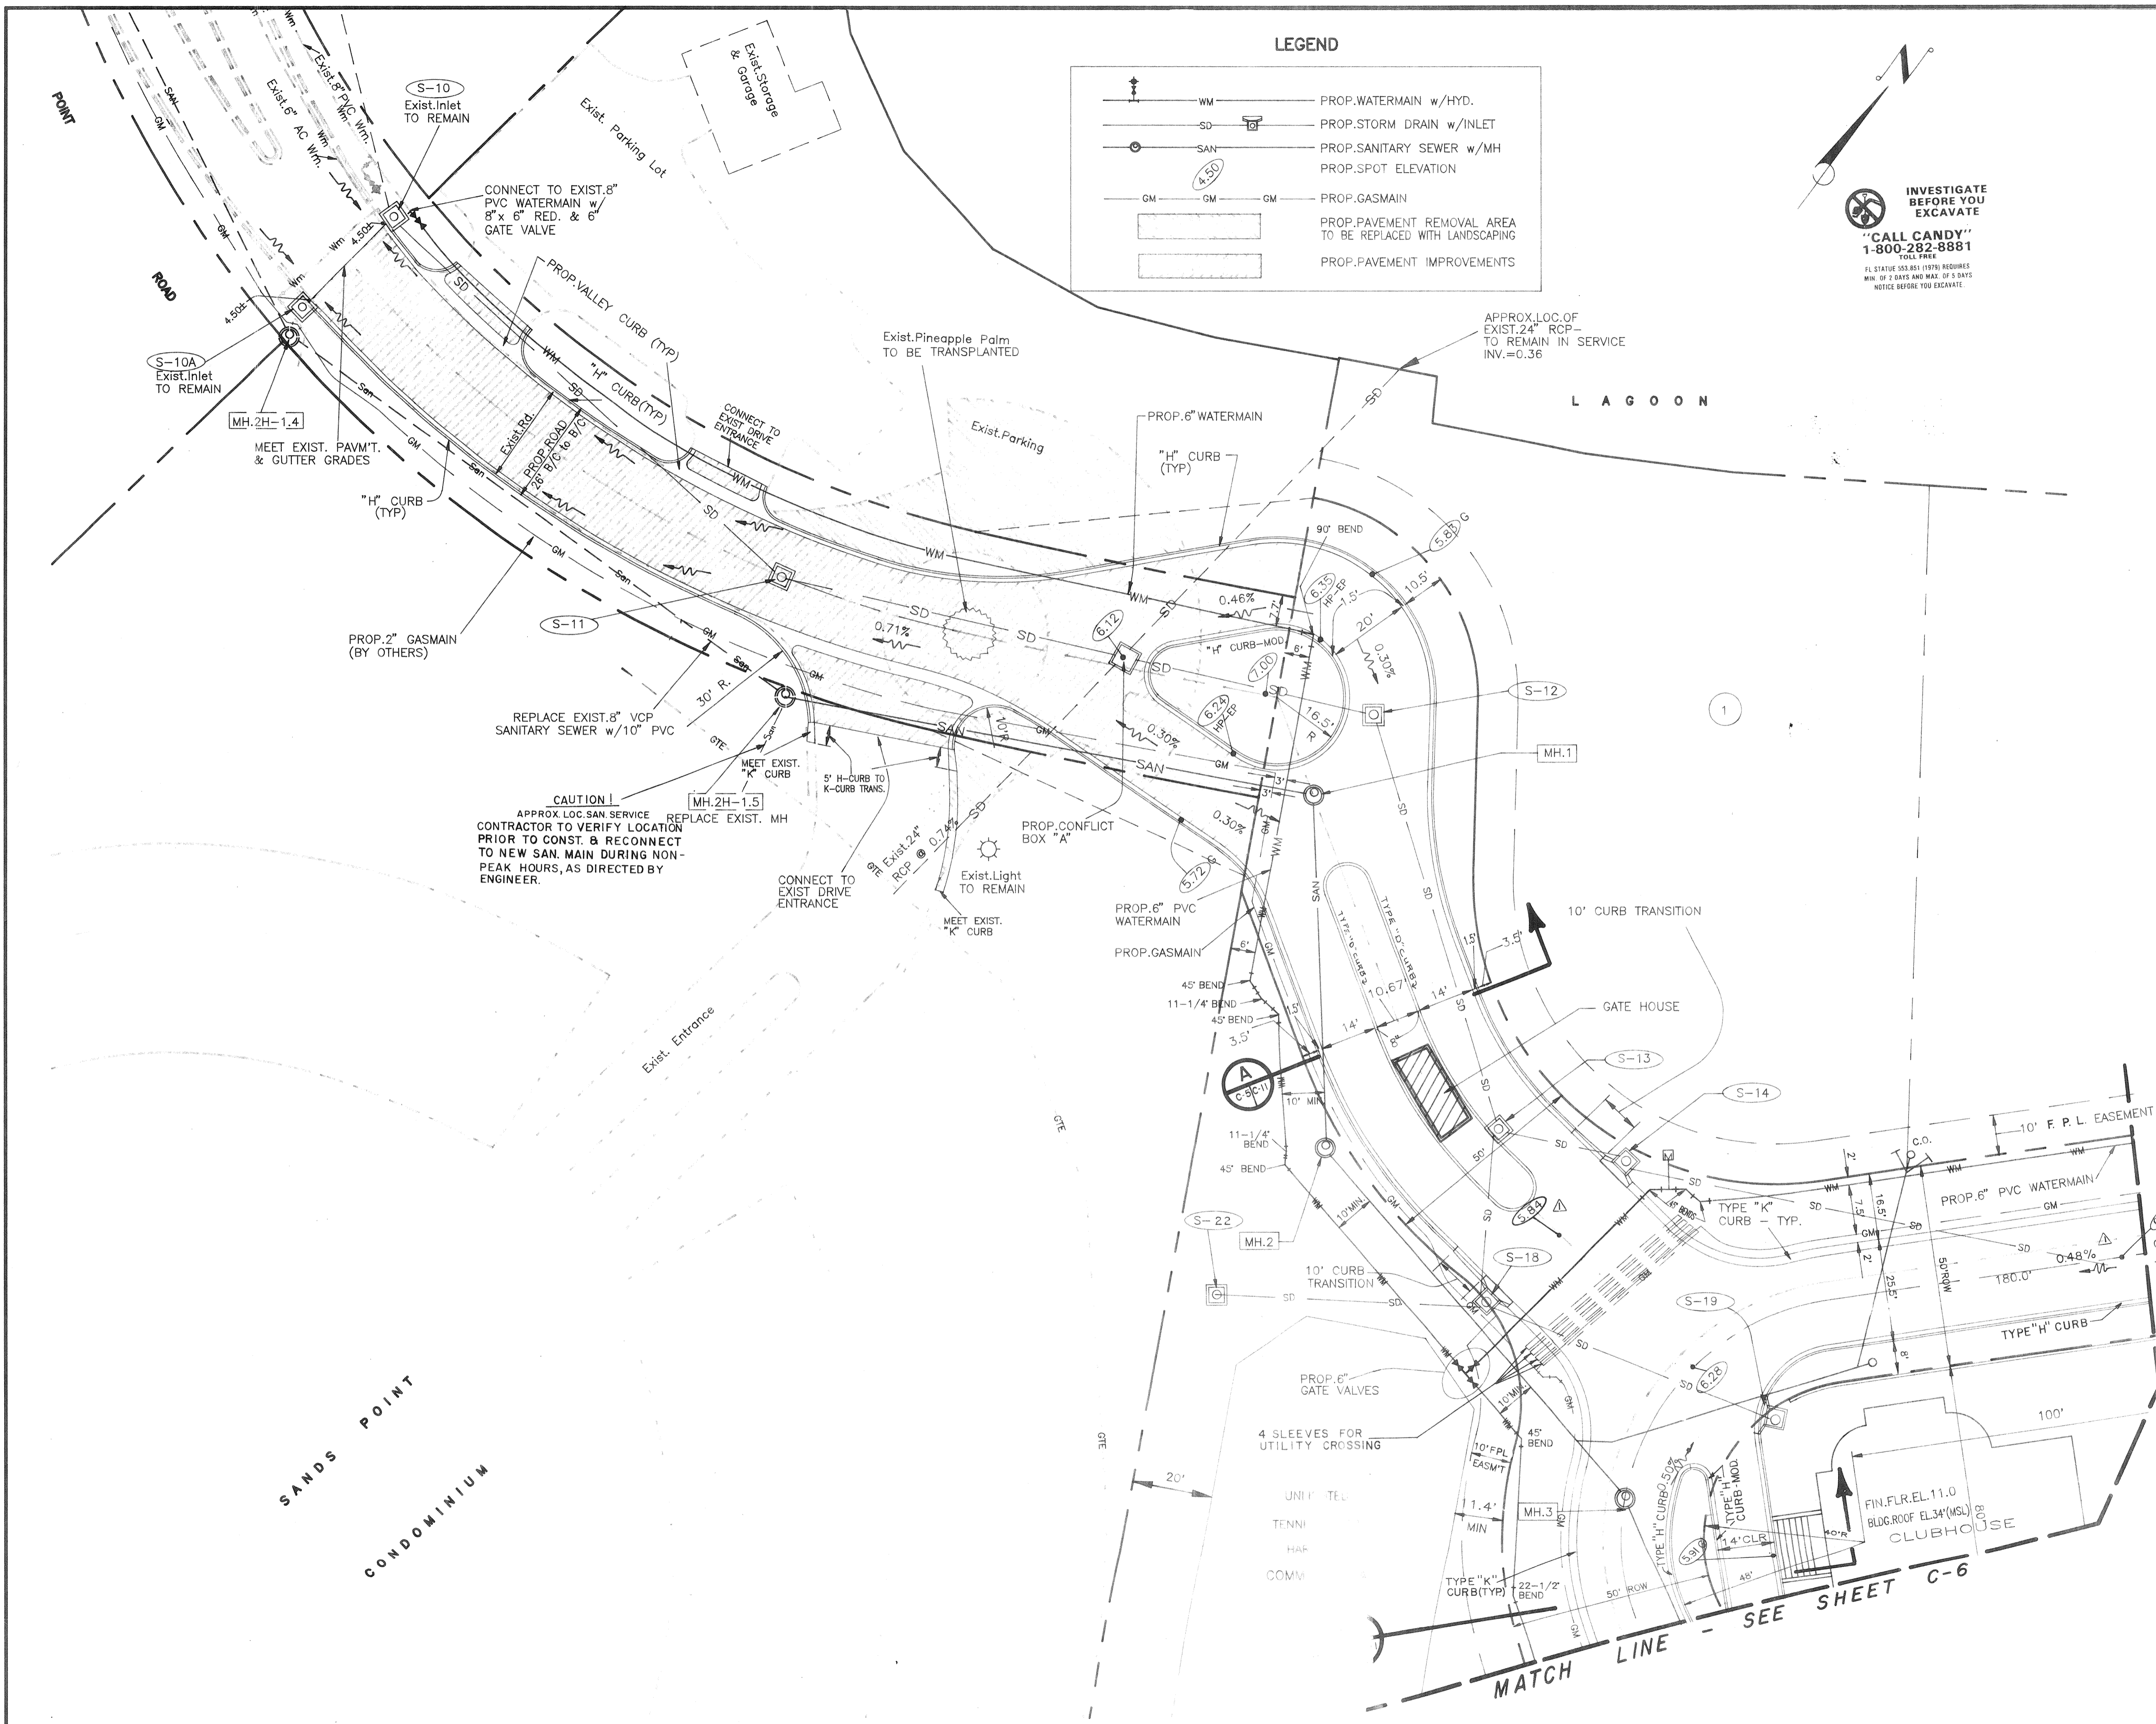

REV. DATE: _____
 DATE: _____ SCALE: _____
 CLIENT/TITLE: _____
 PROJECT NO.: _____
 SHEET NO.: _____

BISHOP & ASSOCIATES
 Consulting Engineers • Surveyors
 78 SARASOTA CENTER BLVD., SARASOTA, FLORIDA 34240
 813/371-6362 • Fax 813/378-3215

REVISED	BY	DATE	DESCRIPTION

R.W.C. 7-12-89

DATE: 7-10-89
 SCALE: 1" = 20'
 DESIGN: S.R.
 DRAWN: R.W.C.
 CHECKED: _____
 APPROVED: _____

CLIENT/TITLE: **LIGHTHOUSE POINT**
LHP PARTNERSHIP LIMITED
UTILITY PLAN

CONSTRUCTION PLAN
 LVDC-001
 C-6