


STORM SEWER SCHEDULE

STR. NO.	TYPE	RIM EL.	INV IN	INV OUT	FROM - TO	LENGTH	SIZE AND TYPE	GRADE
S-10	EX. CURB IN.	4.84	0.22	0.22	S-10 S-11	130 LF	30" RCP	0.002
S-11	JUNCT. BOX	5.50	0.22	0.22	S-11 S-12	152 LF	30" RCP	0.002
S-12	JUNCT. BOX	6.07	0.22	0.22	S-12 S-13	107 LF	30" RCP	0.002
S-13	JUNCT. BOX	5.78	0.22	0.22	S-13 S-14	33 LF	30" RCP	0.002
S-14	CURB INLET	5.57	0.22	0.22	S-14 S-15	236 LF	30" RCP	0.002
S-15	CURB INLET	6.11	0.47	0.22	S-15 S-16	39 LF	18" RCP	0.392
S-16	CURB INLET	6.18	0.62	0.62	S-16 S-17	38 LF	18" RCP	0.202
S-17	CURB INLET	6.11		0.70				
S-15	CURB INLET	6.11	0.22	0.22	S-15 S-20	144 LF	24" RCP	0.002
S-20	CURB INLET	6.42	0.22	0.22	S-20 S-21	33 LF	18" RCP	0.002
S-21	CURB INLET	6.42		0.22				
S-13	CURB INLET	5.78	0.35	0.22	S-13 S-18	43 LF	18" RCP	0.392
S-18	CURB INLET	5.57	0.52	0.52	S-18 S-19	77 LF	15" RCP	0.232
S-19	CURB INLET	6.07		0.69				
S-18	CURB INLET	5.57	0.52	0.52	S-18 S-22	67 LF	12" PVC	0.452
S-22	YARD DRAIN	5.70		0.82				



SANITARY SEWER SCHEDULE

STR. NO.	TYPE	RIM EL.	INV IN	INV OUT	FROM - TO	LENGTH	SIZE AND TYPE	GRADE
ZH 1.4	EXIST M.H.	4.48	- 0.99	- 0.99	2H 1.4-2H 1.5	156 LF	10" PVC	0.282
ZH 1.5	MANHOLE	5.69	- 0.55	- 0.55	2H 1.5 - 1	133 LF	8" PVC	0.402
1	MANHOLE	6.24	- 0.02	- 0.02	1 - 2	86 LF	8" PVC	0.402
2	MANHOLE	5.90	0.33	0.33	2 - 3	114 LF	8" PVC	0.402
3	MANHOLE	6.46	0.79	0.79	3 - 4	66 LF	8" PVC	0.402
4	MANHOLE	6.82	1.05	1.05	4 - 5	96 LF	8" PVC	0.402
5	MANHOLE	6.89	1.43	1.43	5 - 6	75 LF	8" PVC	0.402
6	MANHOLE	6.62	2.54	1.73	6 - 7	62 LF	8" DIP	0.402
7	MANHOLE	6.31	2.79	2.79	7 - 8	329 LF	8" DIP	0.402
8	MANHOLE	6.86		4.11				

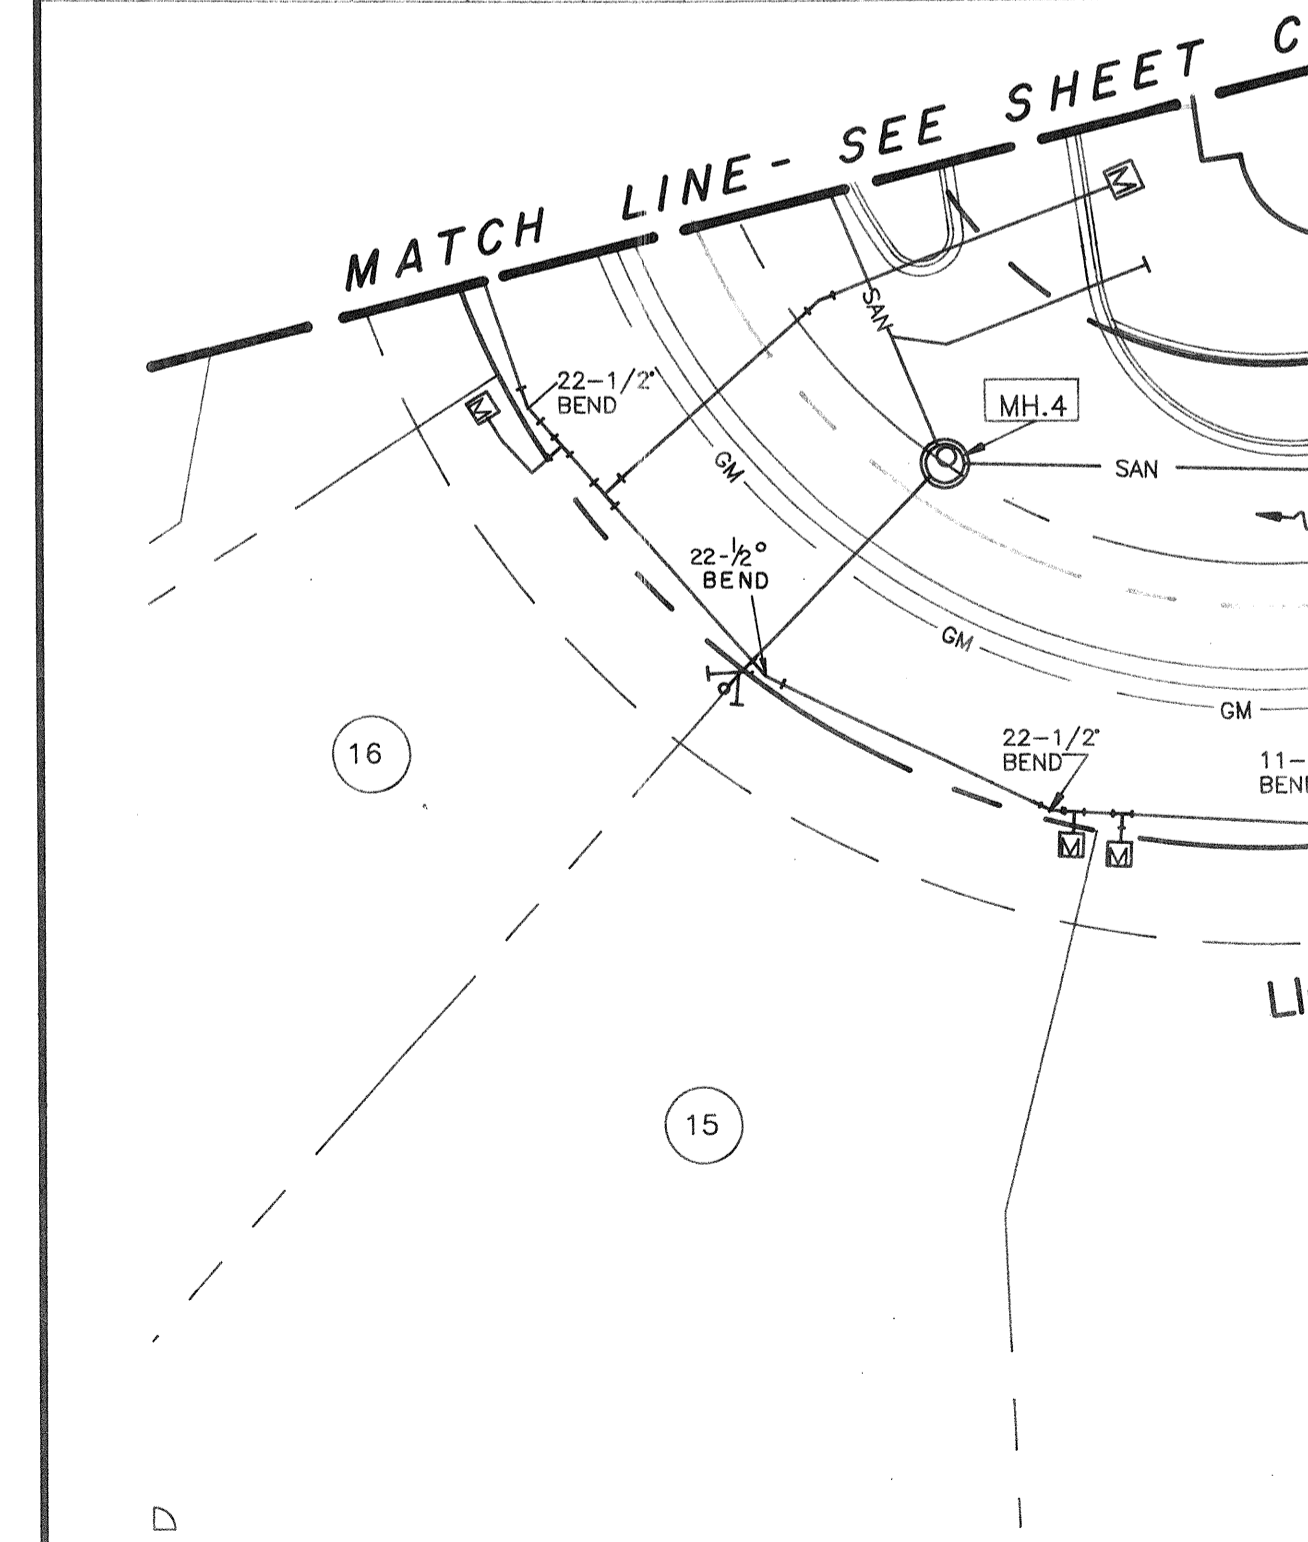

LEGEND

- WM - PROP. WATERMAIN w/HYD.
- SD - PROP. STORM DRAIN w/INLET
- SAN - PROP. SANITARY SEWER w/MH
- GM - PROP. SPOT ELEVATION
- GM - PROP. GASMAIN

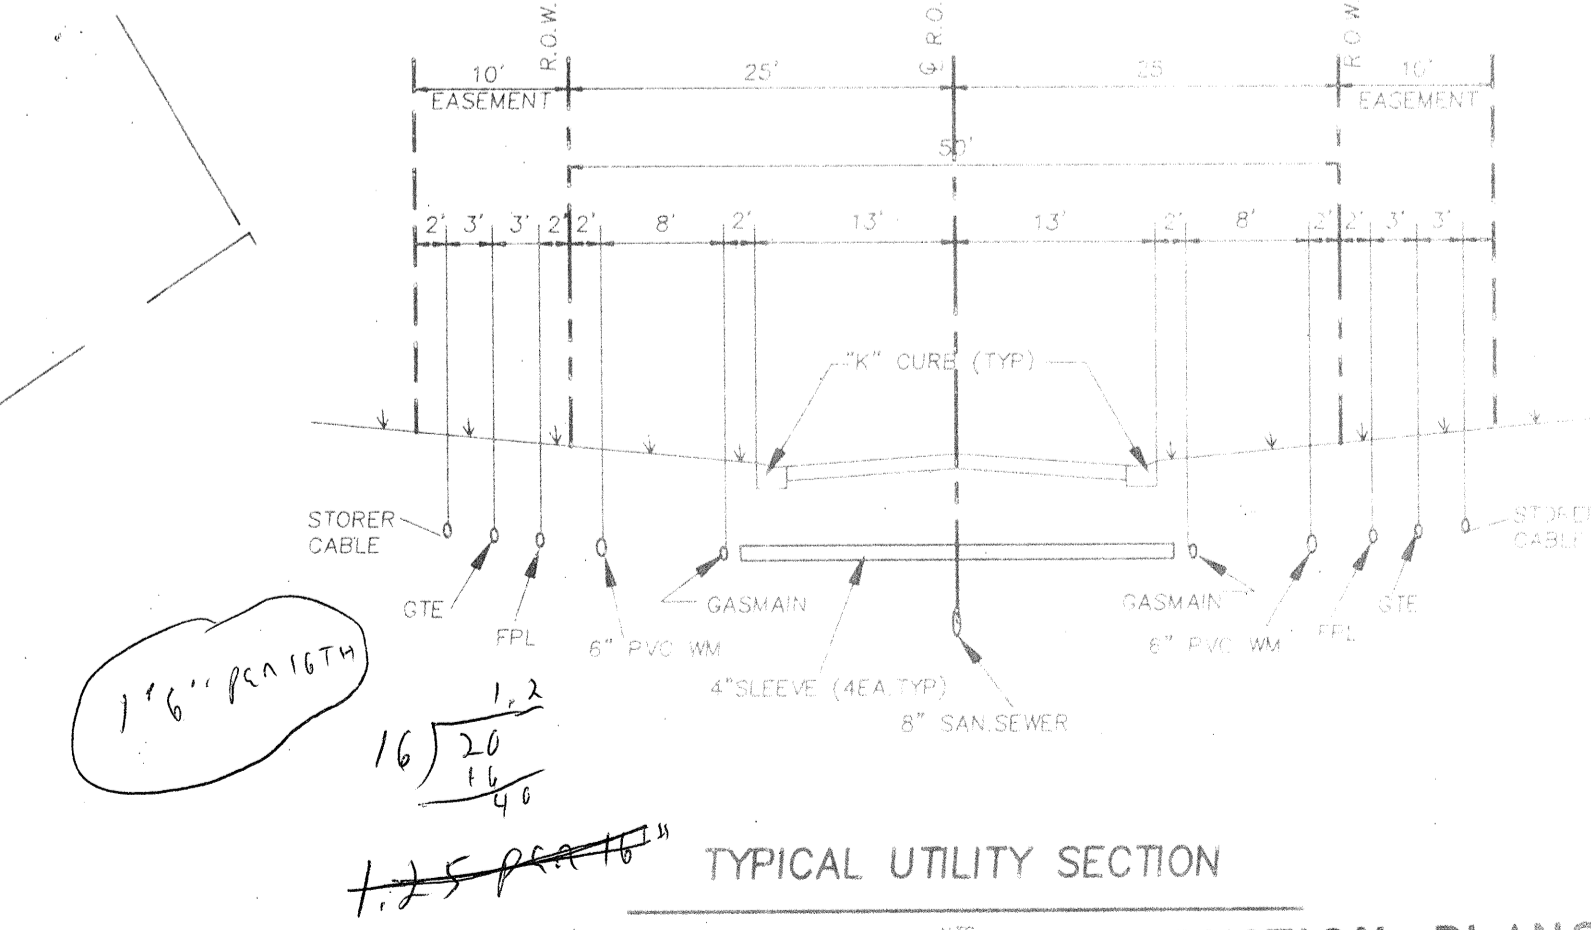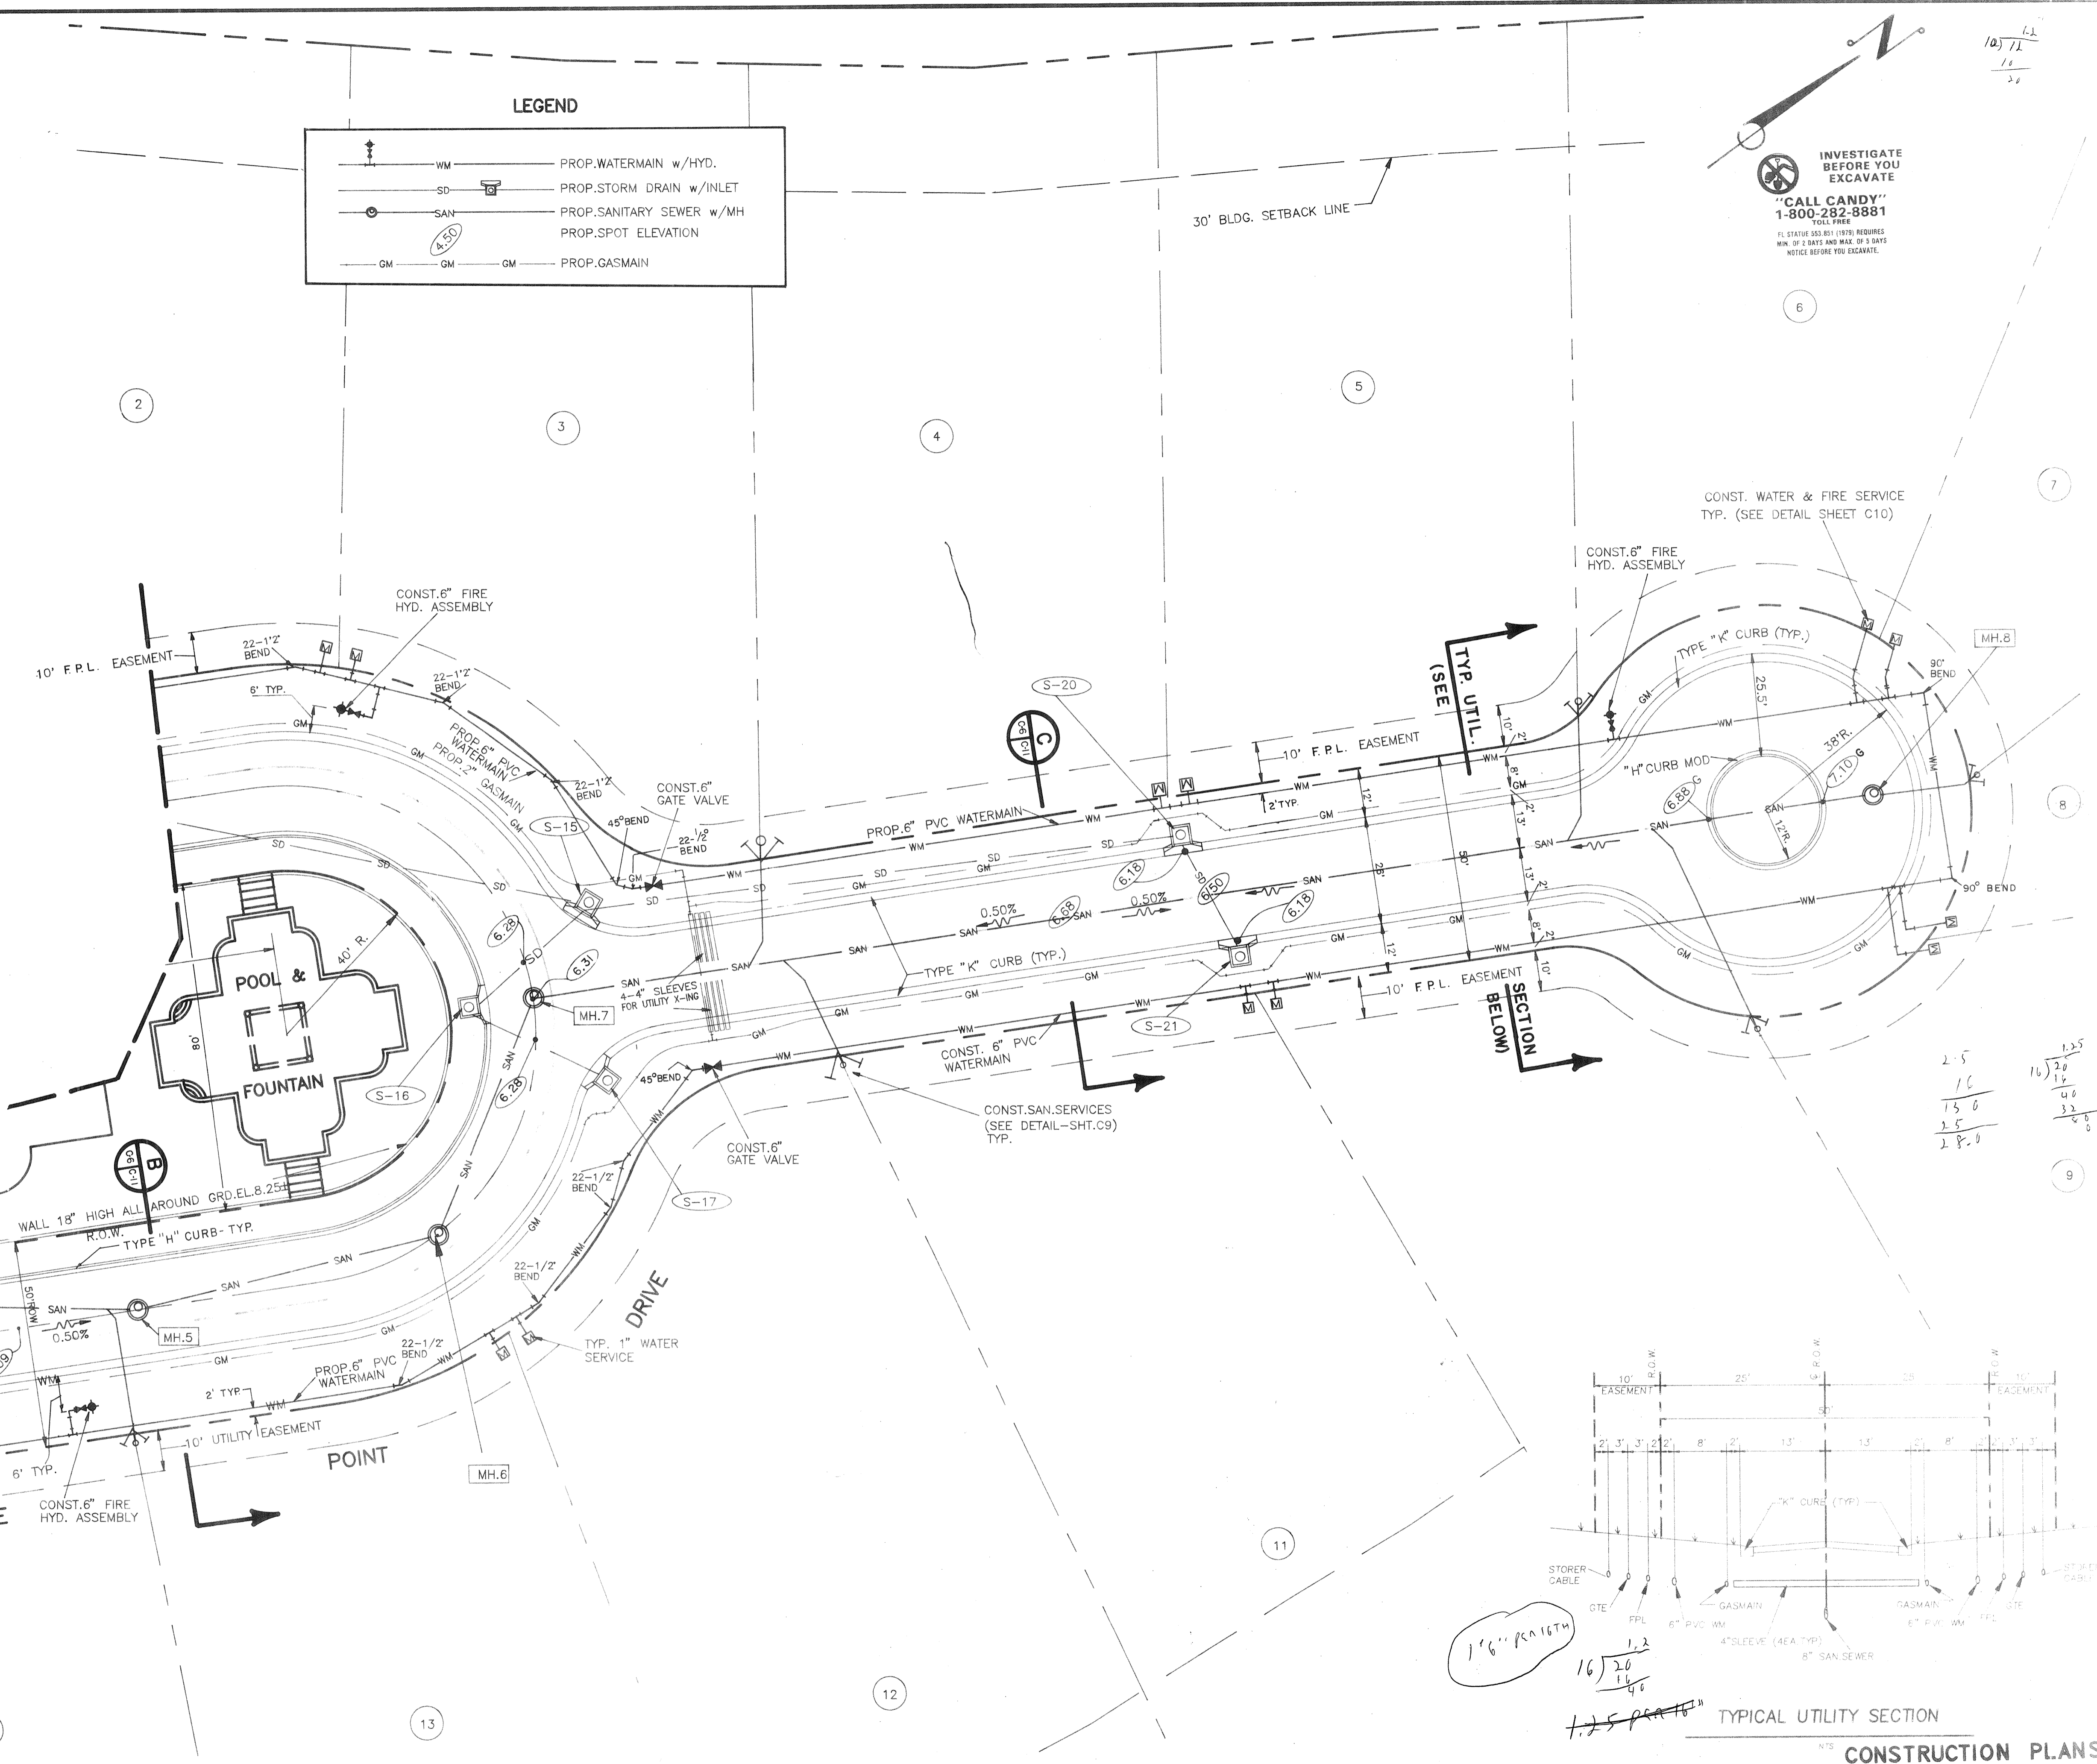

CLIENT/TITLE: PROJECT NO: SHEET NO: REV. DATE: SCALE:

BISHOP & ASSOCIATES
 Consulting Engineers • Surveyors
 78 SARASOTA CENTER BLVD. SARASOTA, FLORIDA 34240
 813/371-6362 • Fax 813/378-3215

REVISED	BY	DATE	DESCRIPTION

DATE	7-10-89	PROJECT NO	LVDG-0015
SCALE	1" = 20'	SHEET NO.	C-6
DESIGN	S.R.		
DRAWN	R.W.C.		
CHECKED			
APPROVED			

CLIENT/TITLE: **LIGHTHOUSE POINT**
 LHP PARTNERSHIP LIMITED
 UTILITY PLAN