



INVESTIGATE BEFORE YOU EXCAVATE
 "CALL CANDY"
 1-800-282-8881
 TOLL FREE
 24 HOURS A DAY
 MIN. OF 2 DAYS AND MAX. OF 5 DAYS
 NOTICE BEFORE YOU EXCAVATE.

CLIENT/TITLE: _____
 PROJECT NO.: _____
 SHEET NO.: _____
 DATE: _____
 SCALE: _____
 REV. DATE: _____

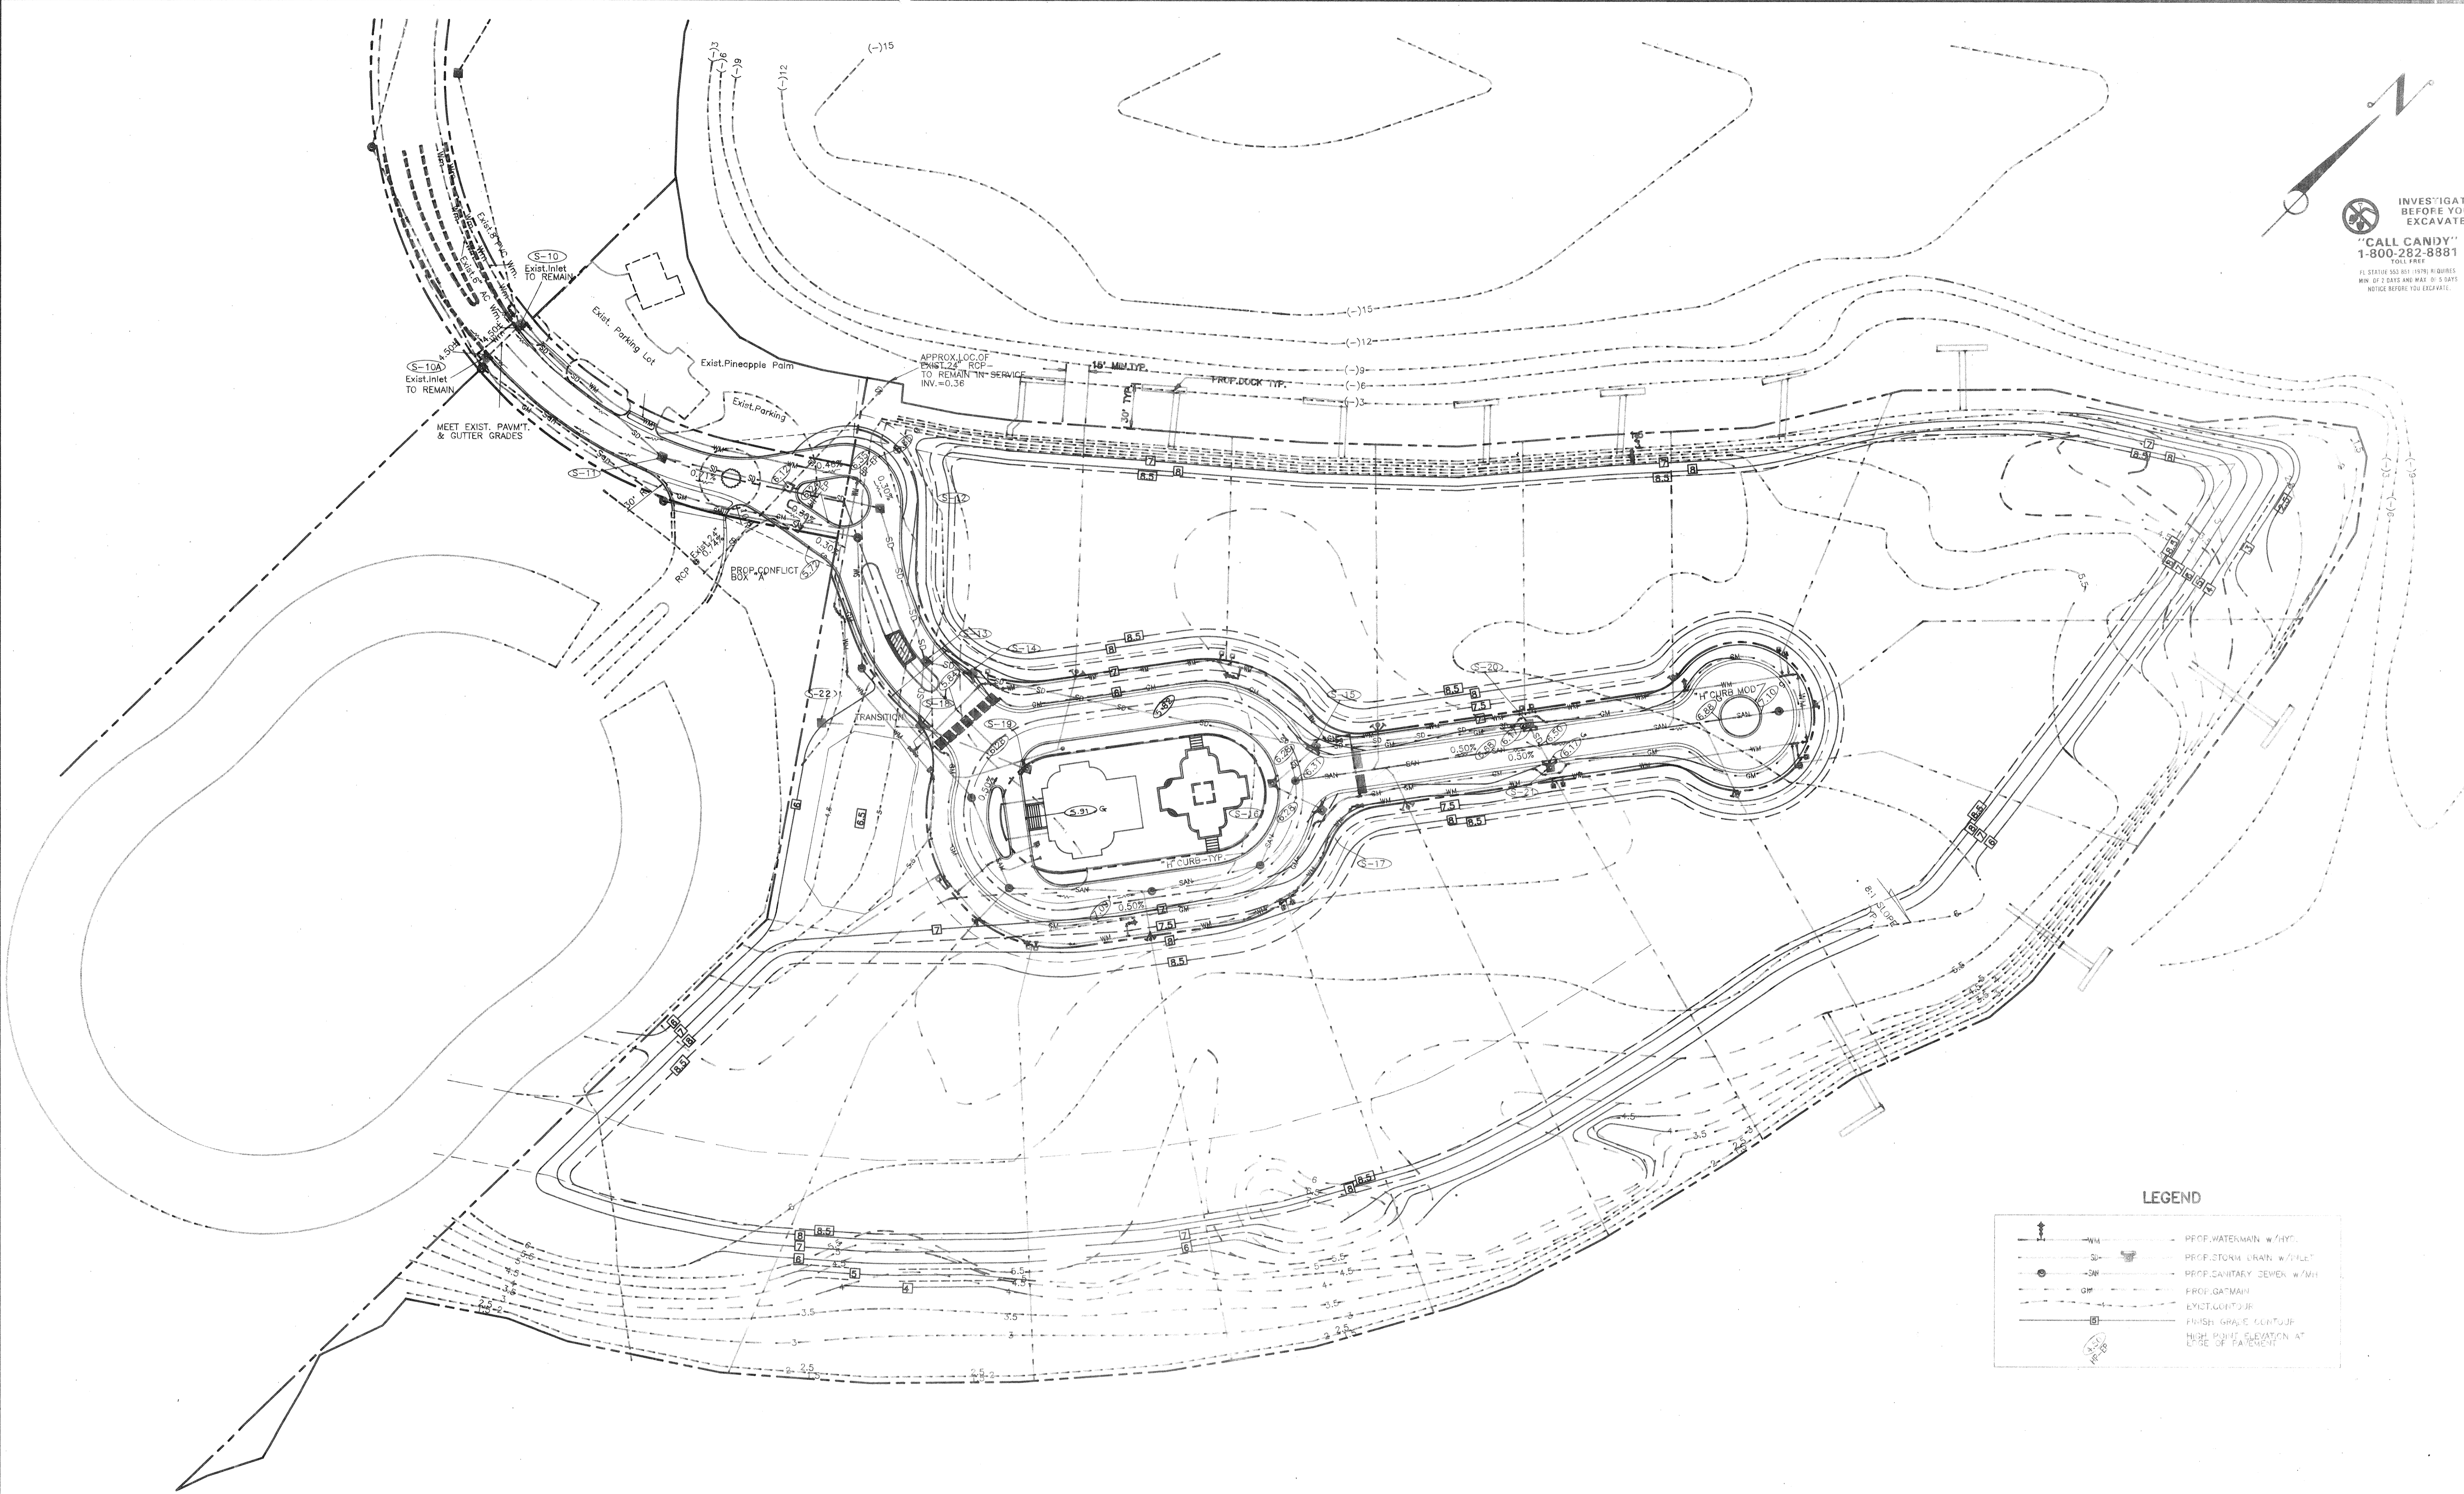

LEGEND

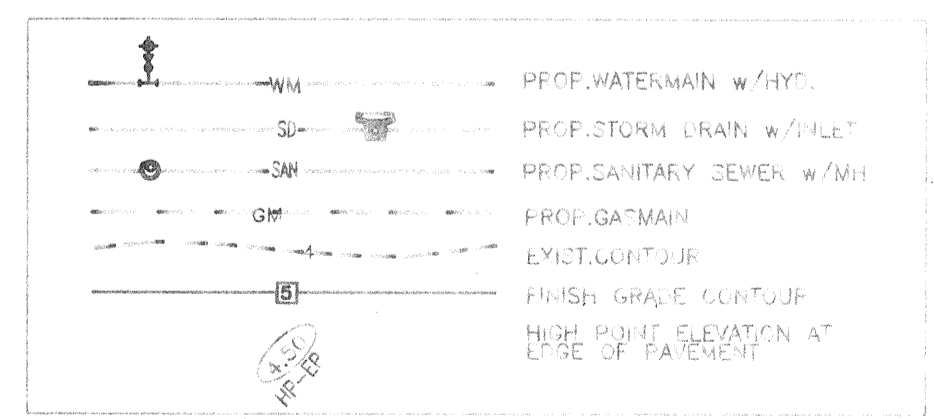

CONSTRUCTION PLANS

B BISHOP & ASSOCIATES
 Consulting Engineers • Surveyors
 78 SARASOTA CENTER BLVD., SARASOTA, FLORIDA 34240
 813/371-6362 • Fax 813/378-3215

REVISED	BY	DATE	DESCRIPTION

DATE: 7-10-89
 SCALE: 1" = 50'
 DESIGN: S.R.
 DRAWN: R.W.C.
 CHECKED: _____
 APPROVED: _____
 SEAL: _____
 APPROVED BY: _____

CLIENT/TITLE: Lighthouse Point
 LHP PARTNERSHIP LIMITED
 GRADING & DRAINAGE PLAN

PROJECT NO: LVDC-0015
 SHEET NO: C-7