


POOL DECK SHOWER AT STAIR  
LANDING: 4"x4" PRECAST CONCRETE  
POST IN 12"x12"x24" DP FOOTING W/  
"CHICAGO FAUCET" MODEL #20-B OR  
EQUAL SHOWERHEAD 6"8" ABOVE SLAB  
AND SELF-CLOSING "CHICAGO" VALVE #376-244  
OR EQUAL. HOSE BIBB 12" ABOVE  
SLAB, SHUT-OFF VALVE IN BOX.


SEE DETAIL IN ARCH. DWG  
NO. A-16 (TYP.)

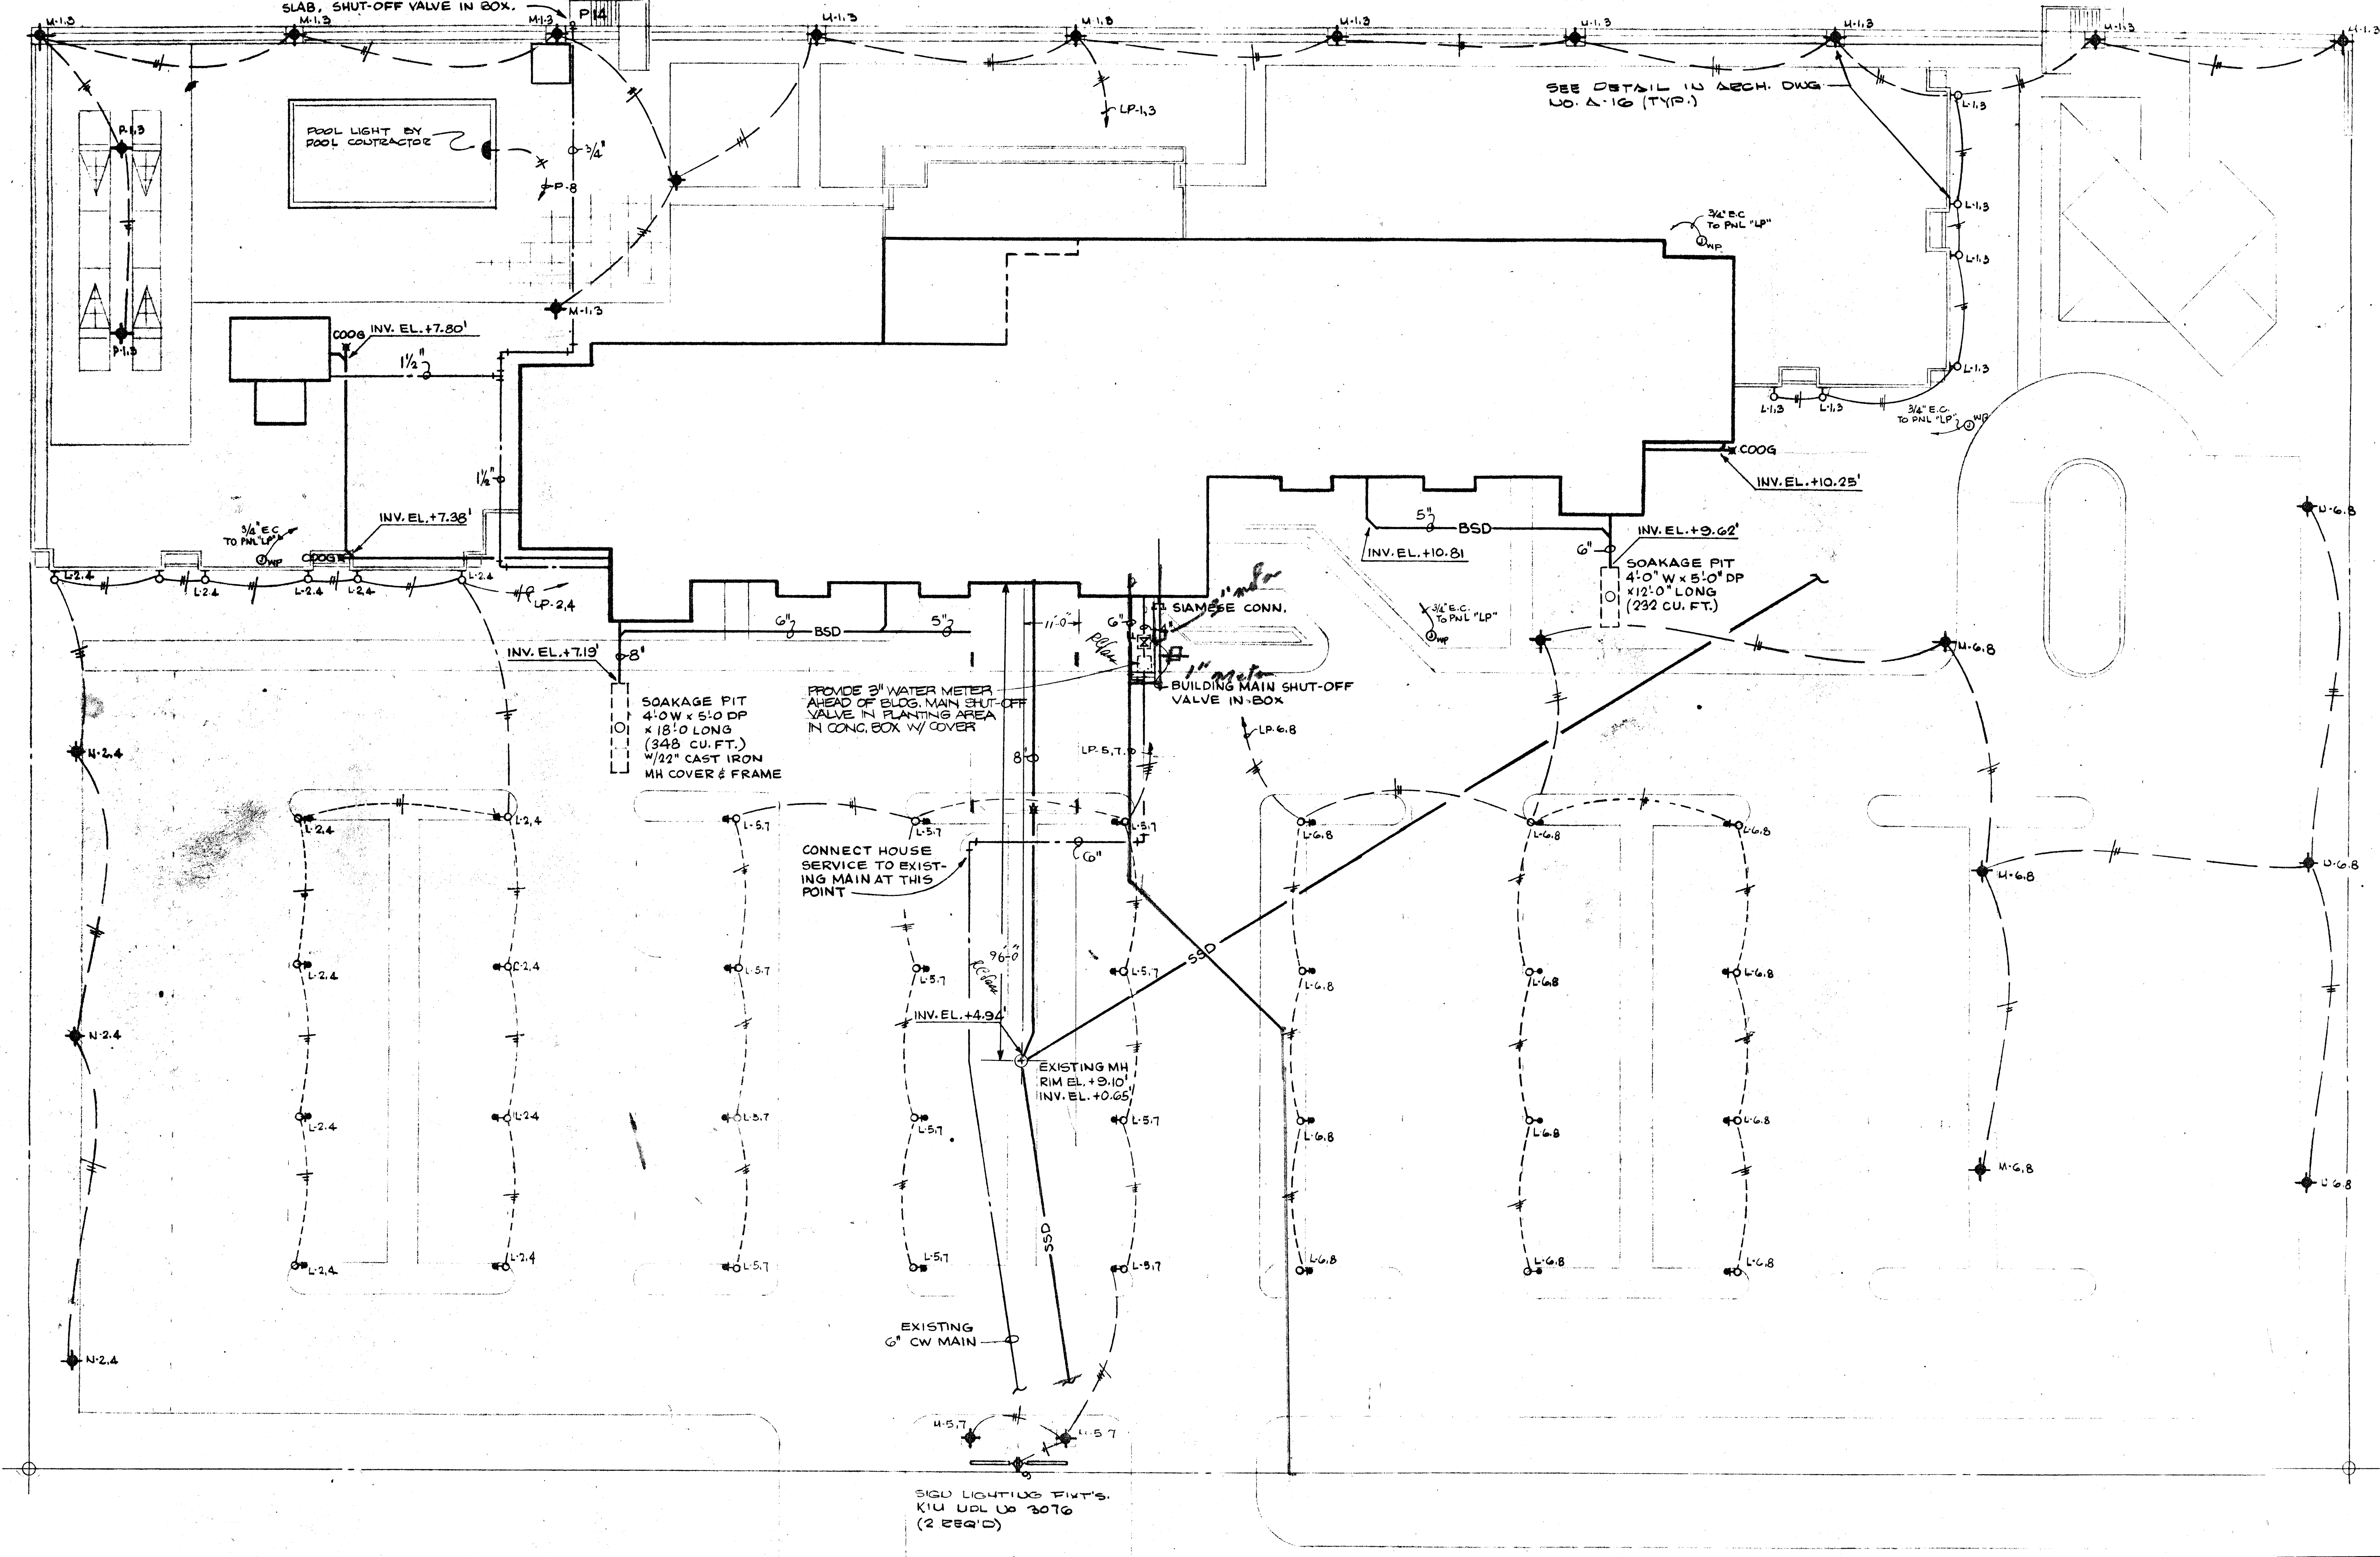

SITE PLAN  
1/16" = 1'-0"


1/16  
1/8  
1/4  
2/4

J. J. CLARET  
ARCHITECT  
4460 GULF OF MEXICO DRIVE  
SARASOTA FLORIDA 33677

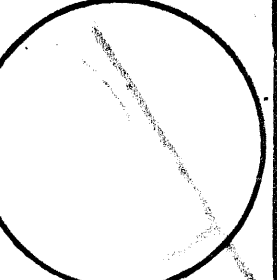


revisions  
no. 7105  
38-5-77 drawn: JJC

LONGBOAT HARBOUR TOWERS  
LONGBOAT KEY FLORIDA  
AN I. Z. MANN & ASSOCIATES PROJECT

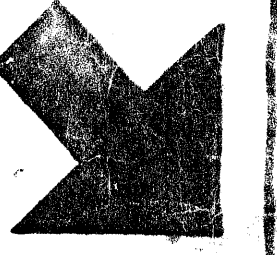

NORTH

SITE PLAN

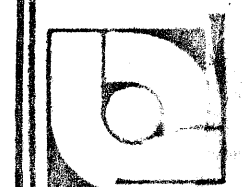

LOUIS J. AGUIRRE AND ASSOCIATES  
CONSULTING ENGINEERS  
805 N.W. 7th ST. MIAMI, FLA. - TEL. 643-9444

M-1  
OF 42 SHEETS