

INVESTIGATE BEFORE YOU EXCAVATE
"CALL CANDY"
 1-800-282-8881
 TOLL FREE
 FL. STATUTE 553.851 (1979) REQUIRES MIN. OF 2 DAYS AND MAX. OF 5 DAYS NOTICE BEFORE YOU EXCAVATE.

LEGEND

EXISTING UTILITIES

- SAN --- SANITARY SEWER
- FM --- FORCE MAIN
- SD --- STORM DRAIN
- WM --- WATER MAIN
- GAC --- GAS MAIN
- CATV --- BURIED CABLE TV
- BE --- BURIED ELECTRIC
- BT --- BURIED TELEPHONE



PROPOSED UTILITIES

- SAN --- SANITARY SEWER
- SD --- STORM DRAIN
- WM --- WATER MAIN
- FM --- FIRE MAIN
- S-21 --- PROP. STORM SEWER STRUCTURE
- MH.No.2 --- PROP. SANITARY SEWER MANHOLE
- L.C. --- LIMITS OF CONSTRUCTION


ALSO NOTIFY:

FP&L 953-7265
 TOWN OF LONGBOAT KEY 383-3721

NOTE: ALL UTILITY SLEEVES ARE TO BE CONSTRUCTED 5' BEHIND THE PROPOSED CURB UNLESS NOTED OTHERWISE.

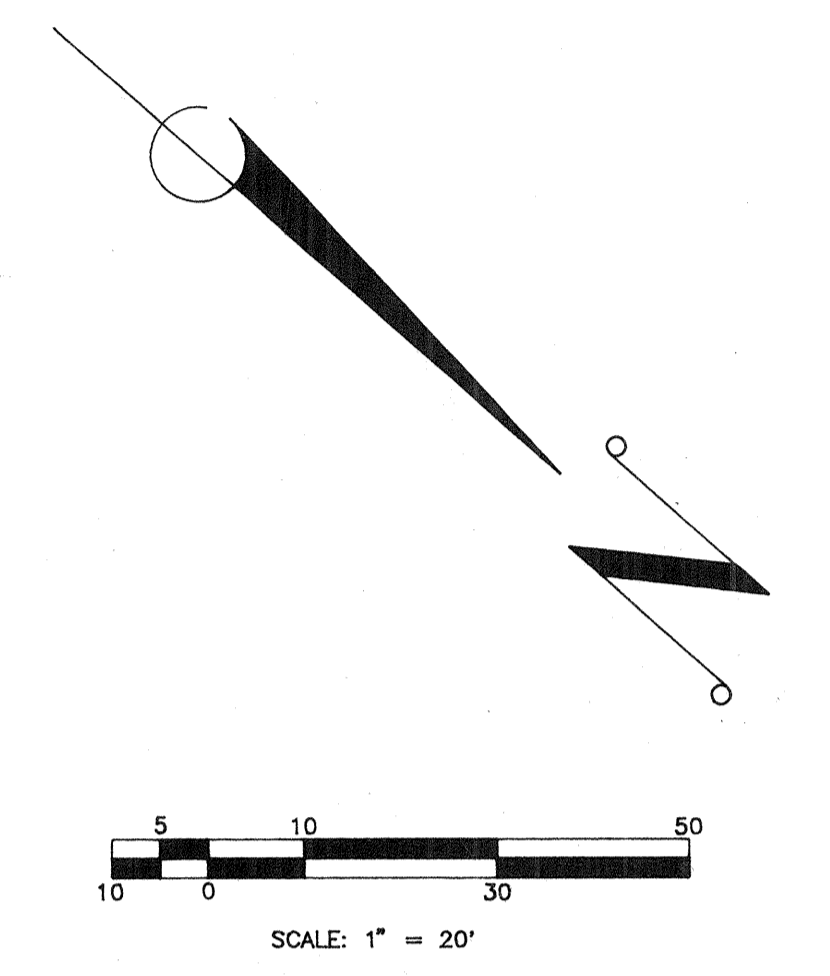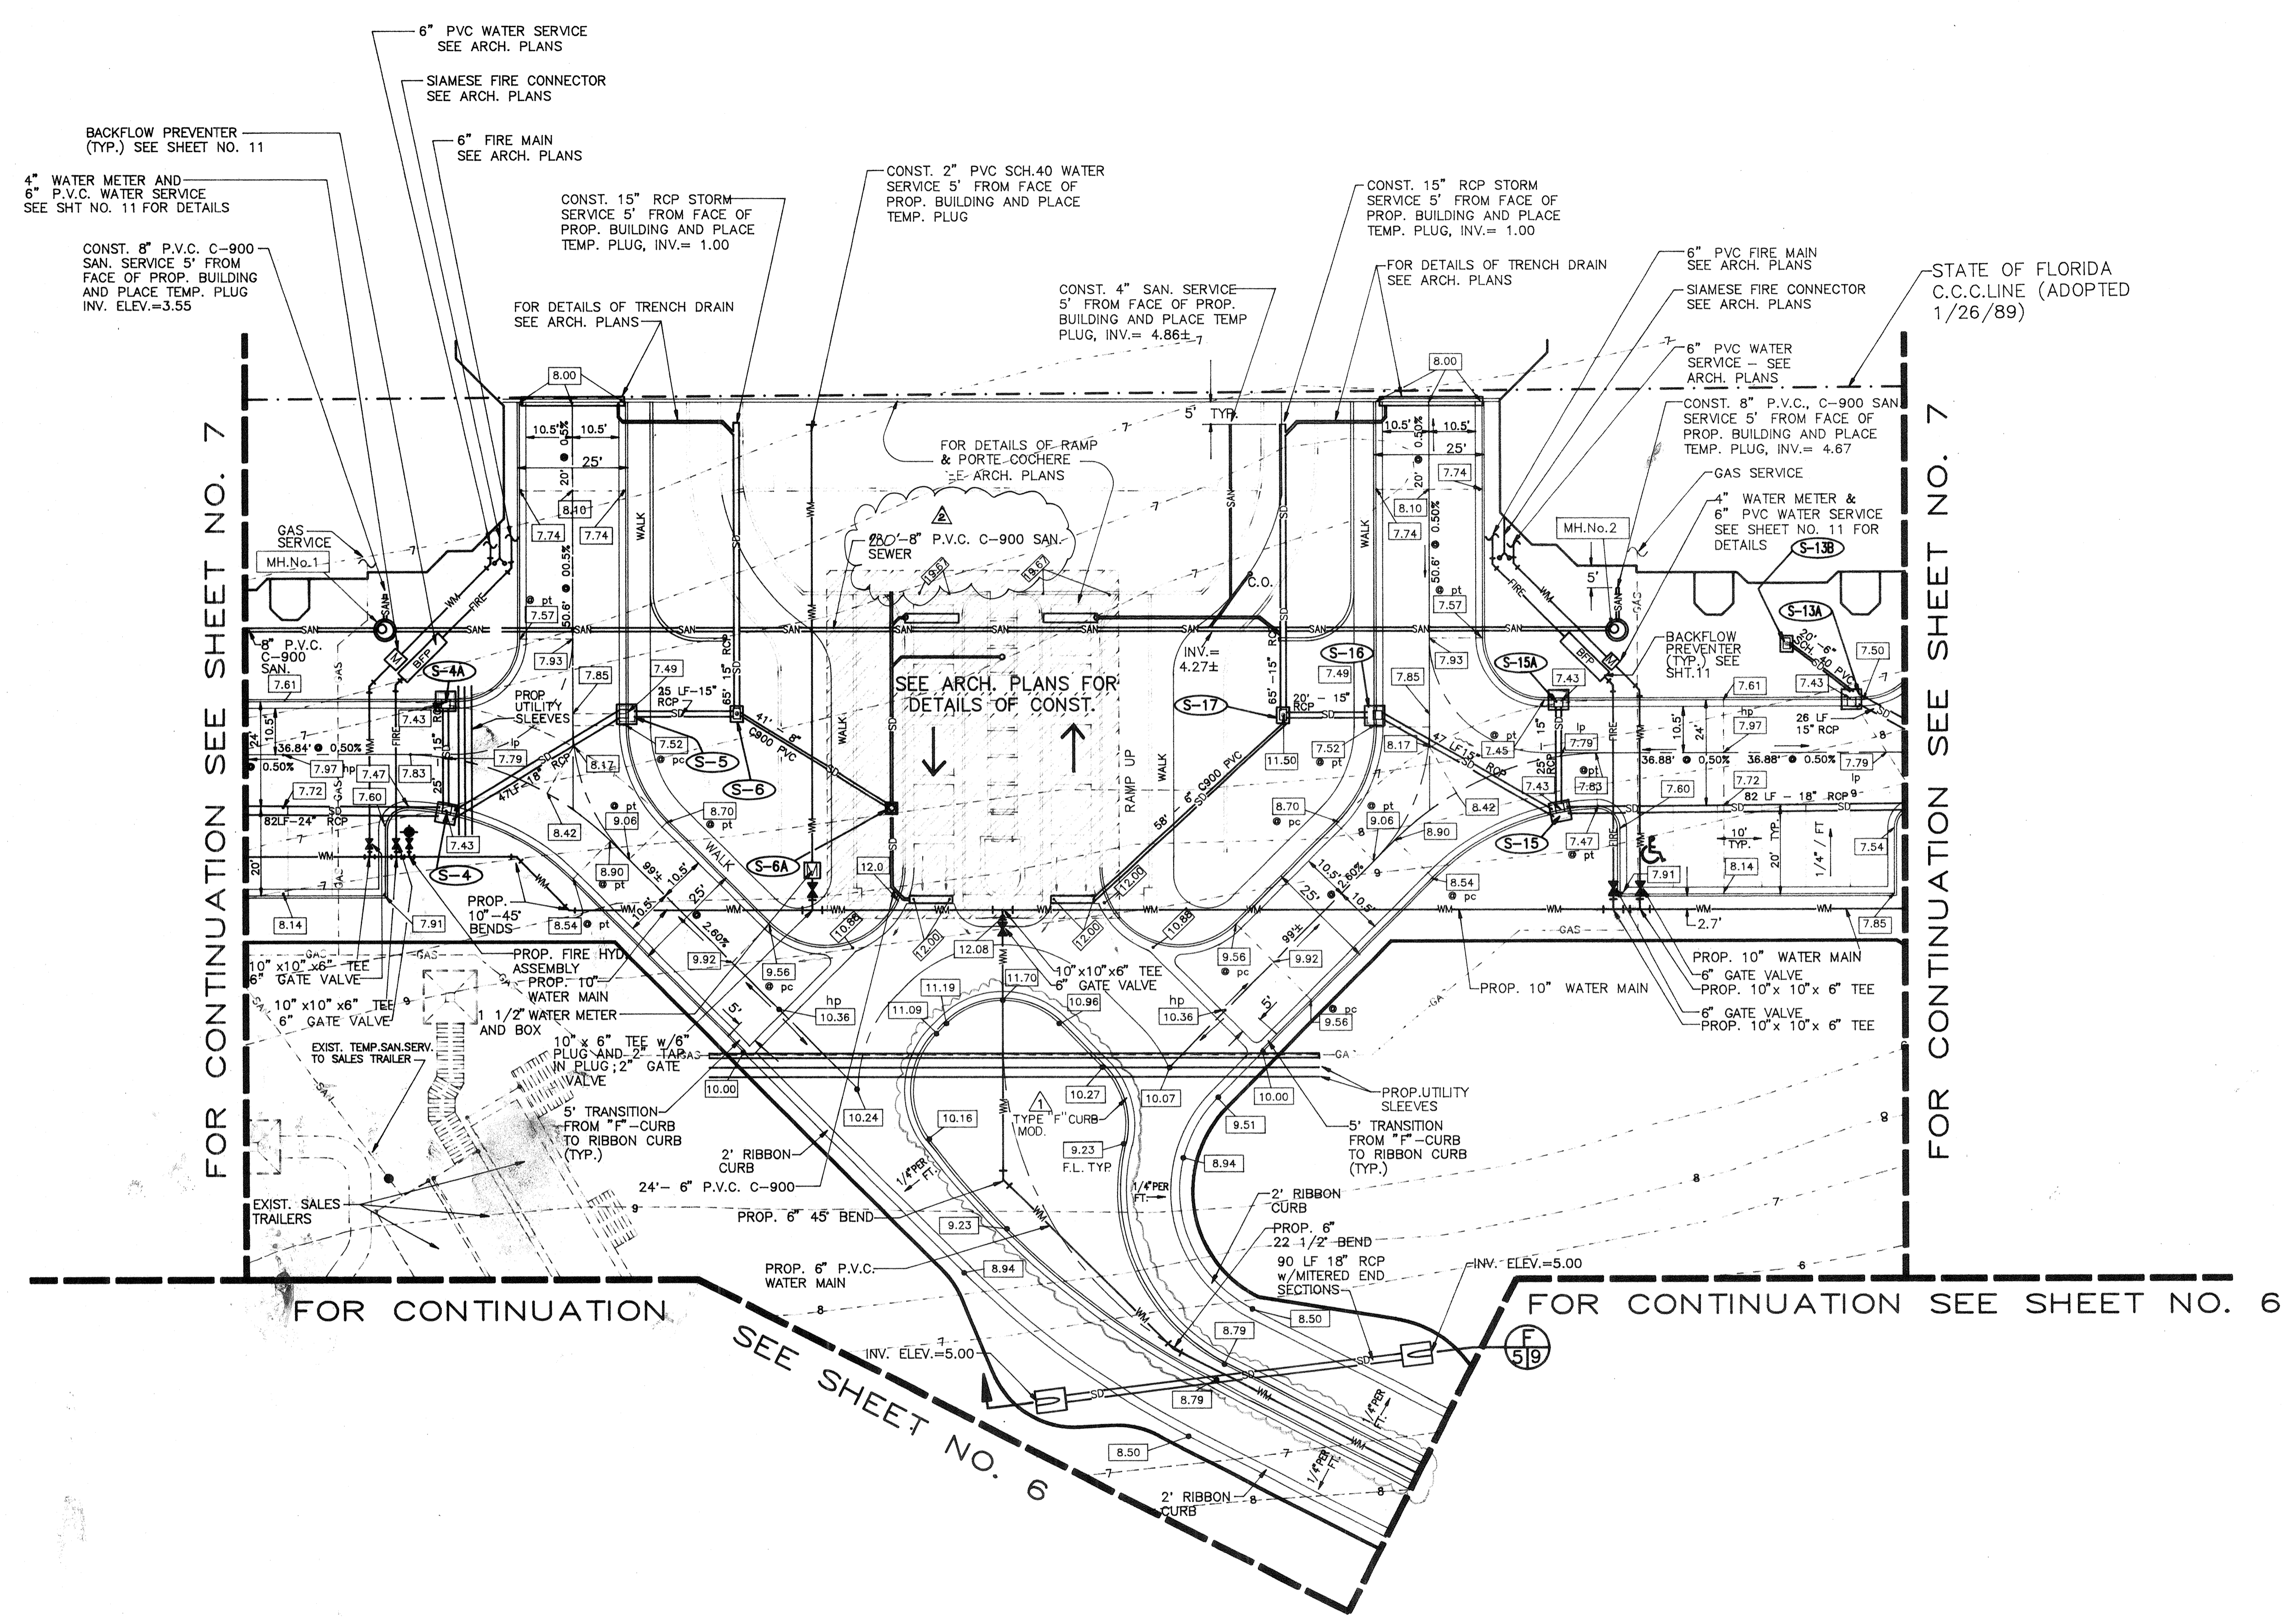

- GENERAL NOTES:**
1. FOR DETAILS OF SAN. SEWER & STORM DRAIN PROFILE SEE SHT. 8
 2. FOR DETAILS OF STORM DRAIN CONSTRUCTION SEE SHT. 9 & 10.
 3. FOR DETAILS OF WATERMAIN CONSTRUCTION SEE SHT. 11.
 4. FOR DETAILS OF SANITARY SEWER CONSTRUCTION SEE SHT. 12.

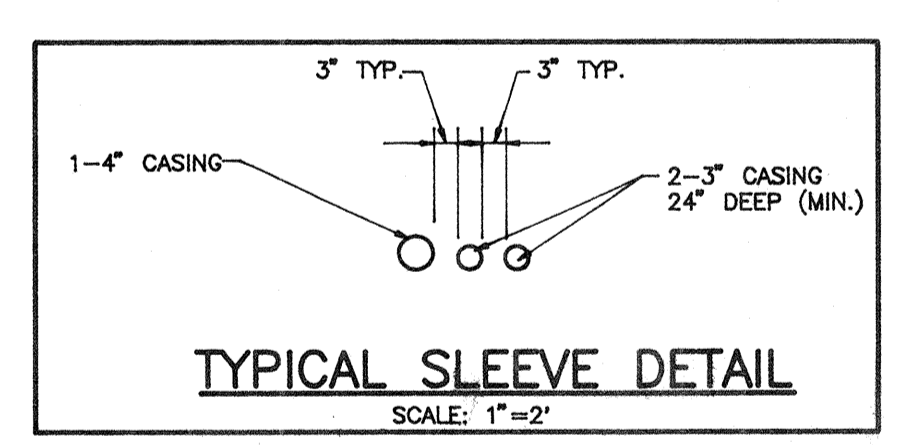

FIELD BOOK NO. _____
 PAGE _____
 Sec. - Typ. - Rng. _____

PLOT DATE: _____
 CAD FILE: _____
 P. Or. X. _____

BISHOP & ASSOCIATES
 Consulting Engineers • Surveyors
 AN EMPLOYEE OWNED COMPANY
 78 SARASOTA CENTER BLVD., SARASOTA, FLORIDA 34240
 813/371-6362 • Fax 813/378-3215

REVISED	BY	DATE	Q.C.	DATE	DESCRIPTION

REVISION	DATE	Q.C.	DATE	DESCRIPTION
1	10-8-93		10-8-93	REV CURB TYPE FROM RIBBON TO "MOD"
2	10-11-93		10-11-93	ERROR CORRECTION

TASK	INITIALS	DATE
DESIGN	P.C.P.	4-19-93
DRAWN	P.S.N.	4-28-93
CHECKED	W.F.B.	
QUALITY CHK.		
HORIZ. SCALE		
VERT. SCALE		

CLIENT/TITLE

THE ST. JAMES
 ST. JAMES DEVELOPMENT COMPANY SOUTH, INC
 DETAIL DRAINAGE AND UTILITY PLAN

PROJECT NO. ANS-10
 SHEET NO. 5