

MATCH LINE - SEE SHEET NO. 6

MATCH LINE - SEE SHEET NO. 6

THE PLAYERS CLUB


**BISHOP & ASSOCIATES**  
Consulting Engineers - Surveyors  
AN EMPLOYEE OWNED COMPANY  
78 SARASOTA CENTER BLVD. SARASOTA, FLORIDA 34240  
813/371-6362 • Fax 813/378-3215

REVISED	DATE	Q.C.	DATE	DESCRIPTION	BY	DATE	Q.C.	DATE	DESCRIPTION

TASK	INITIALS	DATE
DESIGN	P.O.P.	4-19-93
DRAWN	P.S.N.	4-28-93
CHECKED	W.F.B.	
QUALITY CHK		
WORK SCALE		
VERT. SCALE		

CLIENT/TITLE  
**THE ST. JAMES**  
ST. JAMES DEVELOPMENT COMPANY SOUTH, INC  
DETAIL DRAINAGE AND UTILITY PLAN

PROJECT NO.  
**ANS-10**  
SHEET NO.  
**7**

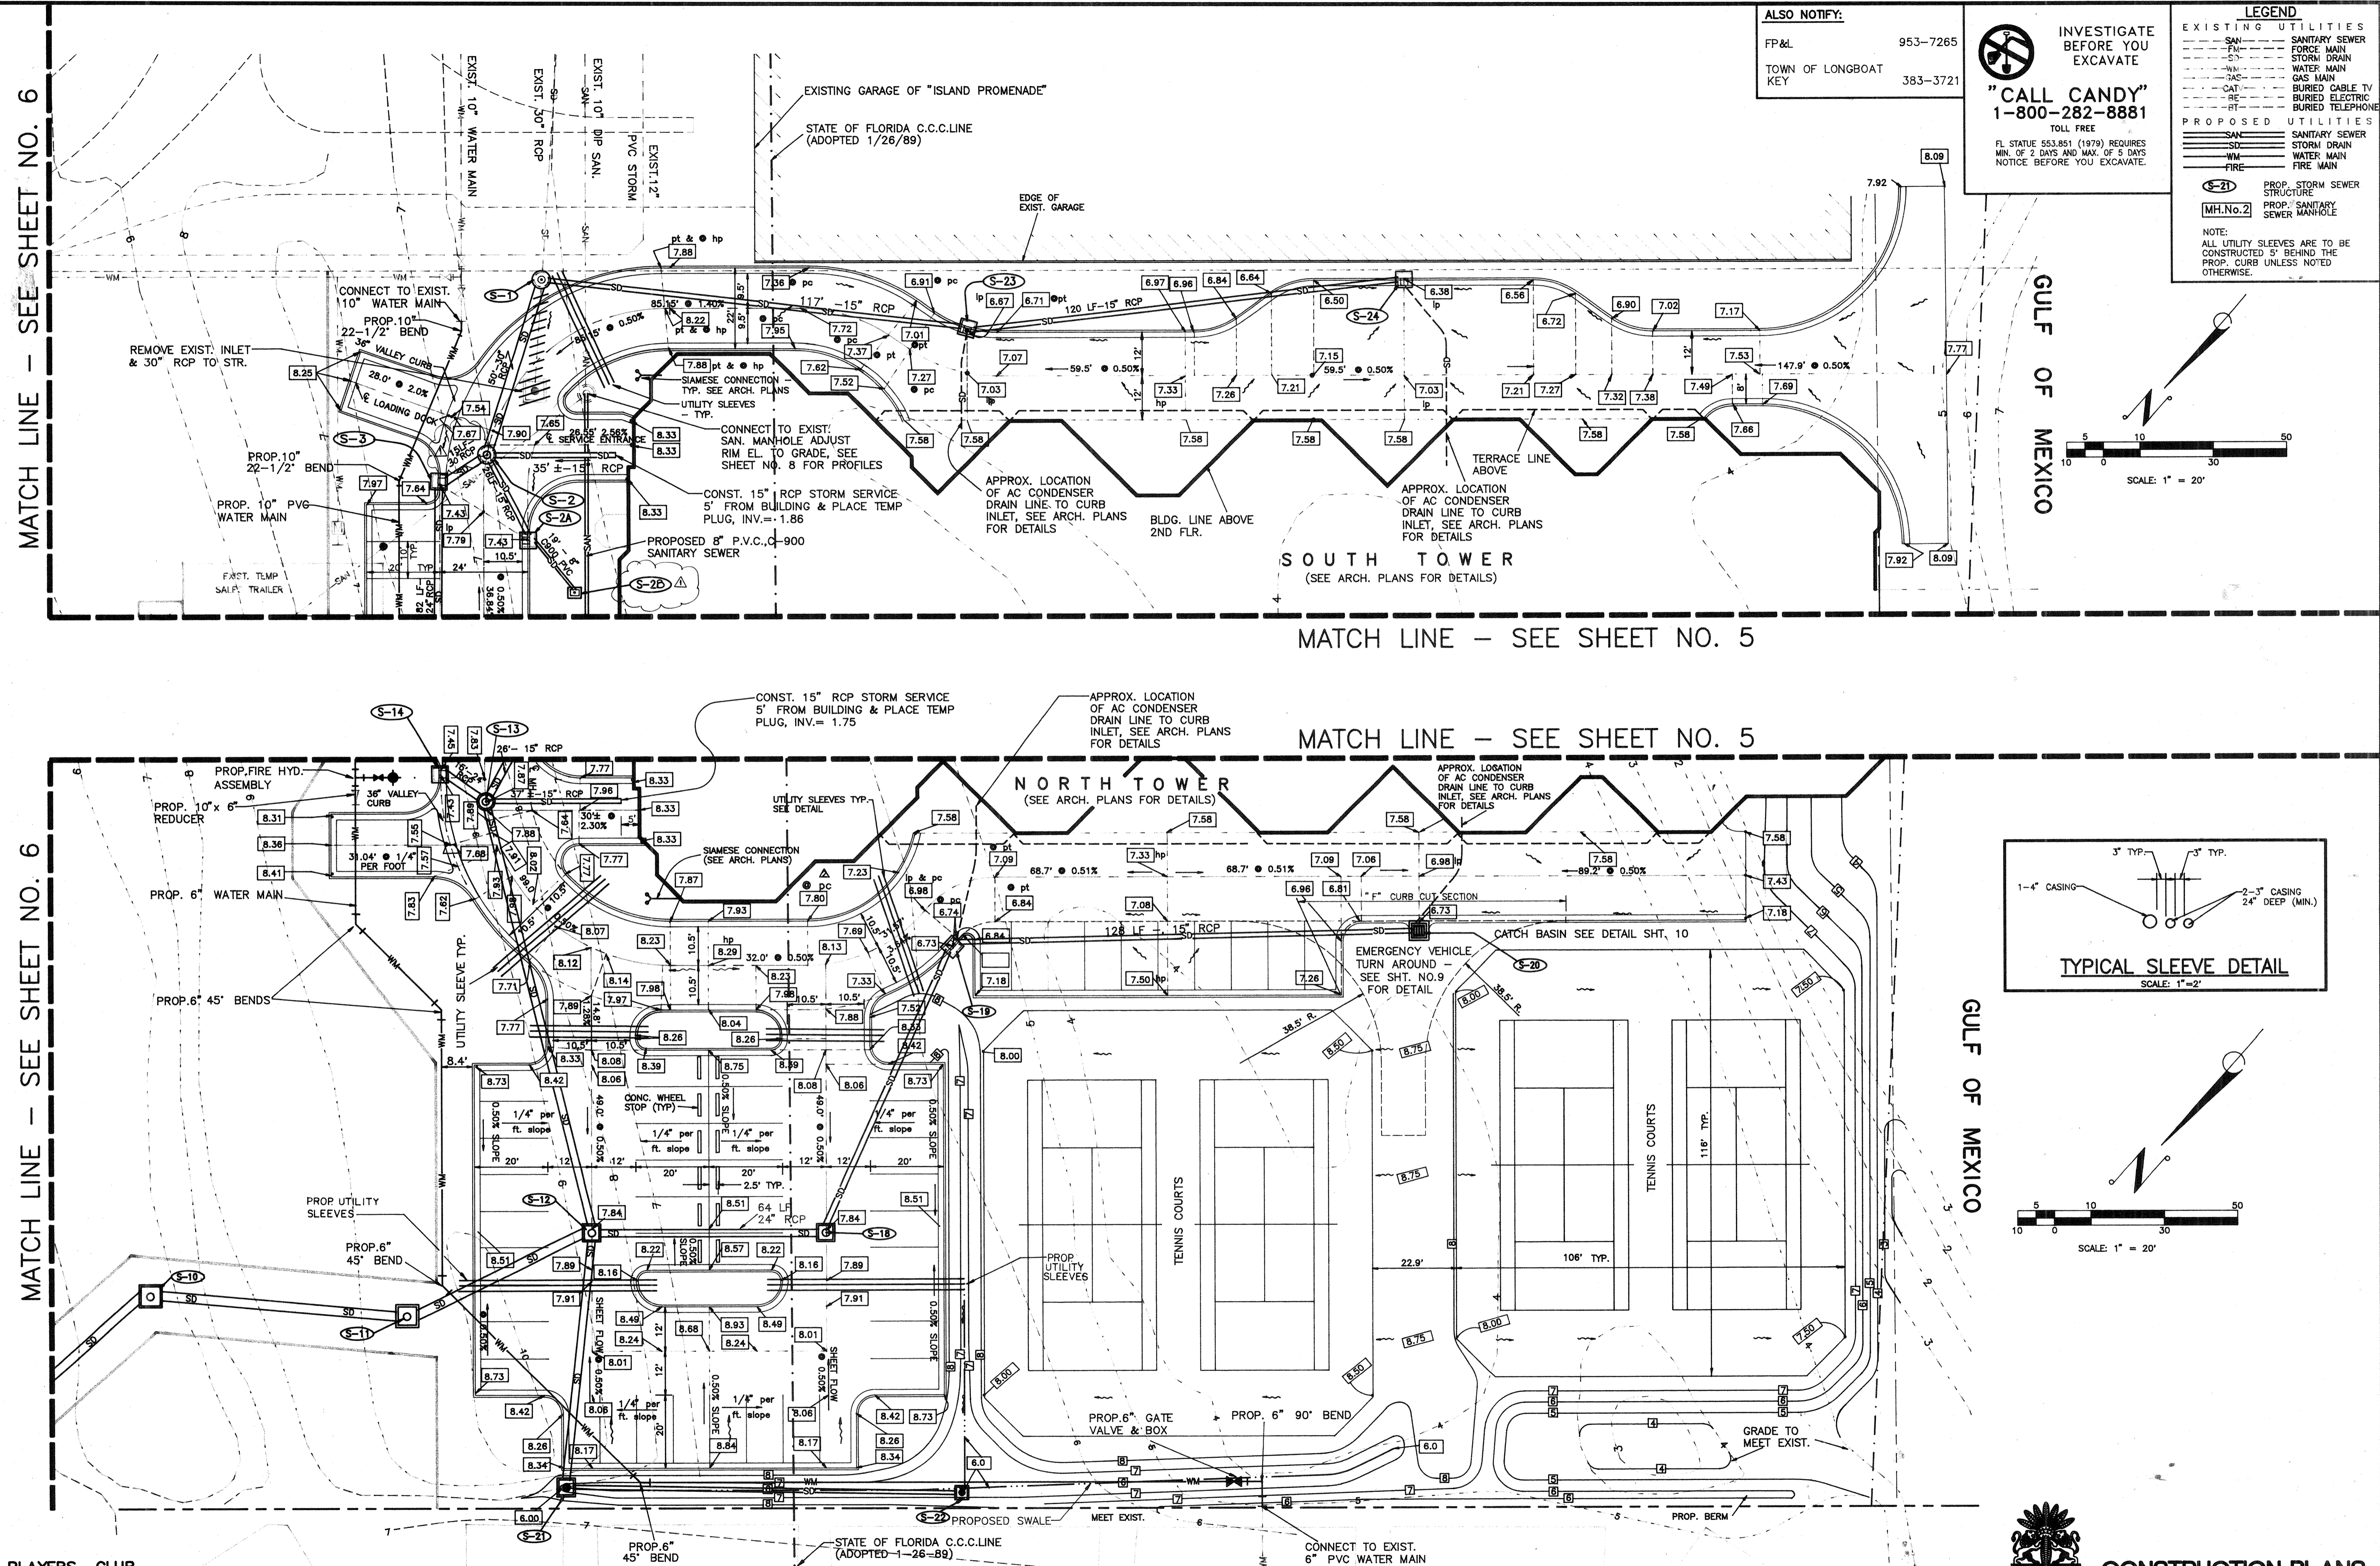

ALSO NOTIFY:  
FP&L 953-7265  
TOWN OF LONGBOAT KEY 383-3721

**LEGEND**

**EXISTING UTILITIES**

- SAN - SANITARY SEWER
- FM - FORCE MAIN
- SD - STORM DRAIN
- WM - WATER MAIN
- GAS - GAS MAIN
- CAT - BURIED CABLE TV
- RE - BURIED ELECTRIC
- BT - BURIED TELEPHONE


**PROPOSED UTILITIES**

- SAN - SANITARY SEWER
- SD - STORM DRAIN
- WM - WATER MAIN
- FIRE - FIRE MAIN
- S-21 - PROP. STORM SEWER STRUCTURE
- MH.No.2 - PROP. SANITARY SEWER MANHOLE

**"CALL CANDY"**  
1-800-282-8881  
TOLL FREE

FL. STATUTE 553.851 (1979) REQUIRES MIN. OF 2 DAYS AND MAX. OF 5 DAYS NOTICE BEFORE YOU EXCAVATE.

**NOTE:**  
ALL UTILITY SLEEVES ARE TO BE CONSTRUCTED 5' BEHIND THE PROP. CURB UNLESS NOTED OTHERWISE.

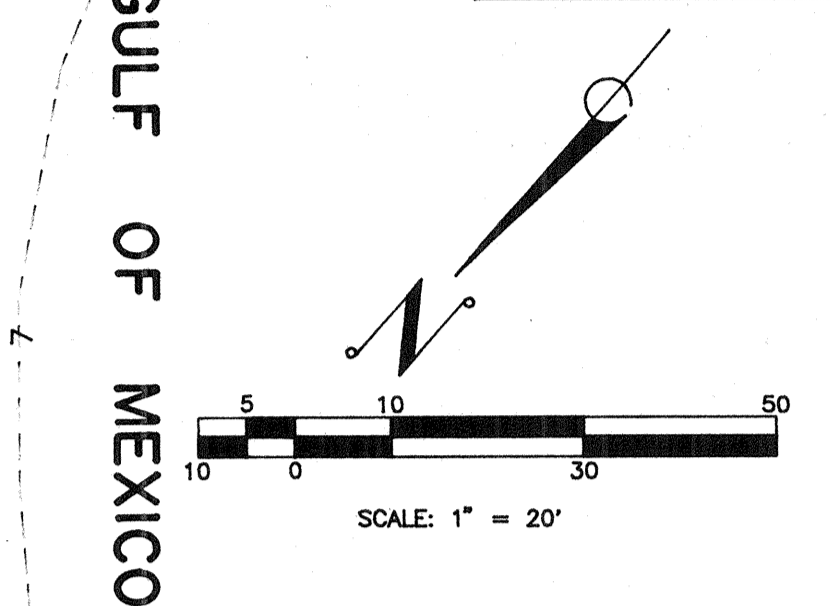

MATCH LINE - SEE SHEET NO. 5

MATCH LINE - SEE SHEET NO. 5

