


UNIT "A" - LEFT ELECTRICAL PLAN

scale 1/4" = 1'-0"

SEE ARCHITECT FOR ACTUAL
MOUNTING HEIGHTS
(TYP)
(BOTTOM OF FIXTURE
+ 6'-0")

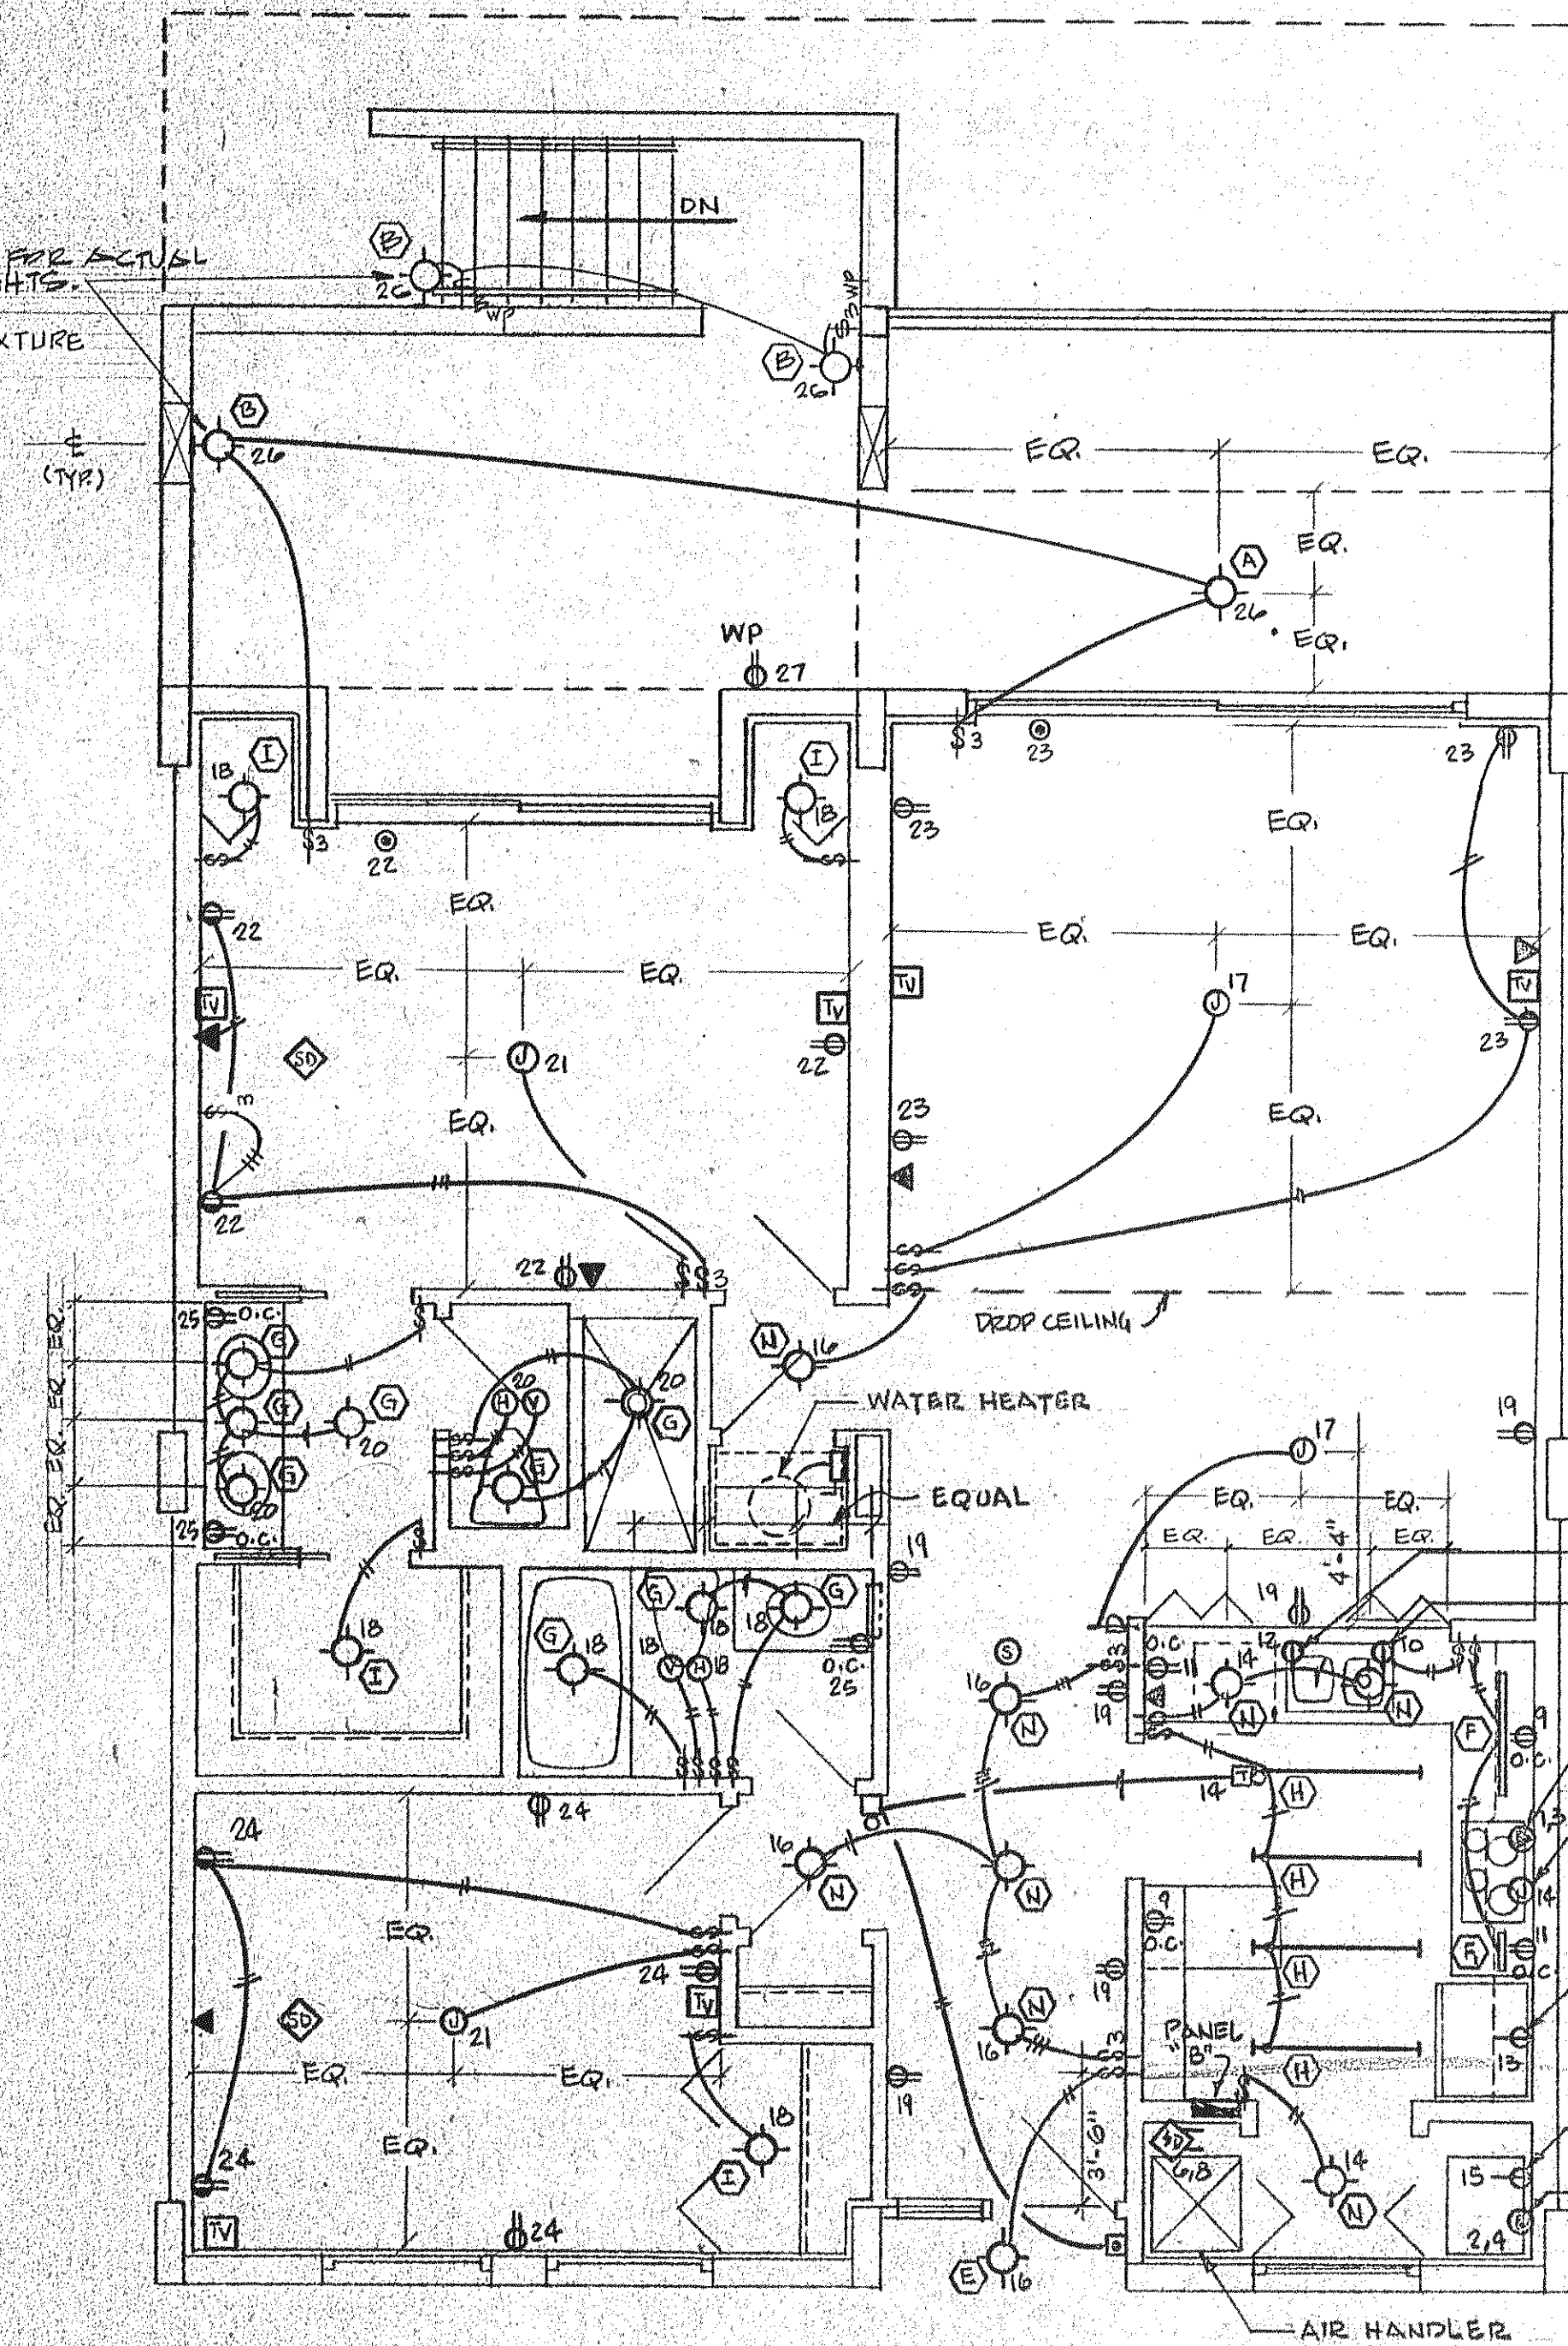

UNIT "A" - RIGHT ELECTRICAL PLAN

scale 1/4" = 1'-0"

- DISHWASHER OUTLET
- DISPOSAL OUTLET
- RANGE OUTLET
50A, 250V.
- RANGE HOOD J-BOX
- REFRIGERATOR OUTLET
36" A.F.F.
- WASHER OUTLET
- DRYER OUTLET
30A, 250V.

ISSUED	11-22
REVISED	
SHEET	
E-8	
OF	