


UNIT "B" LEFT ELECTRICAL PLAN

SCALE: 1/4" = 1'-0"

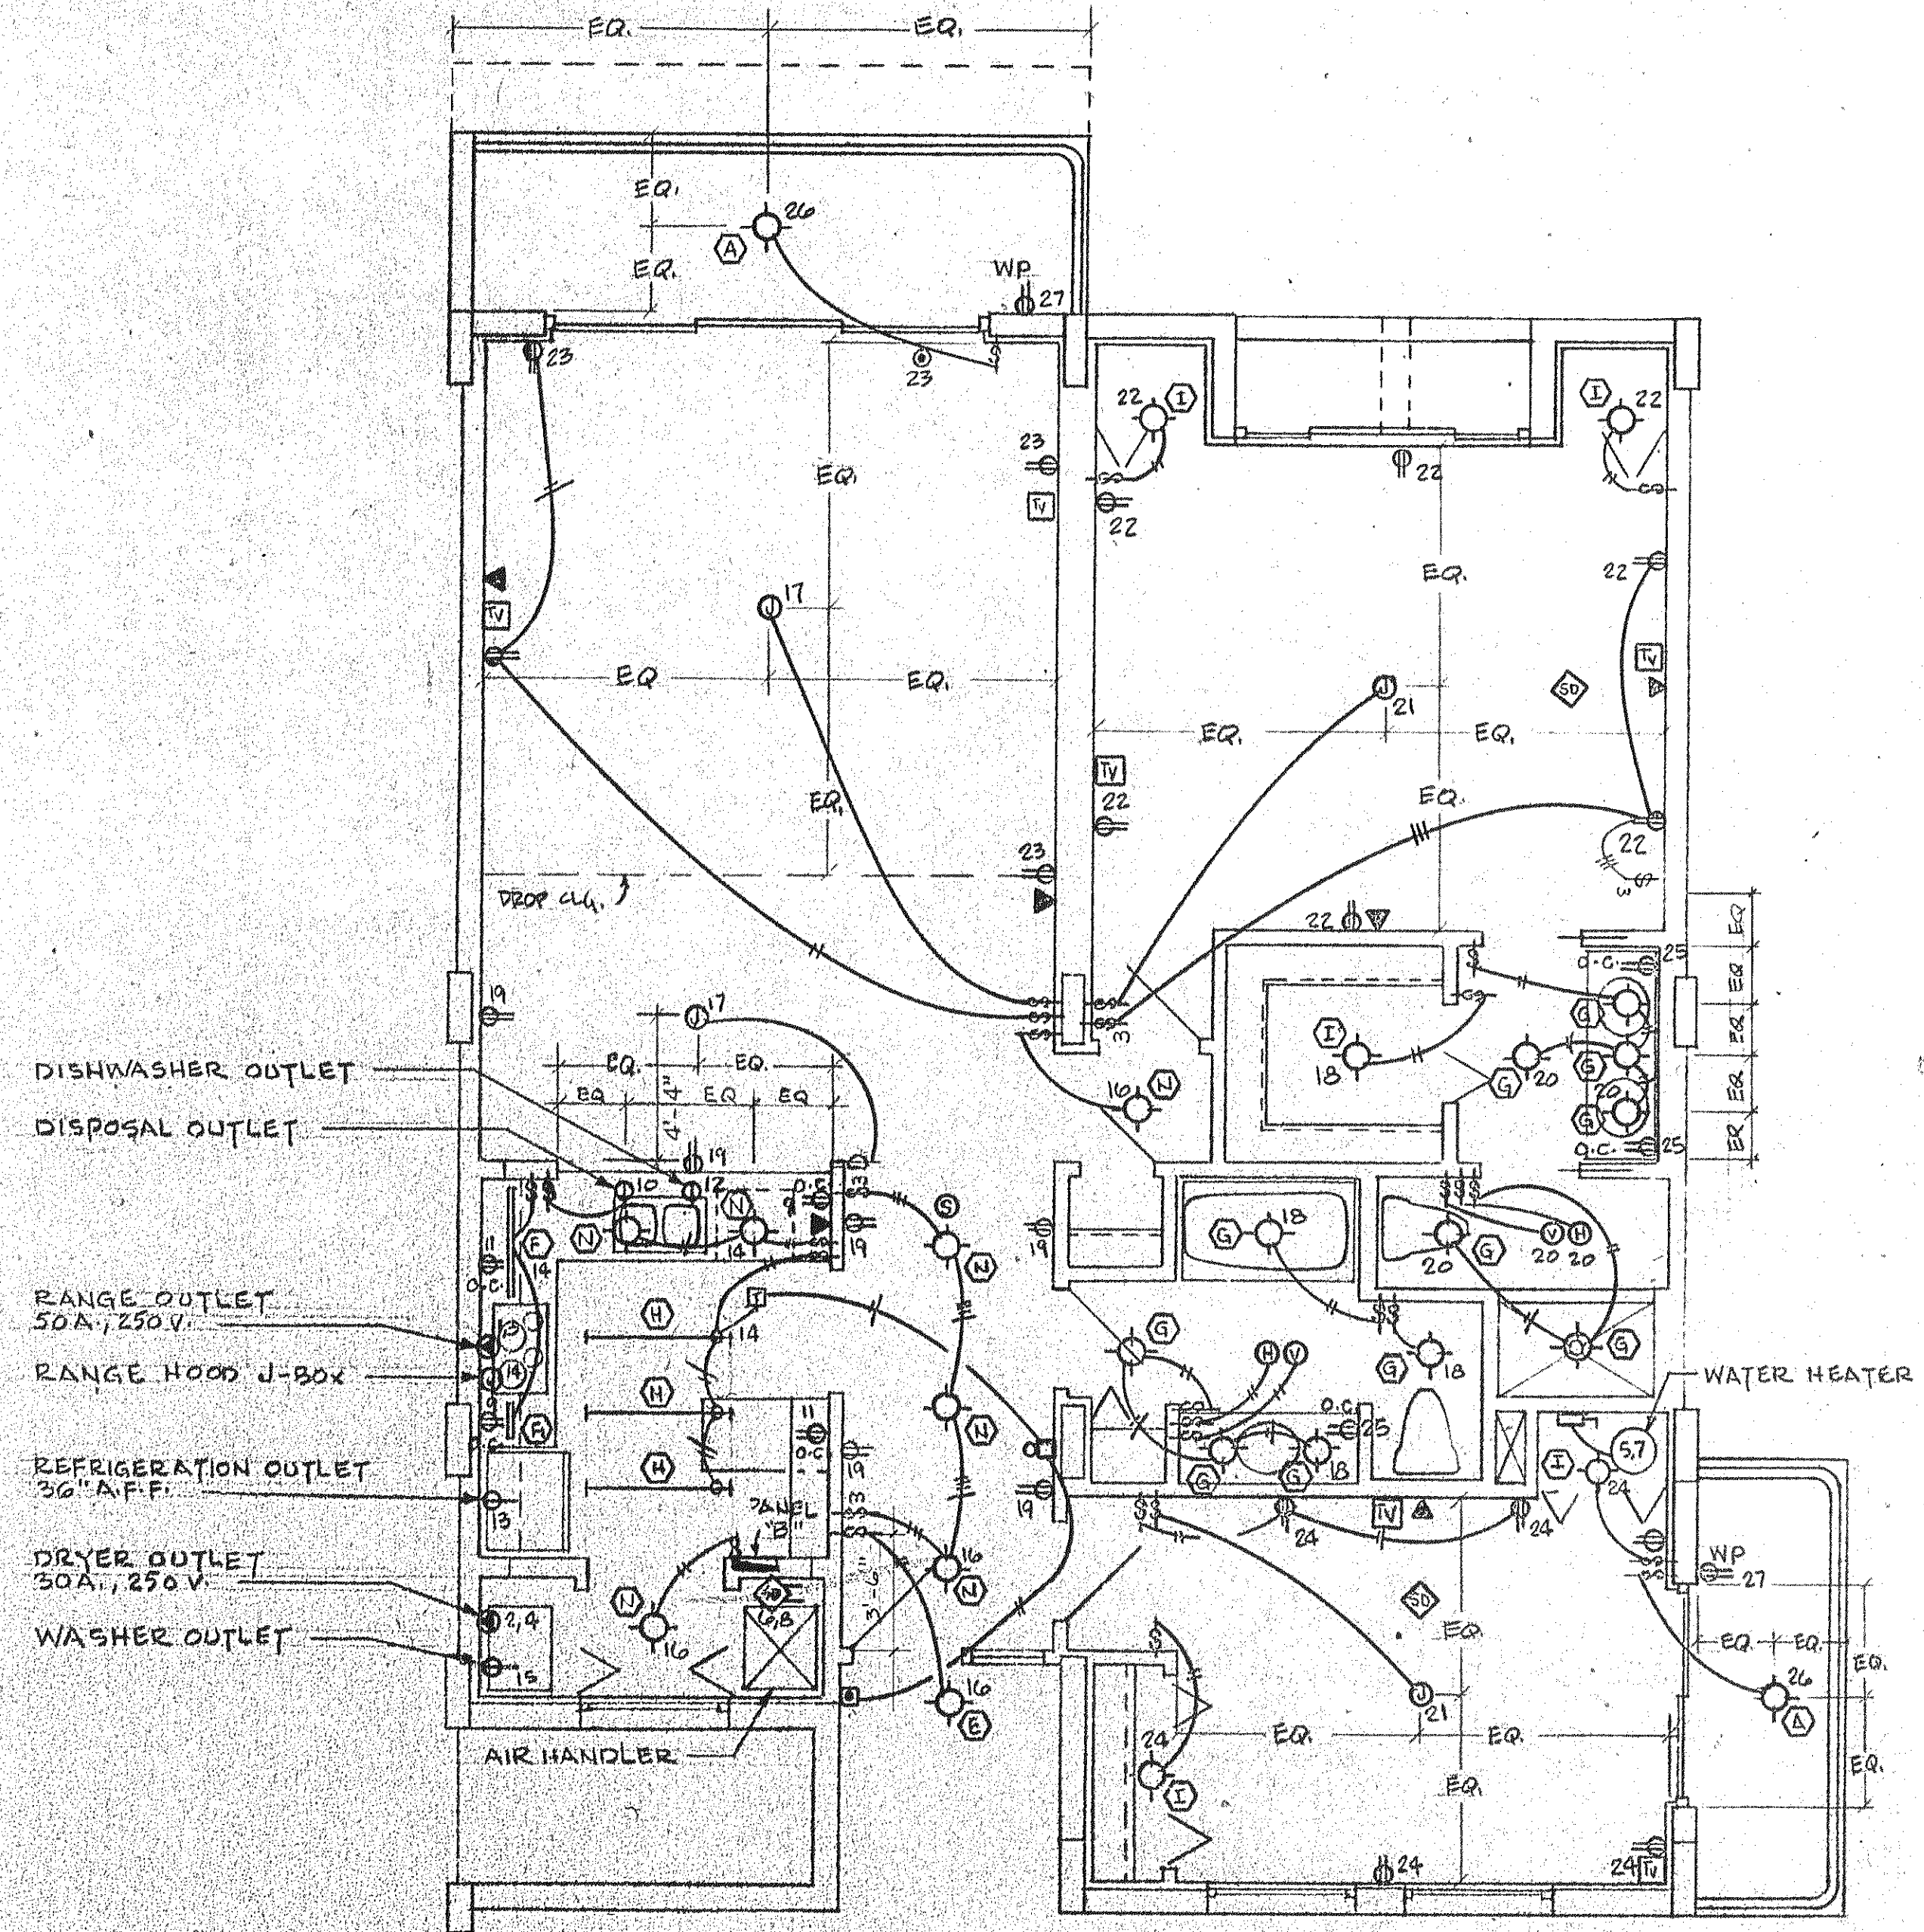

- DISHWASHER OUTLET
- DISPOSAL OUTLET
- RANGE OUTLET
50A., 250V.
- RANGE HOOD J-BOX
- REFRIGERATION OUTLET
30" A.F.F.
- DRYER OUTLET
30A., 250V.
- WASHER OUTLET

UNIT "B" RIGHT ELECTRICAL PLAN

SCALE: 1/4" = 1'-0"

ISSUED

REVISED

SHEET

E-9

OF