


UNIT "B" - LEFT ELECTRICAL PLAN

Scale: 1/4" = 1'-0"

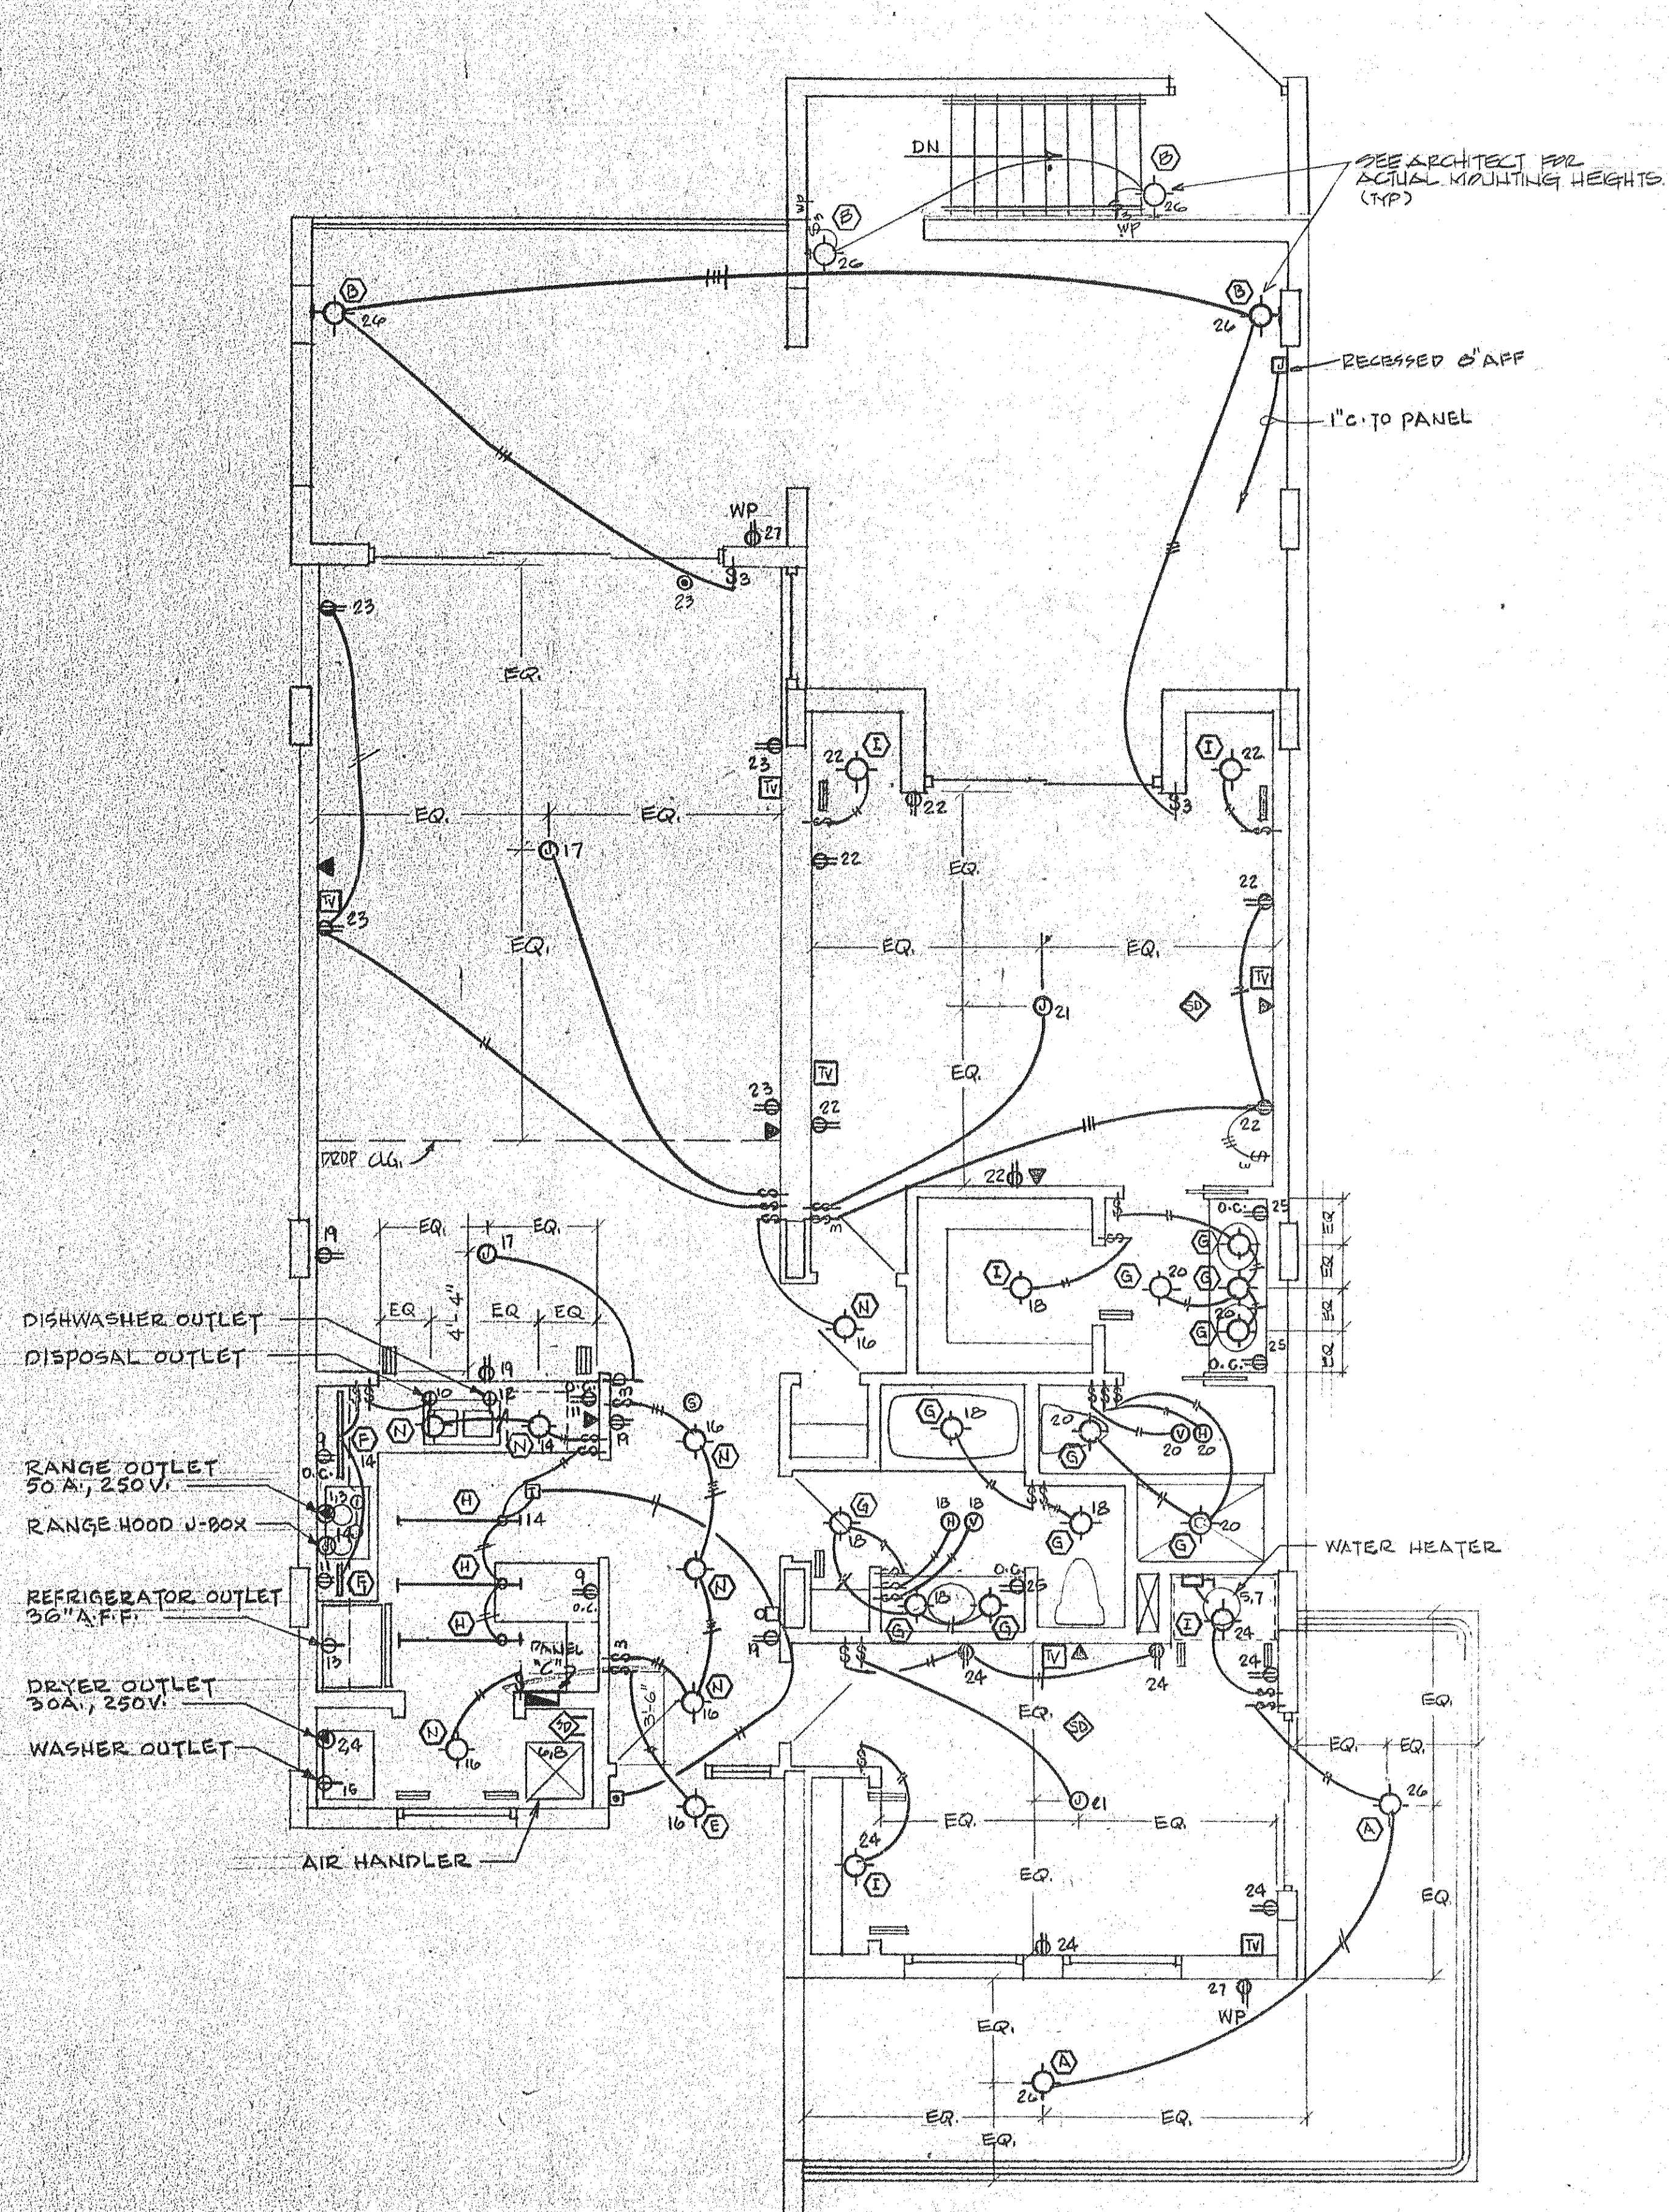

UNIT "B" - RIGHT ELECTRICAL PLAN

Scale: 1/4" = 1'-0"

ISSUED

REVISED

SHEET

E-10

OF