


**UNIT "C" LEFT**

Scale: 1/4" = 1'-0"

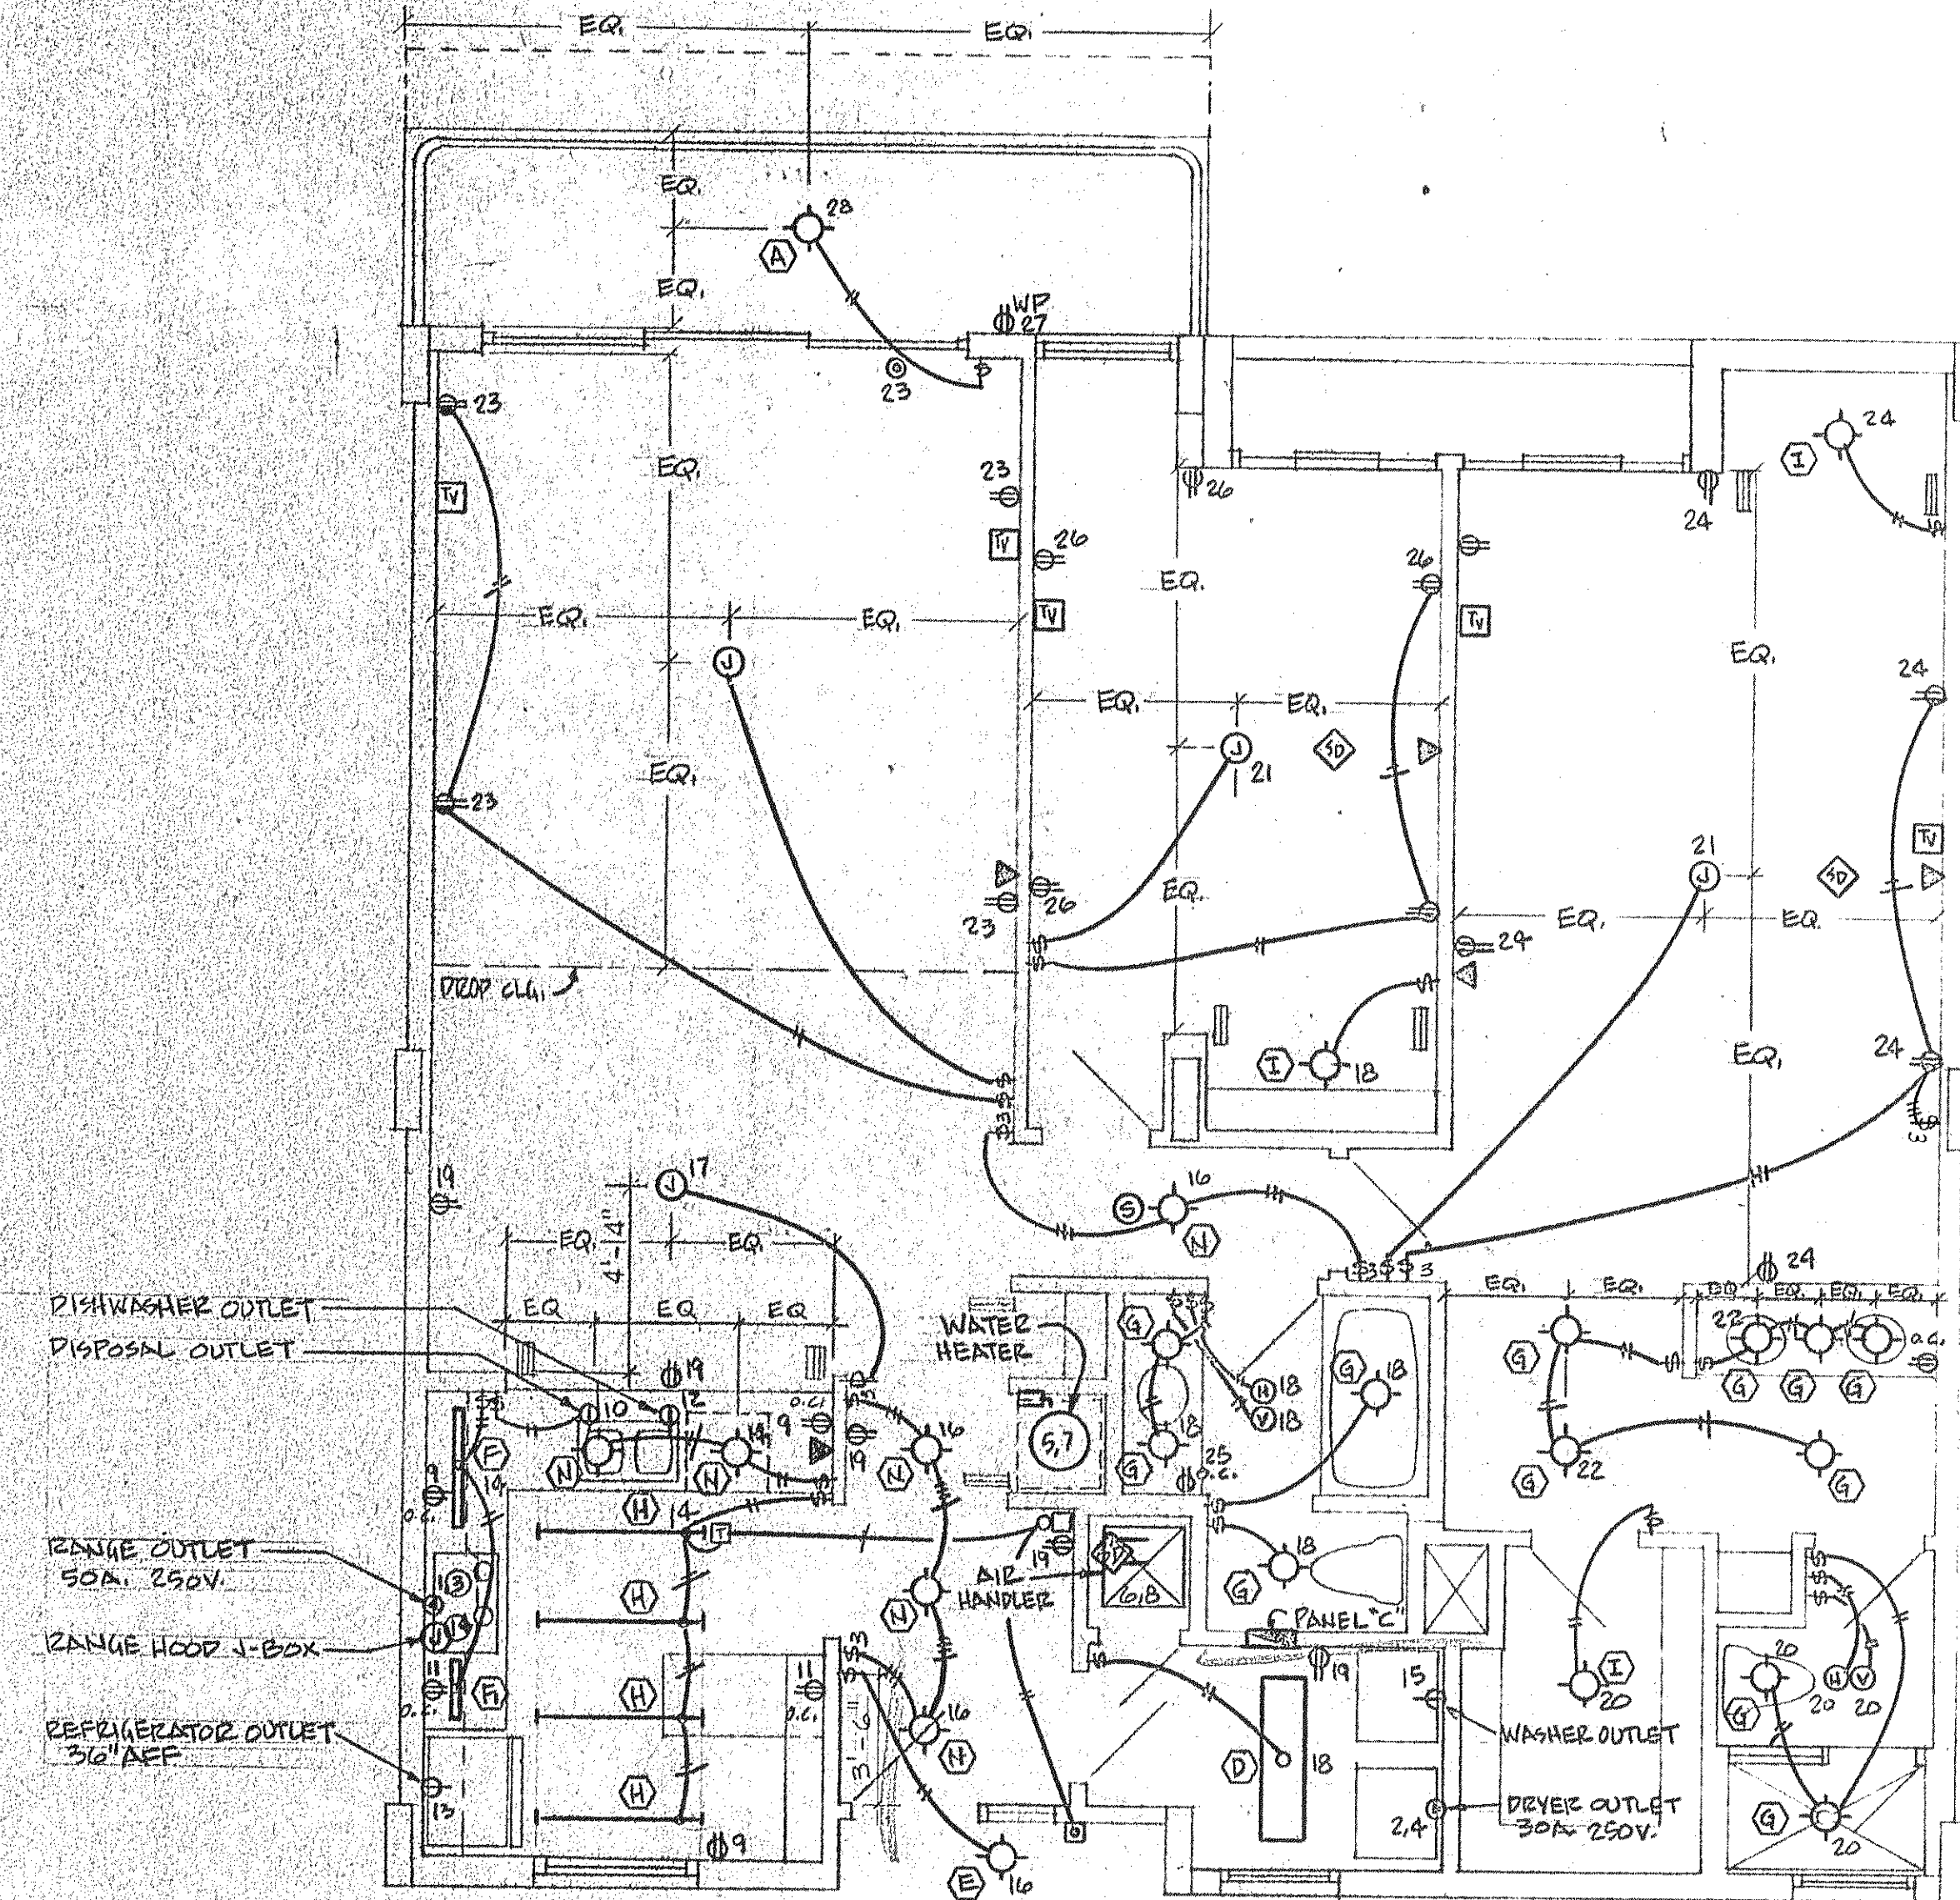

**UNIT "C" RIGHT - ELECTRICAL PLAN**

Scale: 1/4" = 1'-0"

ISSUED	
REVISED	
SHEET	
<b>E-11</b>	
OF	