


UNIT "C" - LEFT

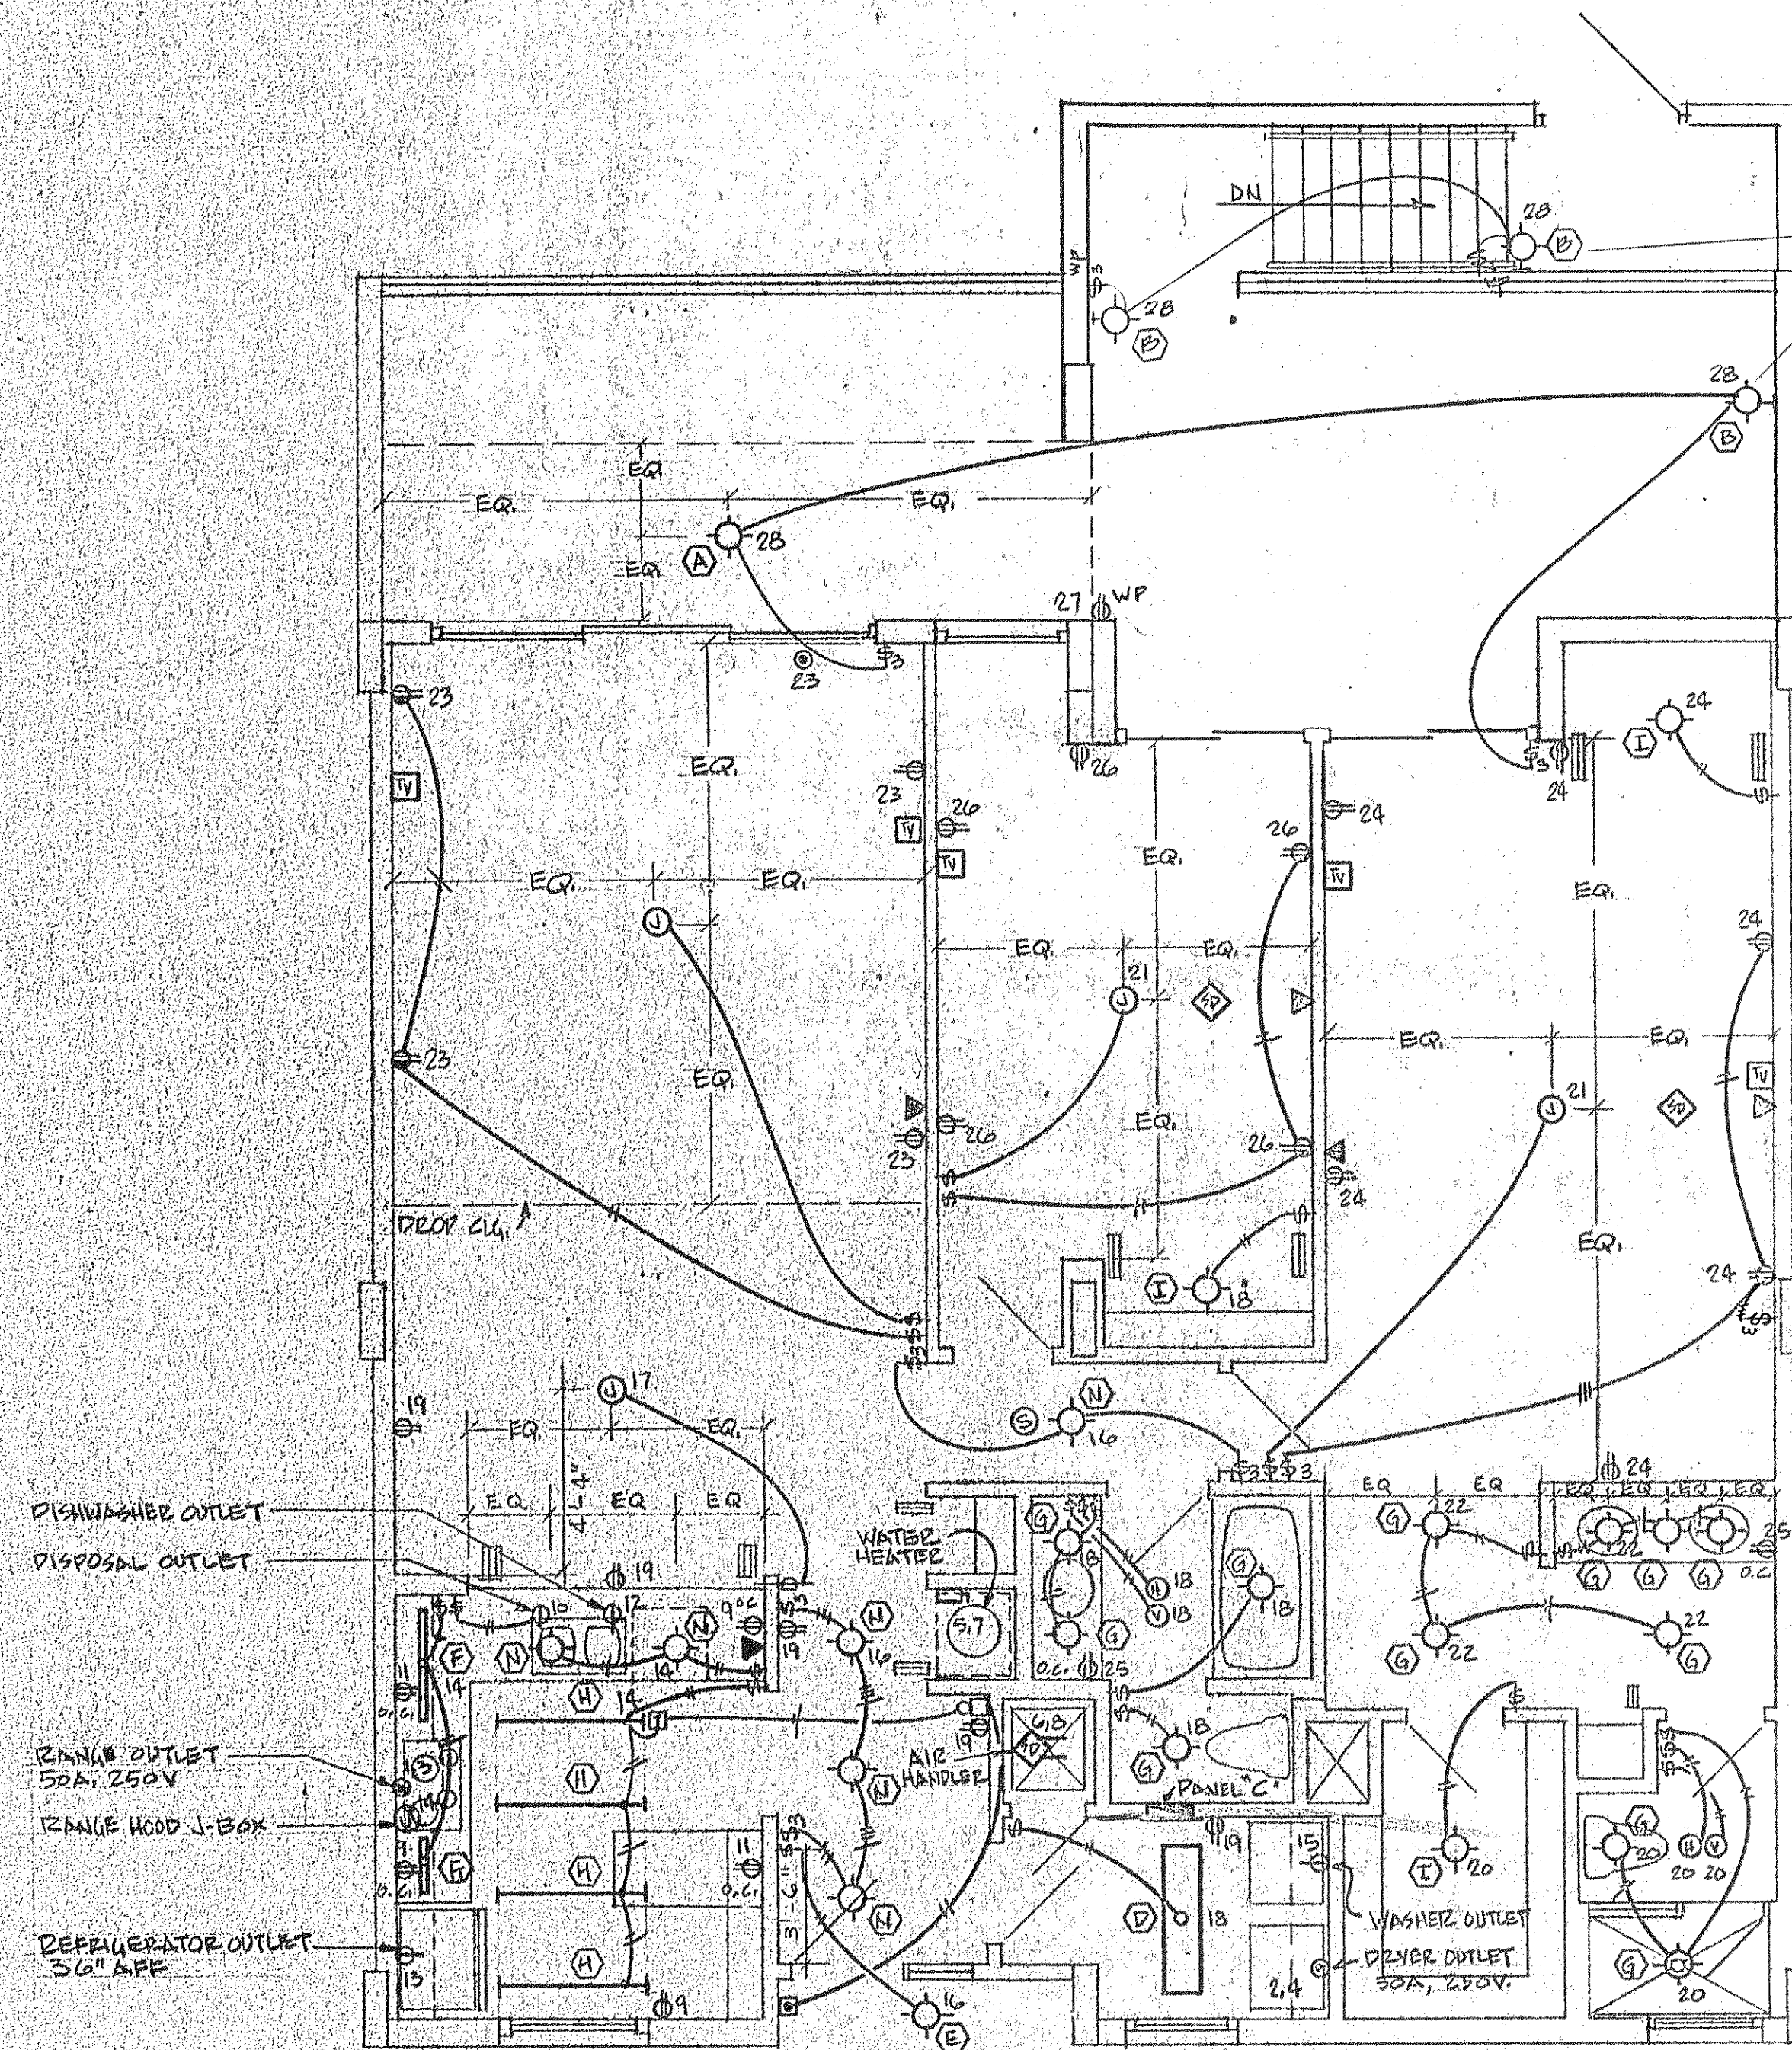

UNIT "C" - RIGHT - ELECTRICAL PLAN

scale 1/4" = 1'-0"

ISSUED	
REVISED	
SHEET	
<b>E-12</b>	
OF	