


AIR CONDITIONING EQUIPMENT SCHEDULE								
UNIT NO.	LOCATION (APT. TYPE)	CFM	COOLING CAPACITY (BTU/H)	HEATING CAPACITY (BTU/H)	EER	AUX. HEAT (KW)	CONDENSING UNIT AIR HANDLER (COP OR EER)	
1	A	800	26,000	15,000	28,000	8.9	5.9	BWR 924/BWV 924
2	A, 1 APT. B	1000	31,500	23,000	23,000	8.4	4.8	BWR 950/BWV 950
3	1 B101 & 1L 5, 51 & 500	1,300	34,000	26,000	39,000	8.2	4.8	BWR 930/BWV 930
4	D	1,600	48,000	34,000	51,000	8.0	8.2	BWR 940/BWV 940
5	D1, D MOD	2,000	50,000	39,000	51,000	8.5	8.5	BWR 940/BWV 940
6	LOBBY	950	17,000	15,000	16,900	7.1	5.0	YORK HIGGINS 400/1162015

- (A) CAPACITY BASED ON 80°F DB, 67°F WB ENT. EVAP. 95° CONDENSING AIR
- (B) RATED CAPACITY AT 240V
- (C) ELECTRIC SERVICE = 208V, 1Ø, 400Y
- (D) CAPACITY AT 70°F INDOOR, 47°F OUTDOOR


APT. NUMBER	APT. TYPE	DC UNIT NO.	REF. LINES
2501 B DC-3 3/45 3/8L	2502 C MOD DC-3 3/45 3/8L	2503 A DC-2 3/45 3/8L	2504 B DC-3 3/45 3/8L
2401 B DC-2 3/45 3/8L	2402 C DC-3 3/45 3/8L	2403 A DC-1 3/45 3/8L	2404 B DC-2 3/45 3/8L
2301 B DC-2 3/45 3/8L	2302 C DC-3 3/45 3/8L	2303 A DC-1 3/45 3/8L	2304 B DC-2 3/45 3/8L
2201 B DC-2 7/85 3/8L	2202 C DC-3 7/85 3/8L	2203 A DC-1 3/45 3/8L	2204 B DC-2 7/85 3/8L
2101 B+ DC-3 7/85 3/8L	2102 L+ DC-3 7/85 3/8L	2103 D+ DC-2 3/45 3/8L	2104 B+ DC-3 7/85 3/8L

LOBBY REF. LINES: 3/45 3/8L
BUILDING #2

AIR DISTRIBUTION DEVICES SHALL BE "LIMA" OR EQUAL SUPPLY AIR REGISTERS (SAR) - SERIES 90 VH CB CEILING DIFFUSERS (CD) - SERIES 95 FM CB RETURN AIR GRILLES - SERIES 90 RA H

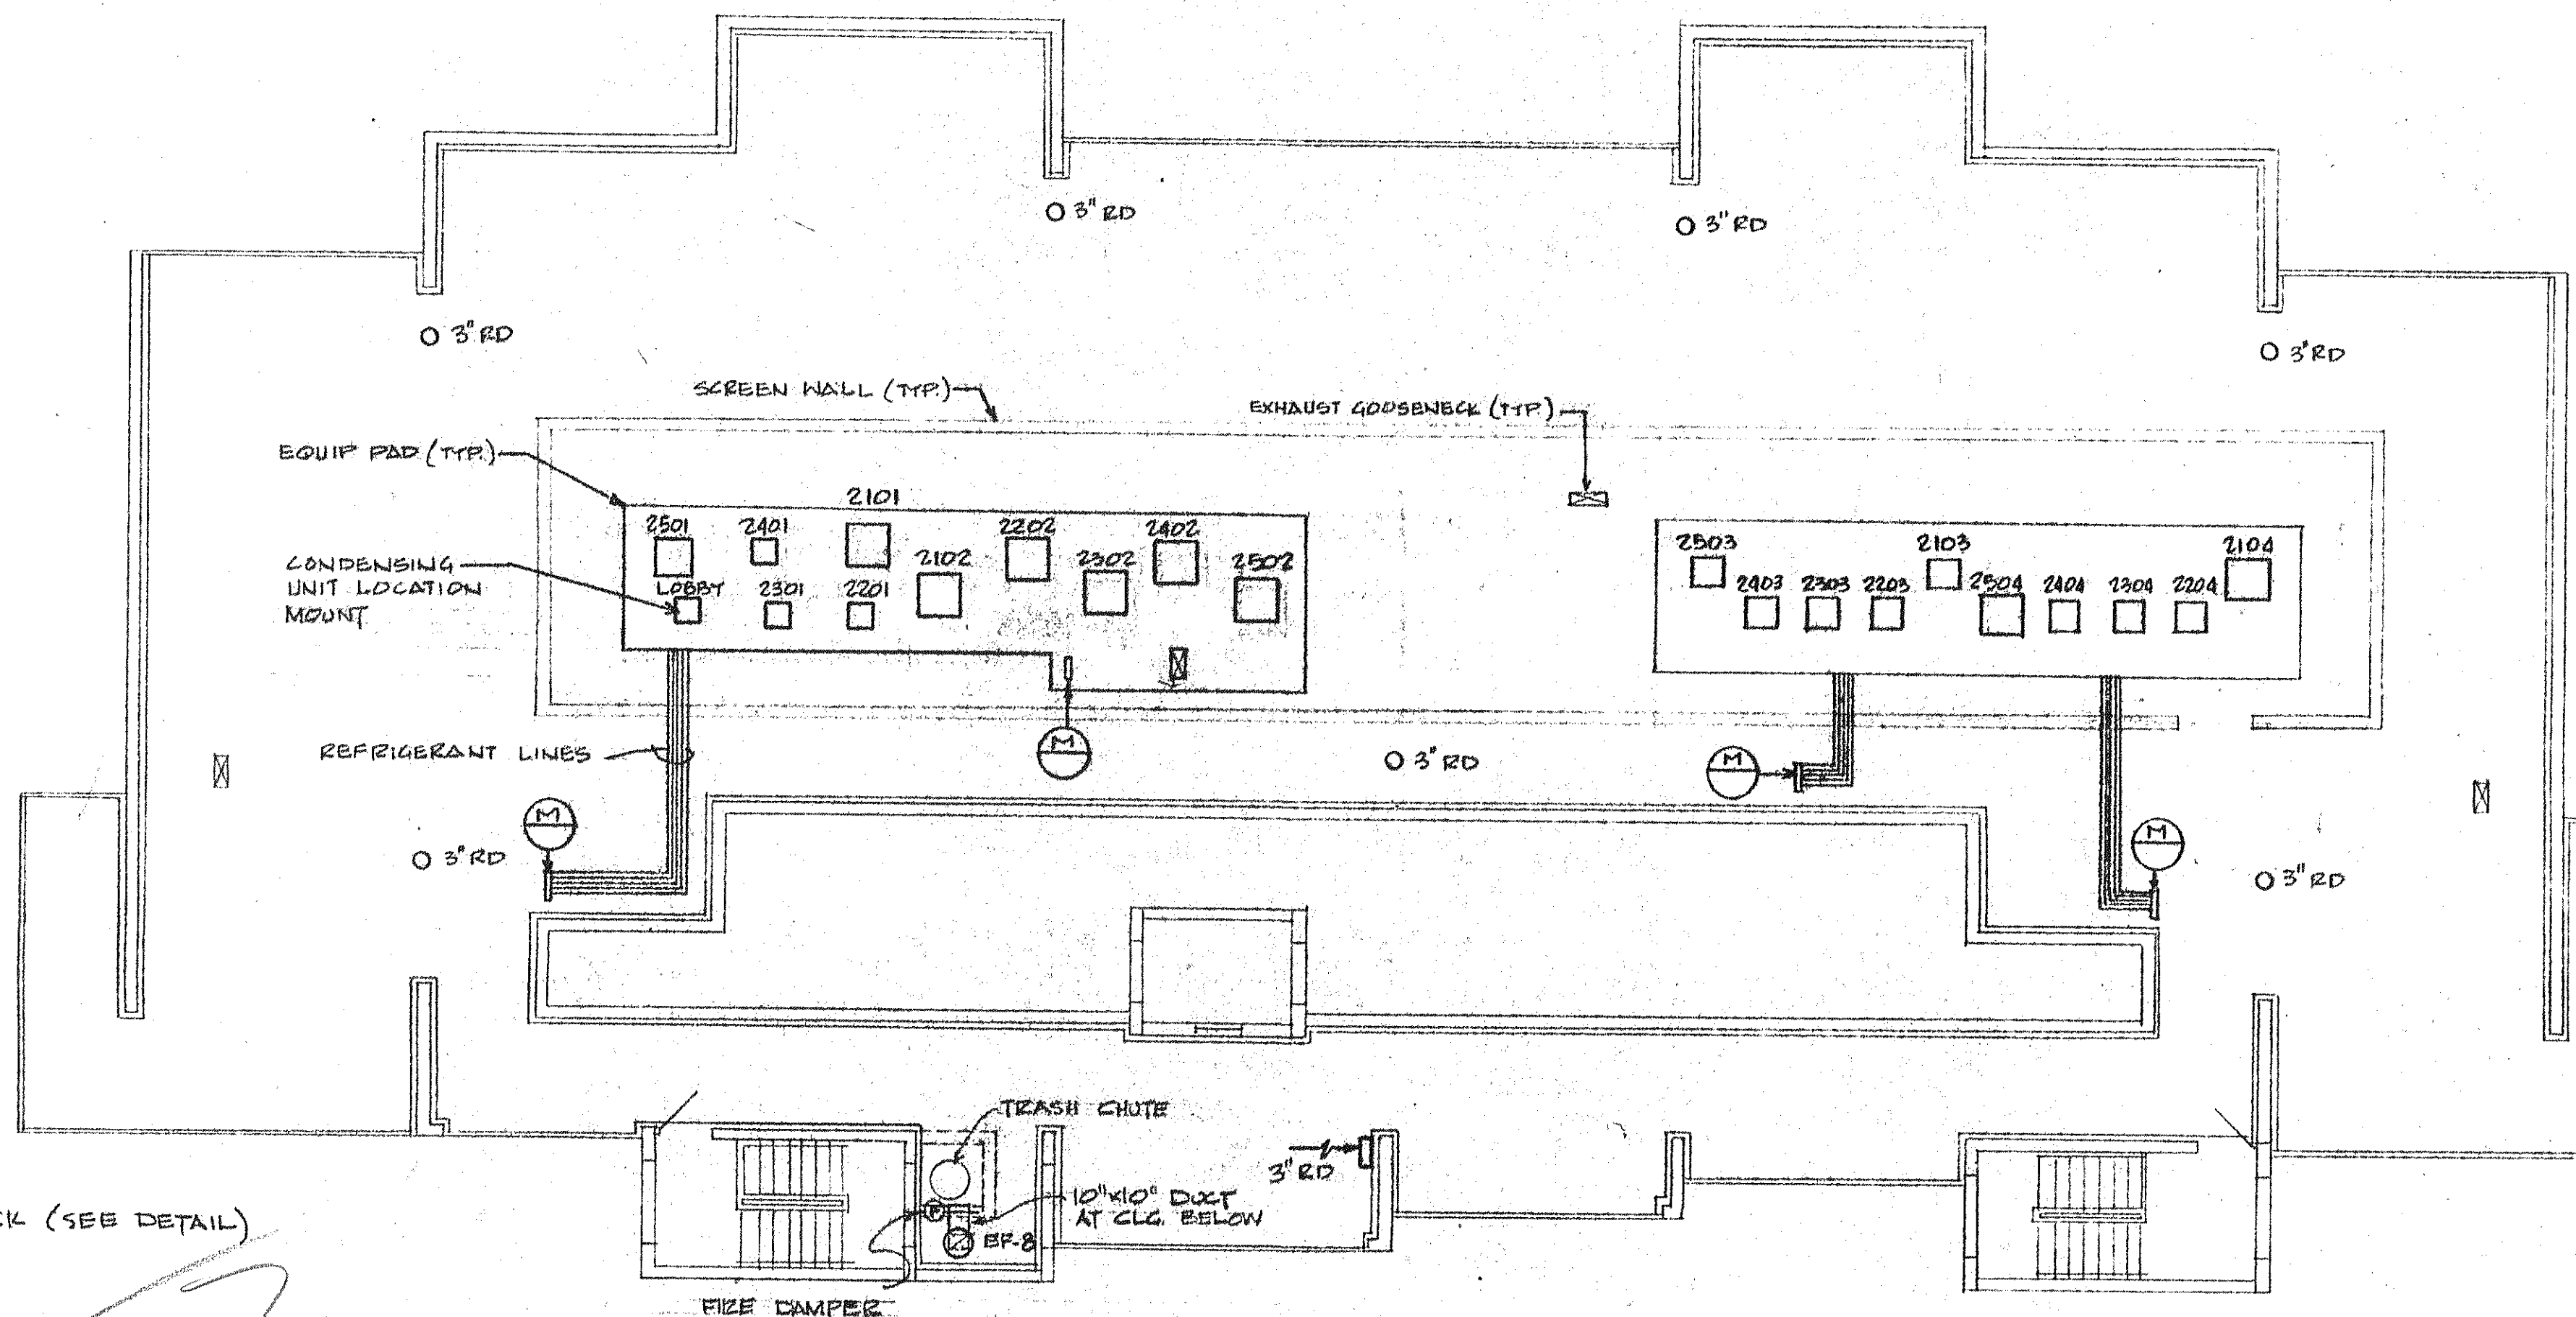

BUILDING 2 - ROOF PLAN AIR CONDITIONING
scale 1/8" = 1'-0"

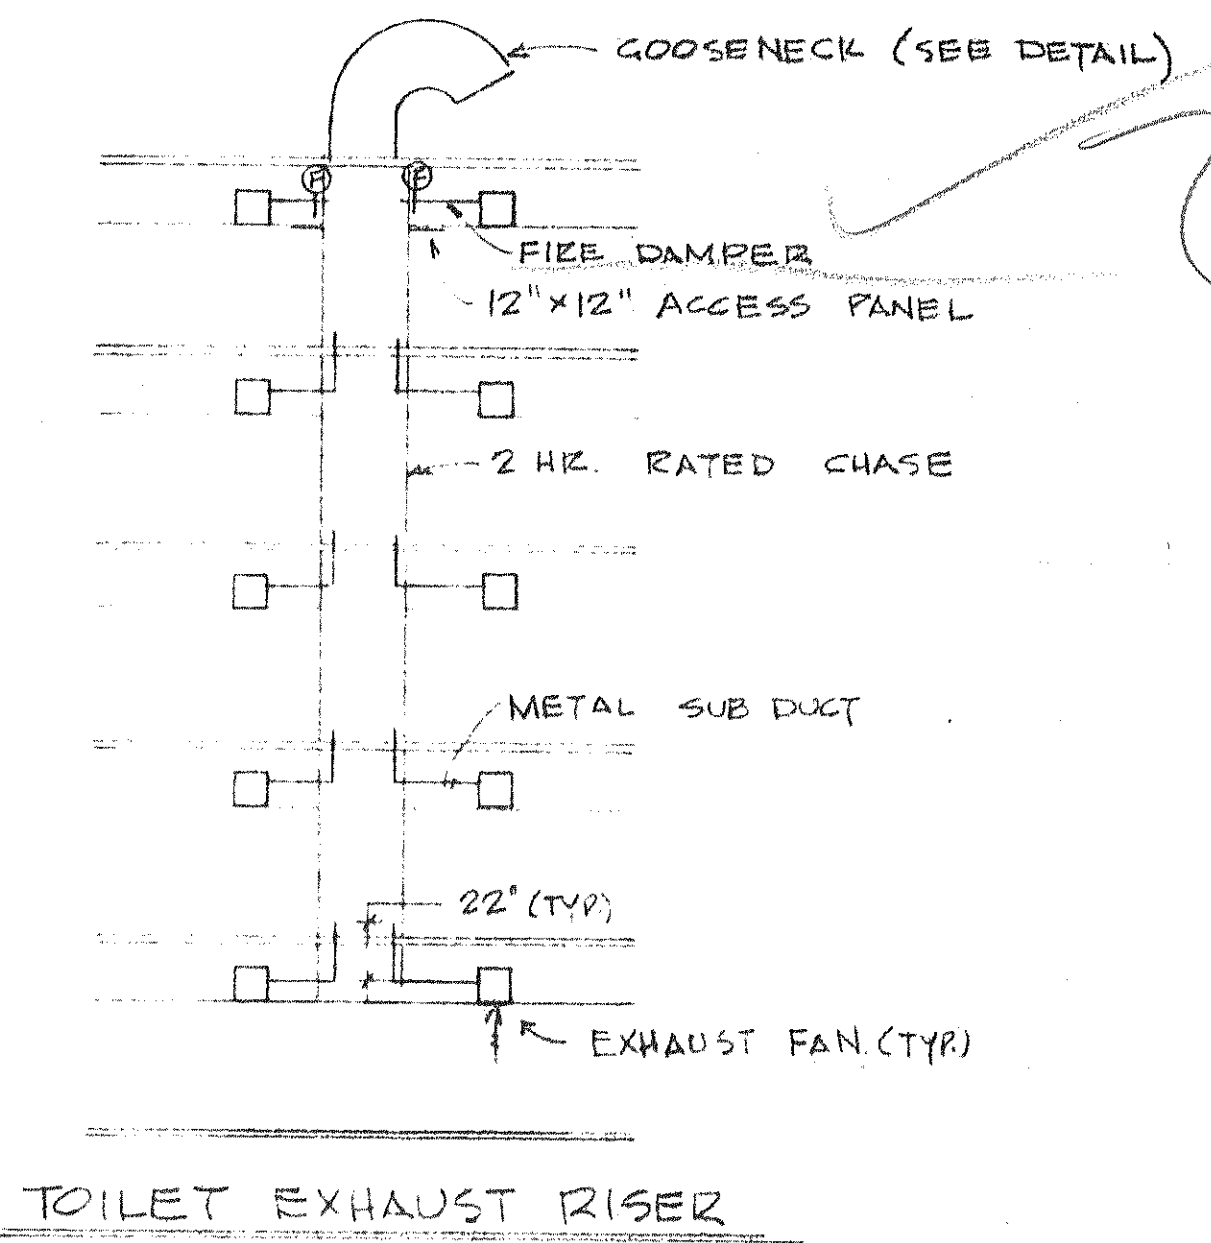

FAN NO.	MAKE OR EQUAL	USE	CFM	SP IN H2O	RPM	HP	ELECTRIC
EF-1	GREENHECK CSP-8	EXHAUST	31	.250	1550	1/125	120-1-60
EF-2	GREENHECK CSP-15	EXHAUST	72	.125	1000	1/150	120-1-60
EF-3	GREENHECK CSP-17	EXHAUST	141	.125	1550	1/50	120-1-60
EF-4	GREENHECK CSP-50	EXHAUST	358	.125	1050	1/15	120-1-60
EF-5	GREENHECK SPC-30	EXHAUST	9640	.125	495	1/2	120-1-60
EF-6	GREENHECK SPC-30	EXHAUST	7660	.125	435	1/3	120-1-60
EF-7	GREENHECK SDP-24-3-10	EXHAUST	450	.250	860	1/12	120-1-60
EF-8	GREENHECK G-GB-E	EXHAUST	110	.125	1050	1/80	120-1-60
EF-9	GREENHECK SOE-32-D	EXHAUST	117	.125	1550	1/80	120-1-60

SUNSET BEACH SOF LONG BOAT KEY
 ARVDA CORPORATION EDWARD J SEBERT AIA ARCHITECT & PLANNER PA THE SWA GROUP
 BRABHAM KUMINS DEBAY CONSULTING ENGINEERS OLSEN WHITE & ASSOCIATES STRUCTURAL ENGINEERS BENNETT & BISHOP INC CONSULTING ENGINEERS & SURVEYORS
 ISSUED
 REVISED
 SHEET
M-3
 BLDG. 2
 OF