


UNIT "A" LEFT PLUMBING PLAN

Scale 1/4" = 1'-0"

TYPICAL LOCATION OF
SIDEWALL SPRINKLER HEAD

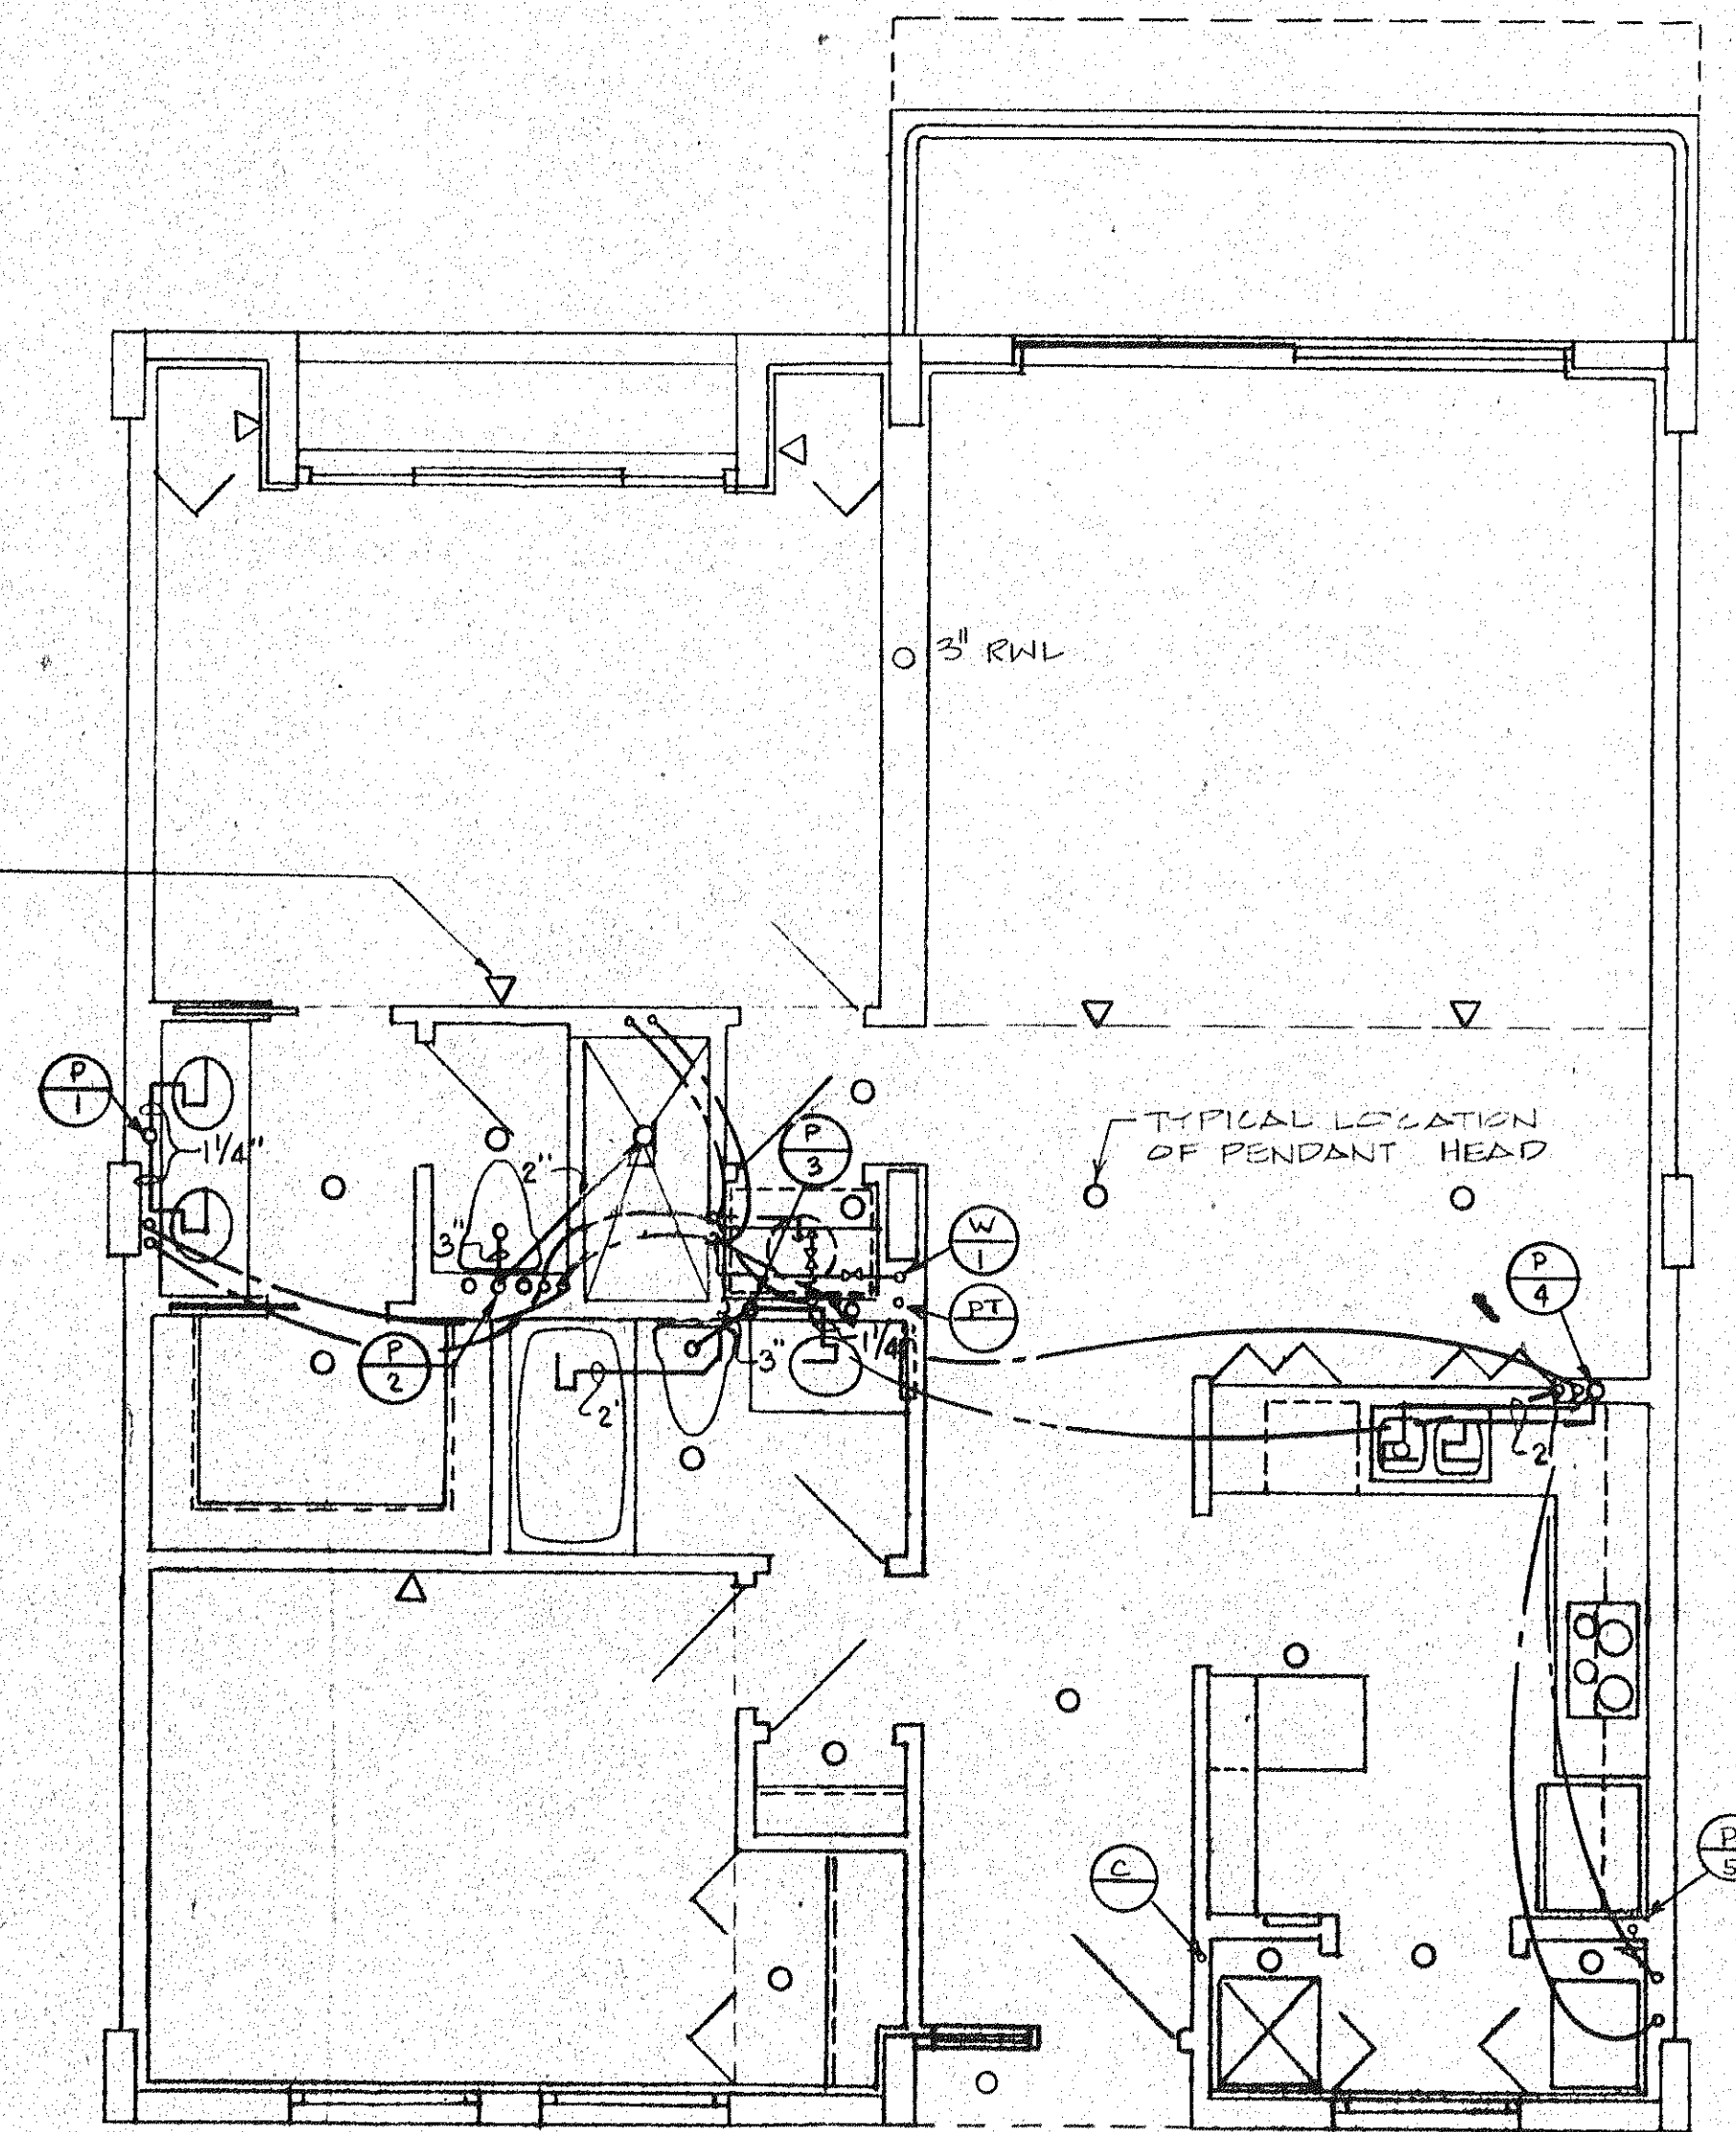

UNIT "A" RIGHT PLUMBING PLAN

Scale 1/4" = 1'-0"

NOTE FOR ALL APARTMENTS:
SEE APARTMENT RISERS FOR CONNECTIONS
TO DISHWASHER AND ICE MAKERS IN
REFRIGERATOR.