


UNIT 'A' - LEFT PLUMBING PLAN
 SCALE 1/8" = 1'-0"

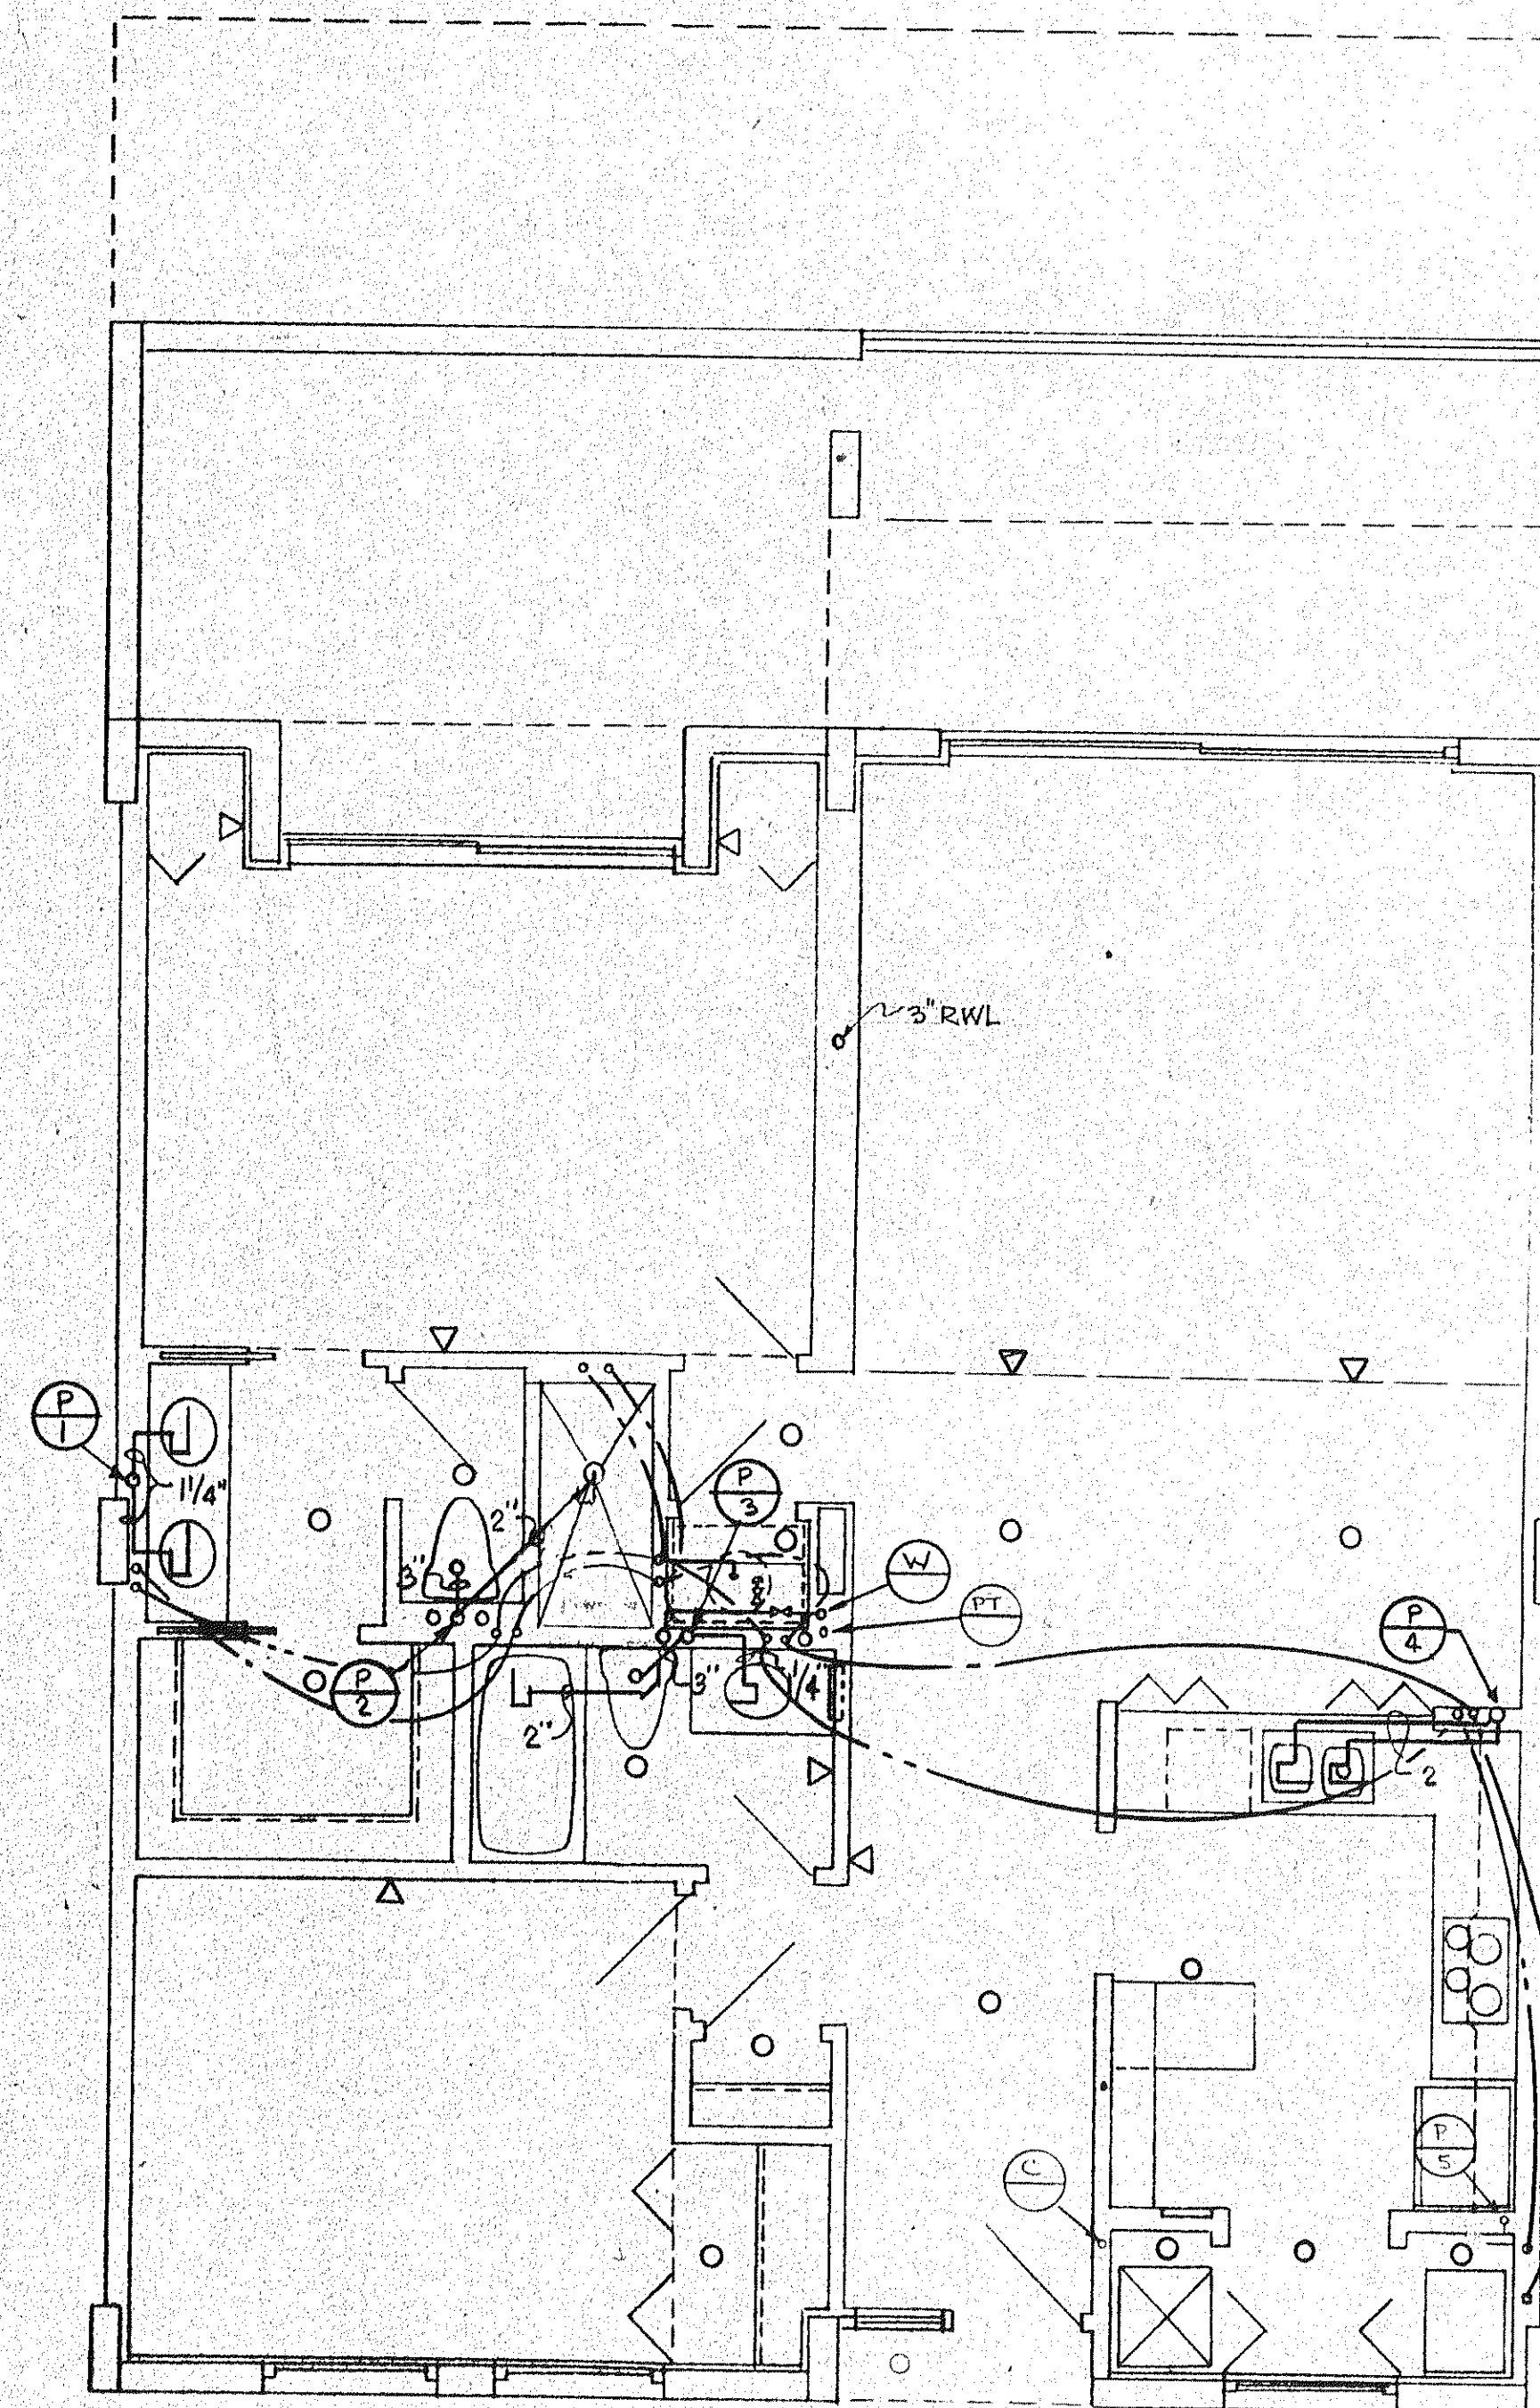

UNIT 'A' - RIGHT PLUMBING PLAN
 SCALE 1/8" = 1'-0"

ISSUE
 4-1-01

REVISION