


**UNIT 'B' LEFT. PLUMBING PLAN**

scale: 1/4" = 1'-0"

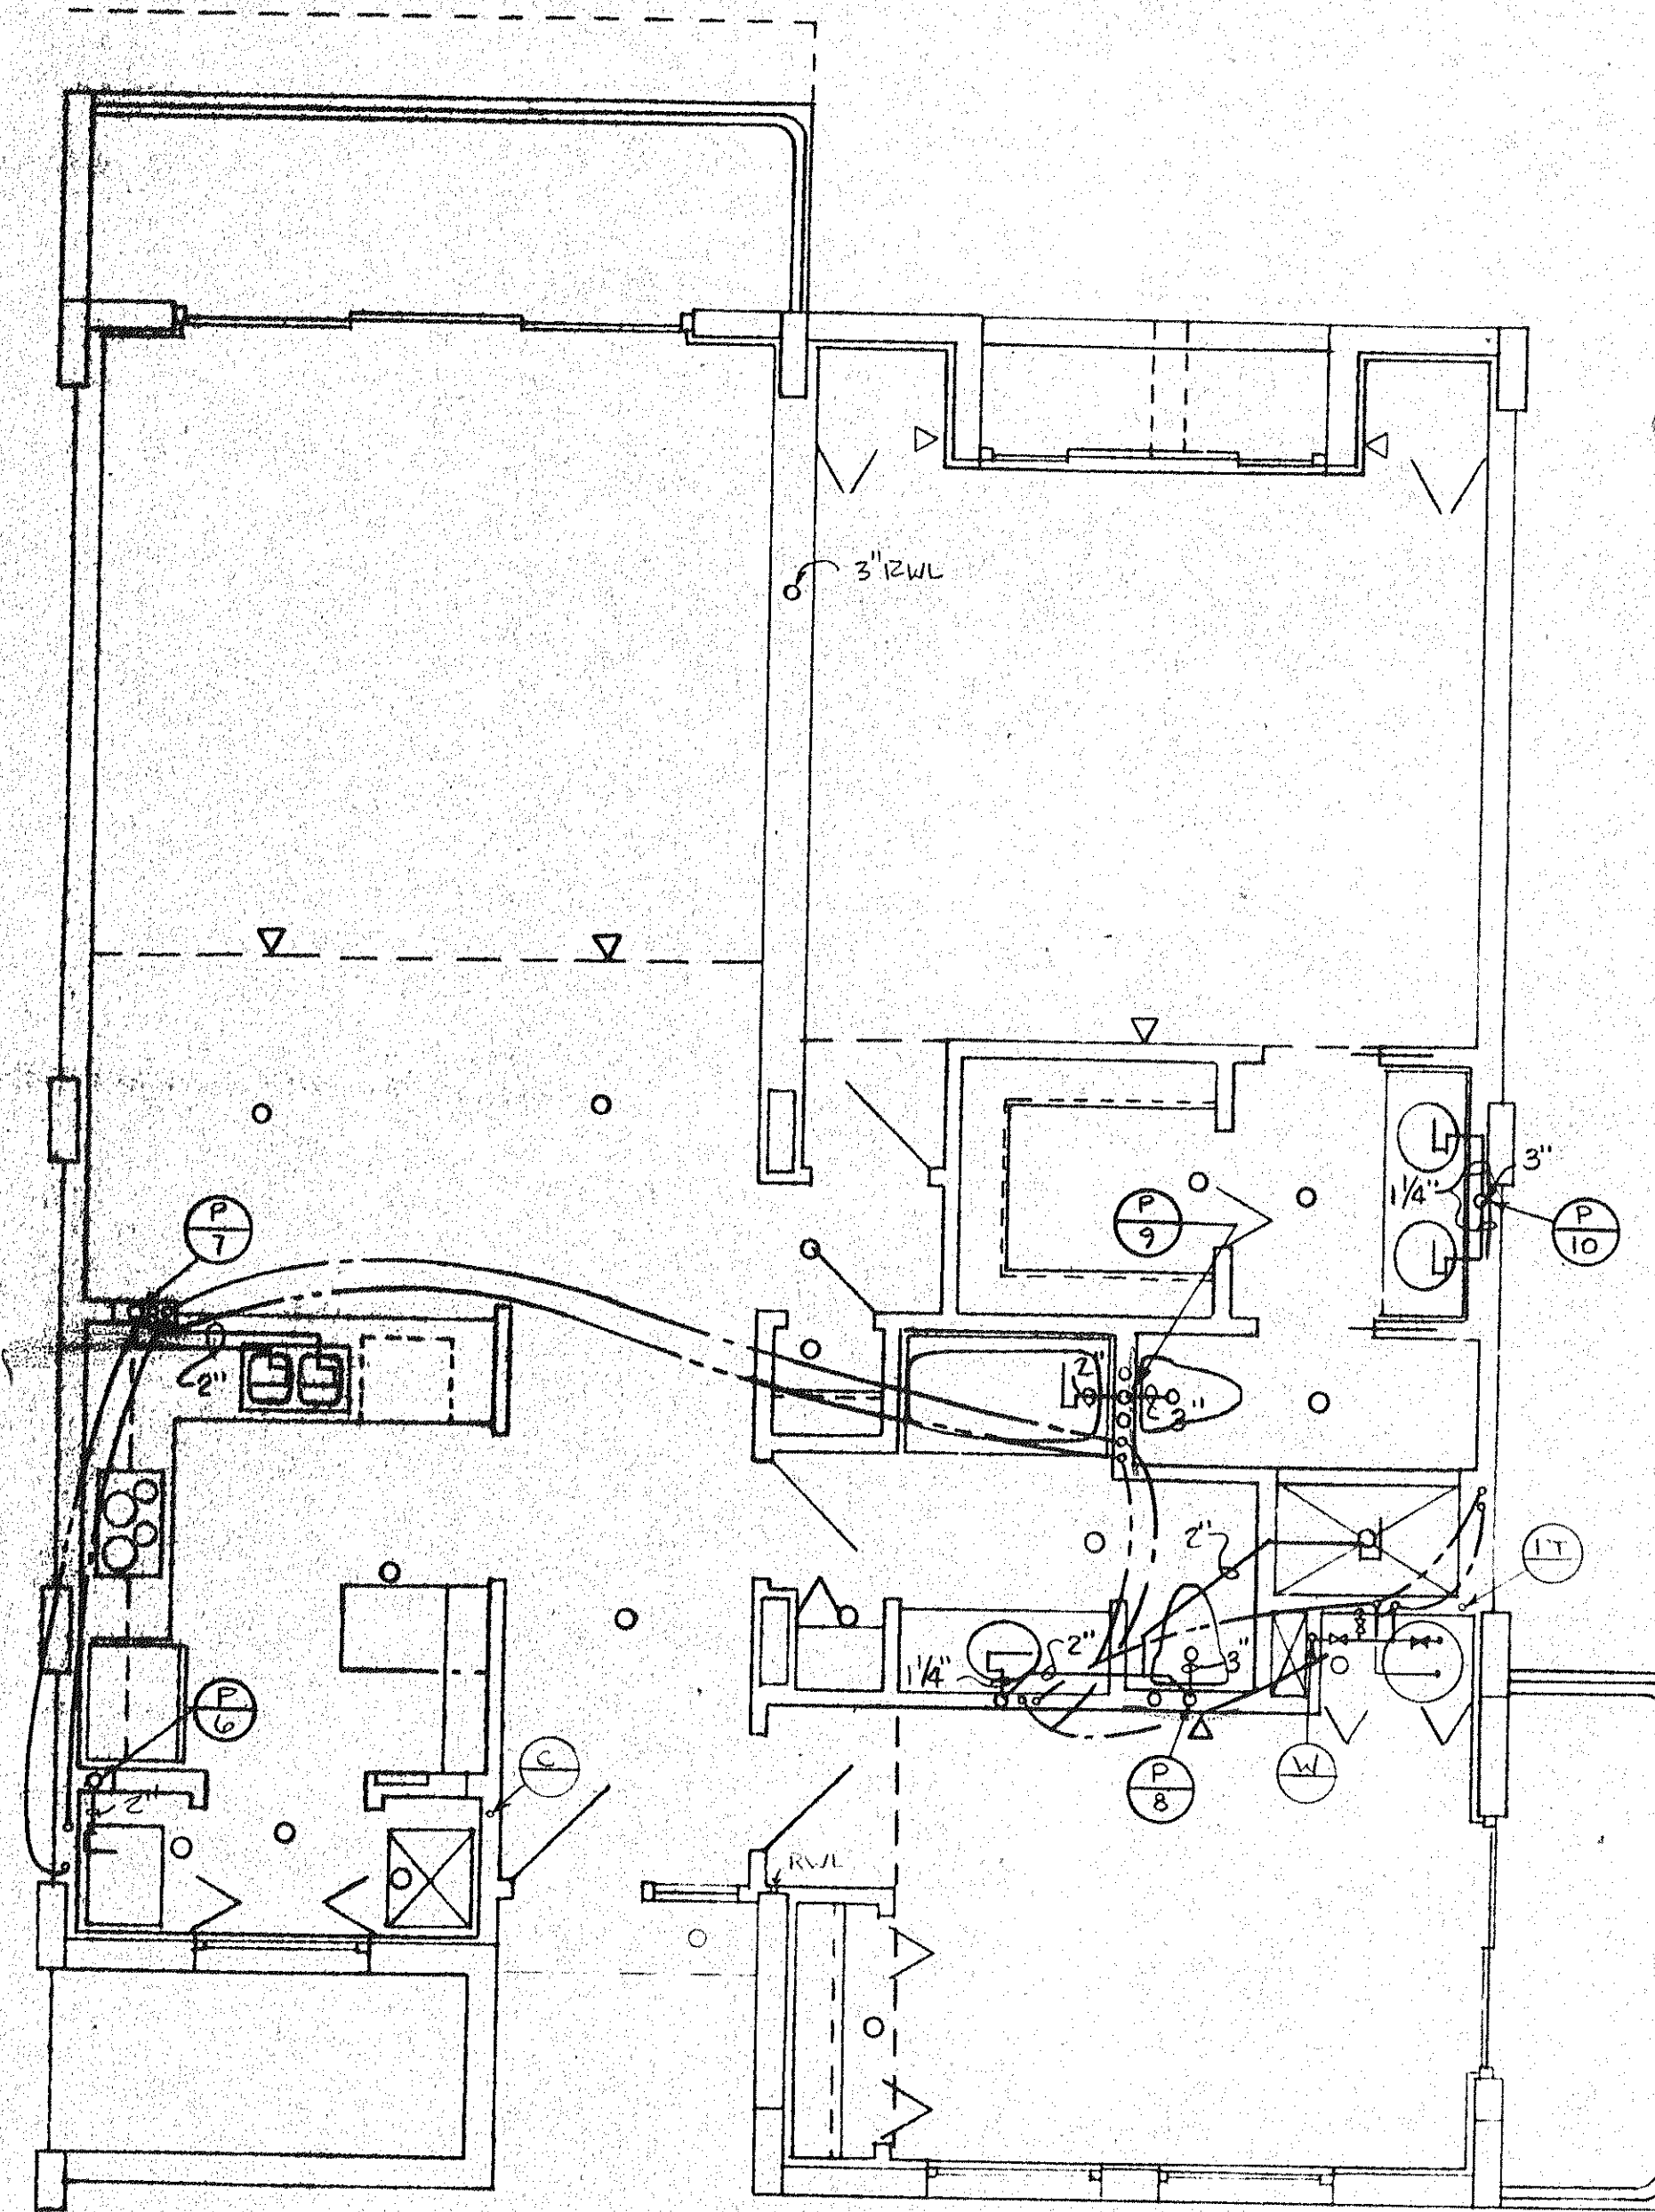

**UNIT 'B' RIGHT PLUMBING PLAN**

scale: 1/4" = 1'-0"

ISSUE	4-1
REV	