


UNIT 'C' - LEFT PLUMBING PLAN

Scale: 1/8" = 1'-0"

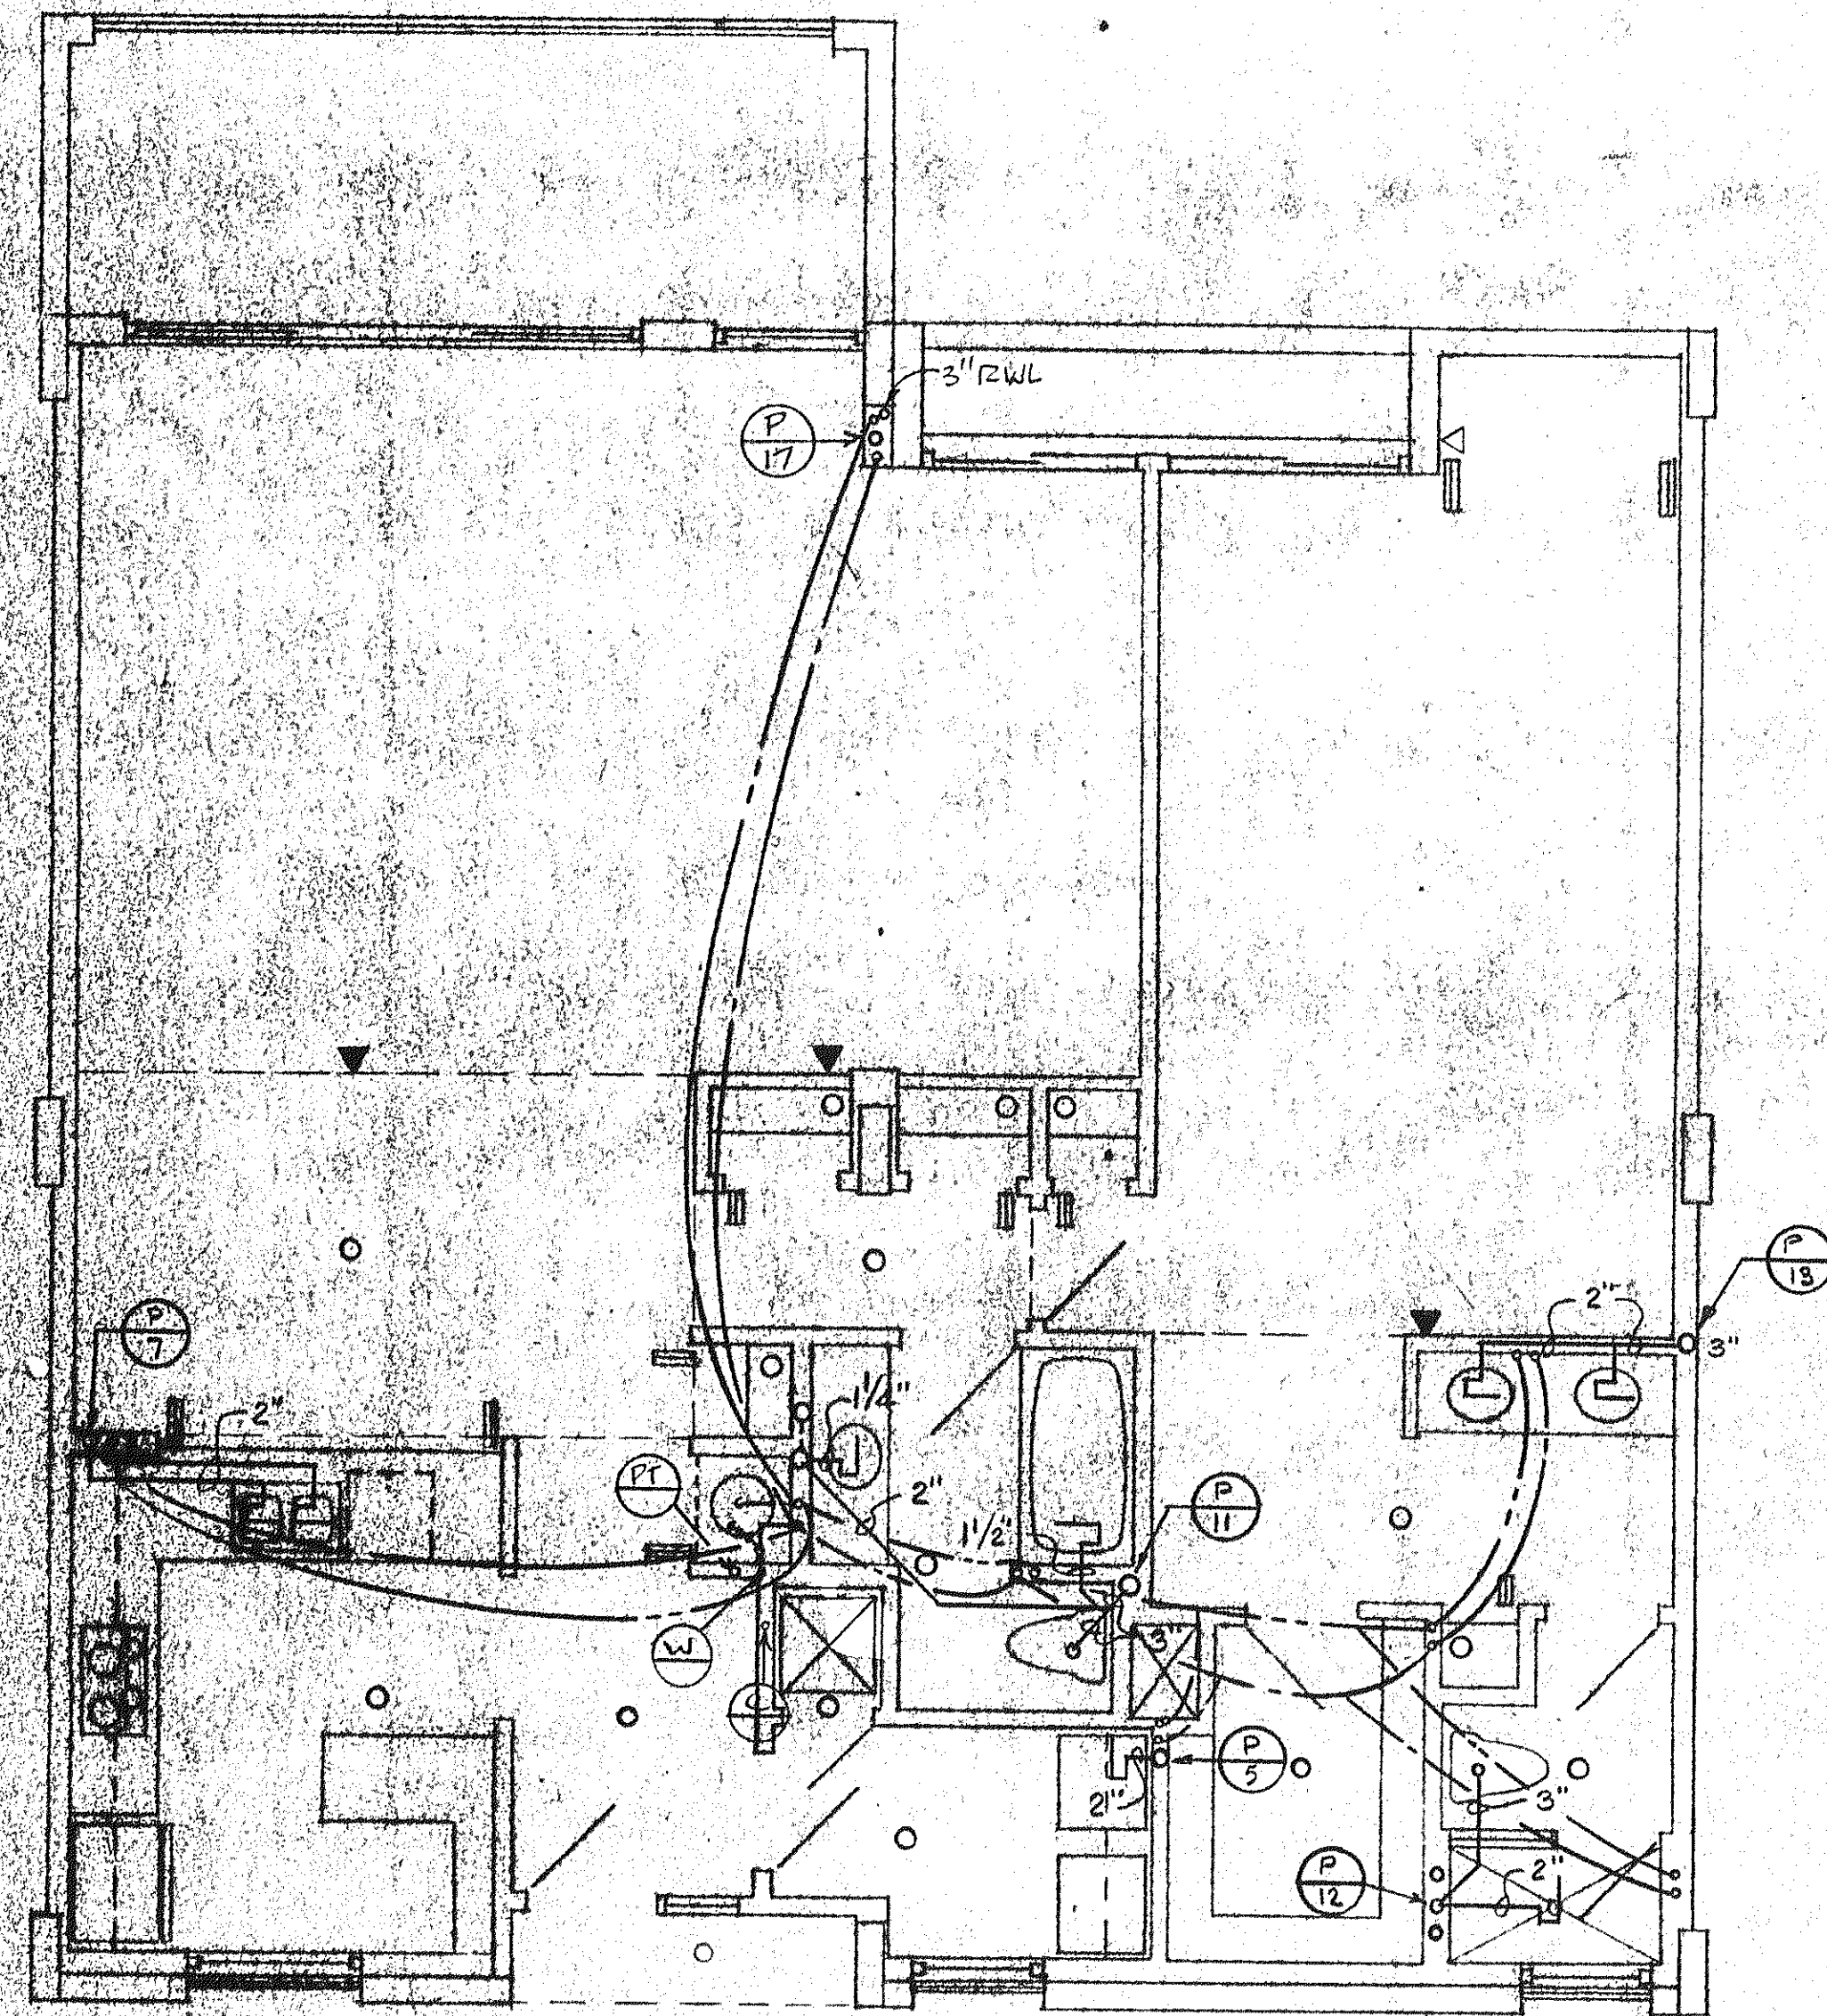

UNIT PLUMBING PLAN

ISSUE NO.	1
REVISED	
SHEET	P-7
BUILDING	BLDG. 2