
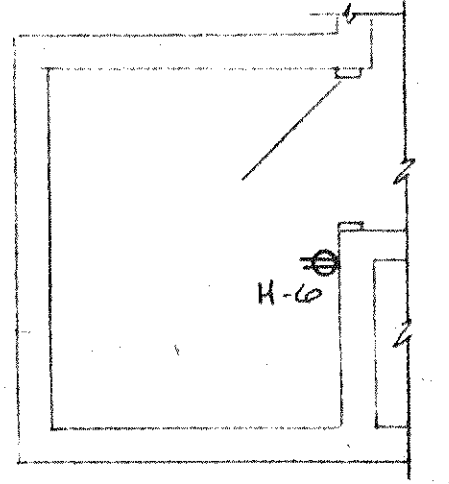
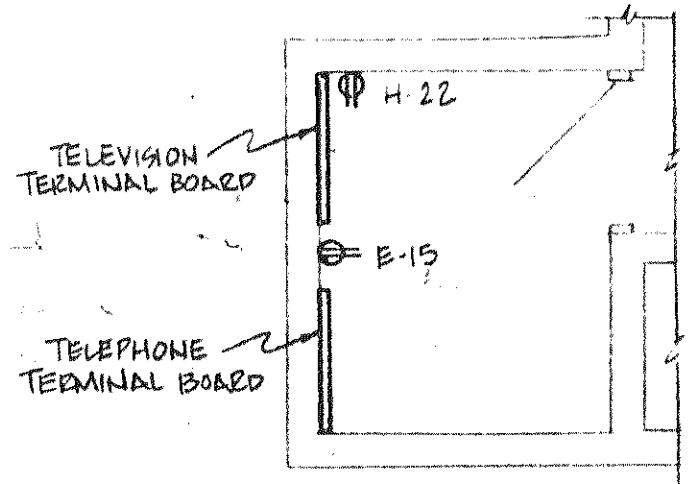


ELECTRICAL PLAN - PUMP
 SYSTEM FOR PROJECT
 CORNER LOP & RET
 11/11/57

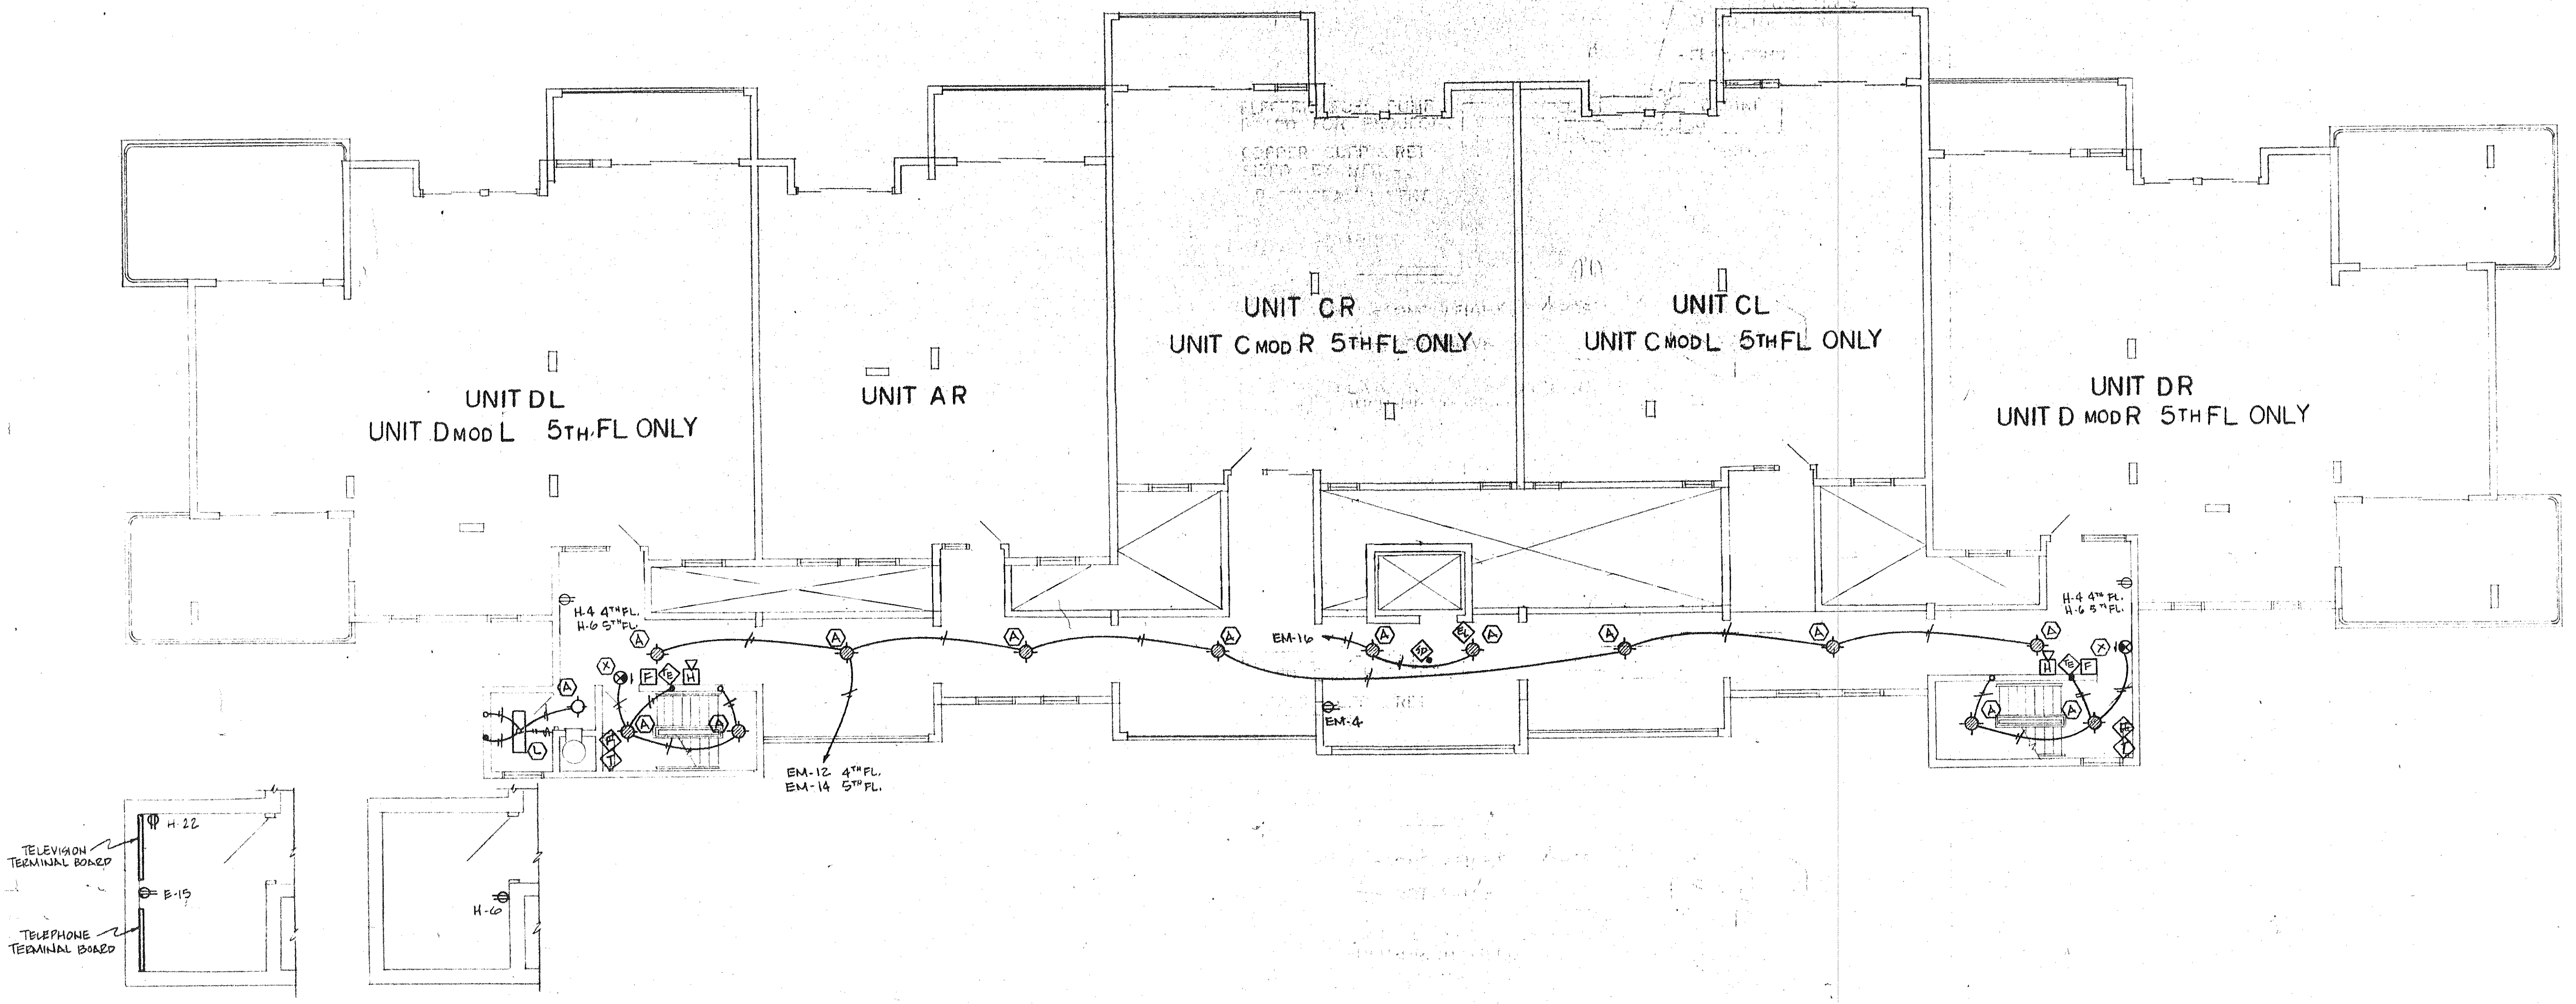

FOURTH FLOOR
TEL. & T.V. CLOSET
 N.T.S.

FIFTH FLOOR
STORE ROOM
 N.T.S.

BUILDING 3 - FOURTH & FIFTH FLOOR ELECTRICAL PLAN
 scale 1/8" = 1'-0"

ELECTRICAL PLAN - PUMP
 SYSTEM FOR PROJECT
 CORNER LOP & RET
 11/11/57

SUNSET BEACH
 OF LONG BEACH KEY

ARYDA CORPORATION · EDWARD J. SEIBERT, AIA, ARCHITECT & PLANNER FOR THE SWA GROUP
 BRASHAM, KUHNIS, DEBAY, CONSULTING ENGINEERS · OLSEN, WHITE & ASSOCIATES, STRUCTURAL ENGINEERS · BENNETT & BISHOP, INC., CONSULTING ENGINEERS & SURVEYORS

| | |
|---------|------------|
| ISSUED | 1-1-58 |
| REVISED | |
| SHEET | E-5 |
| BDDG. 3 | OF |