


UNIT 'A' : LEFT ELECTRICAL PLAN
 scale 1/4" = 1'-0"

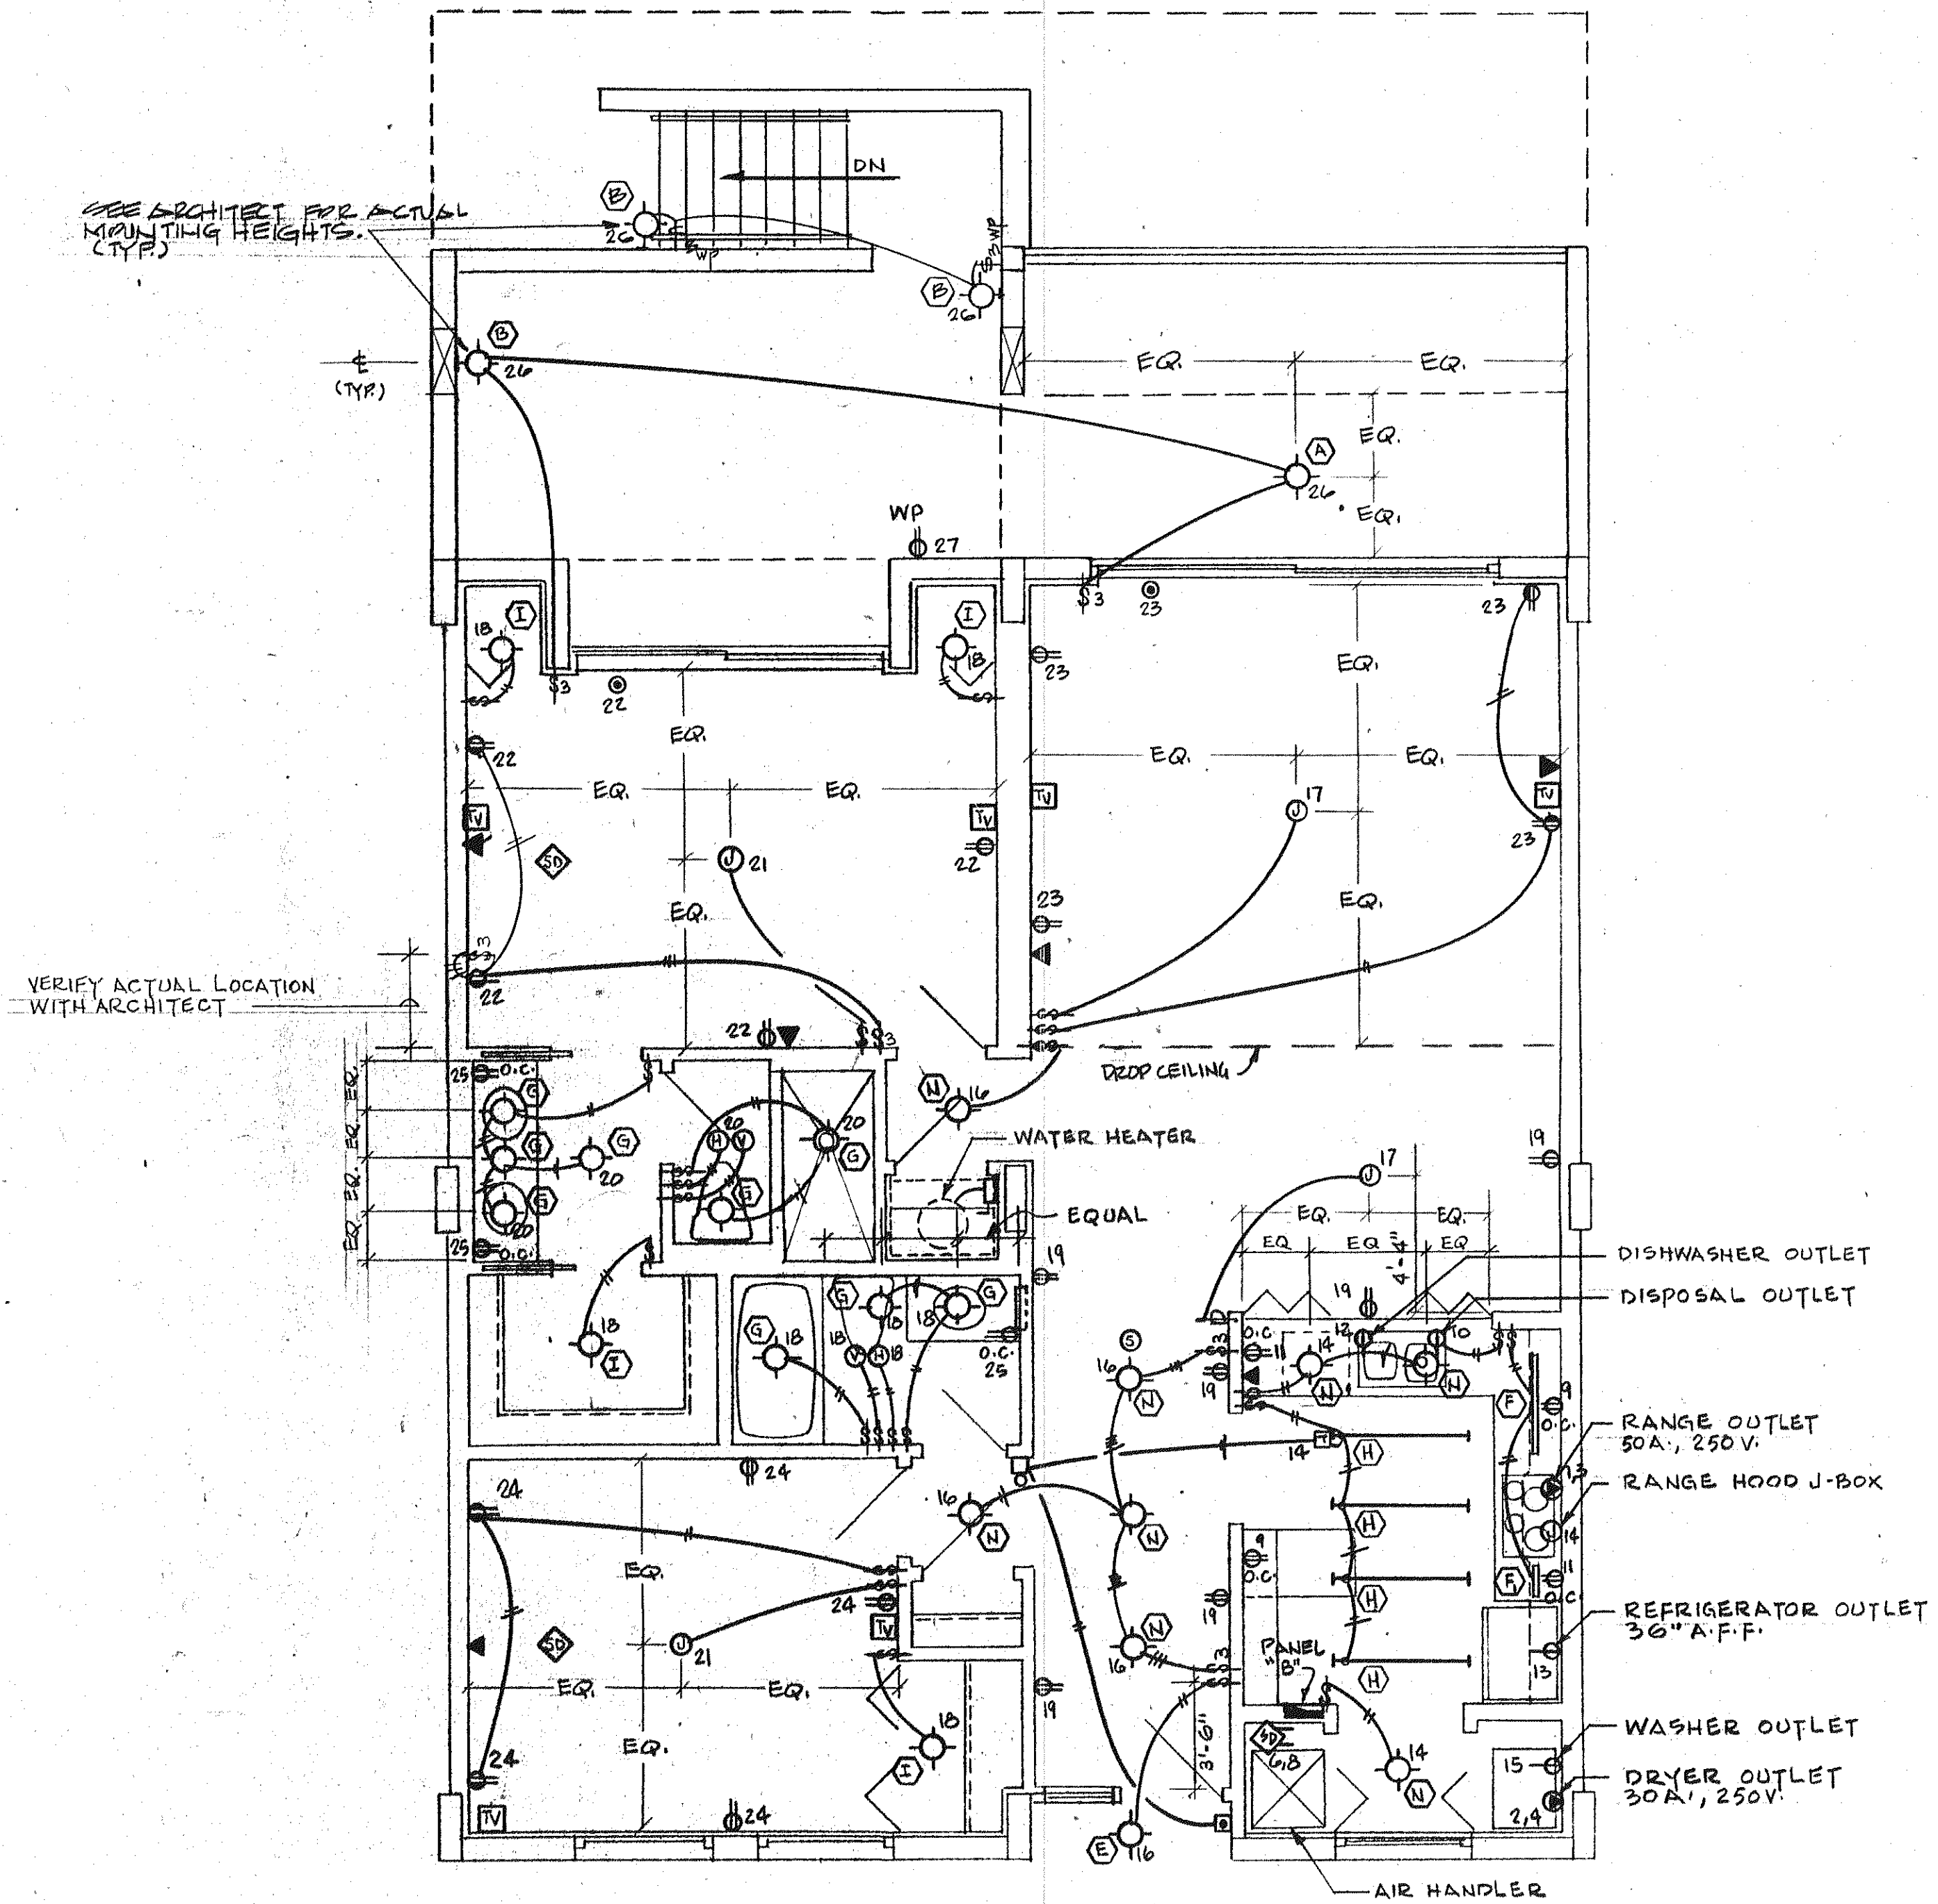

UNIT 'A' : RIGHT ELECTRICAL PLAN
 scale 1/4" = 1'-0"

ISSUED	4.1.82
REVISED	
SHEET	E-8
OF	