


UNIT "C" LEFT

scale: 1/4" = 1'-0"

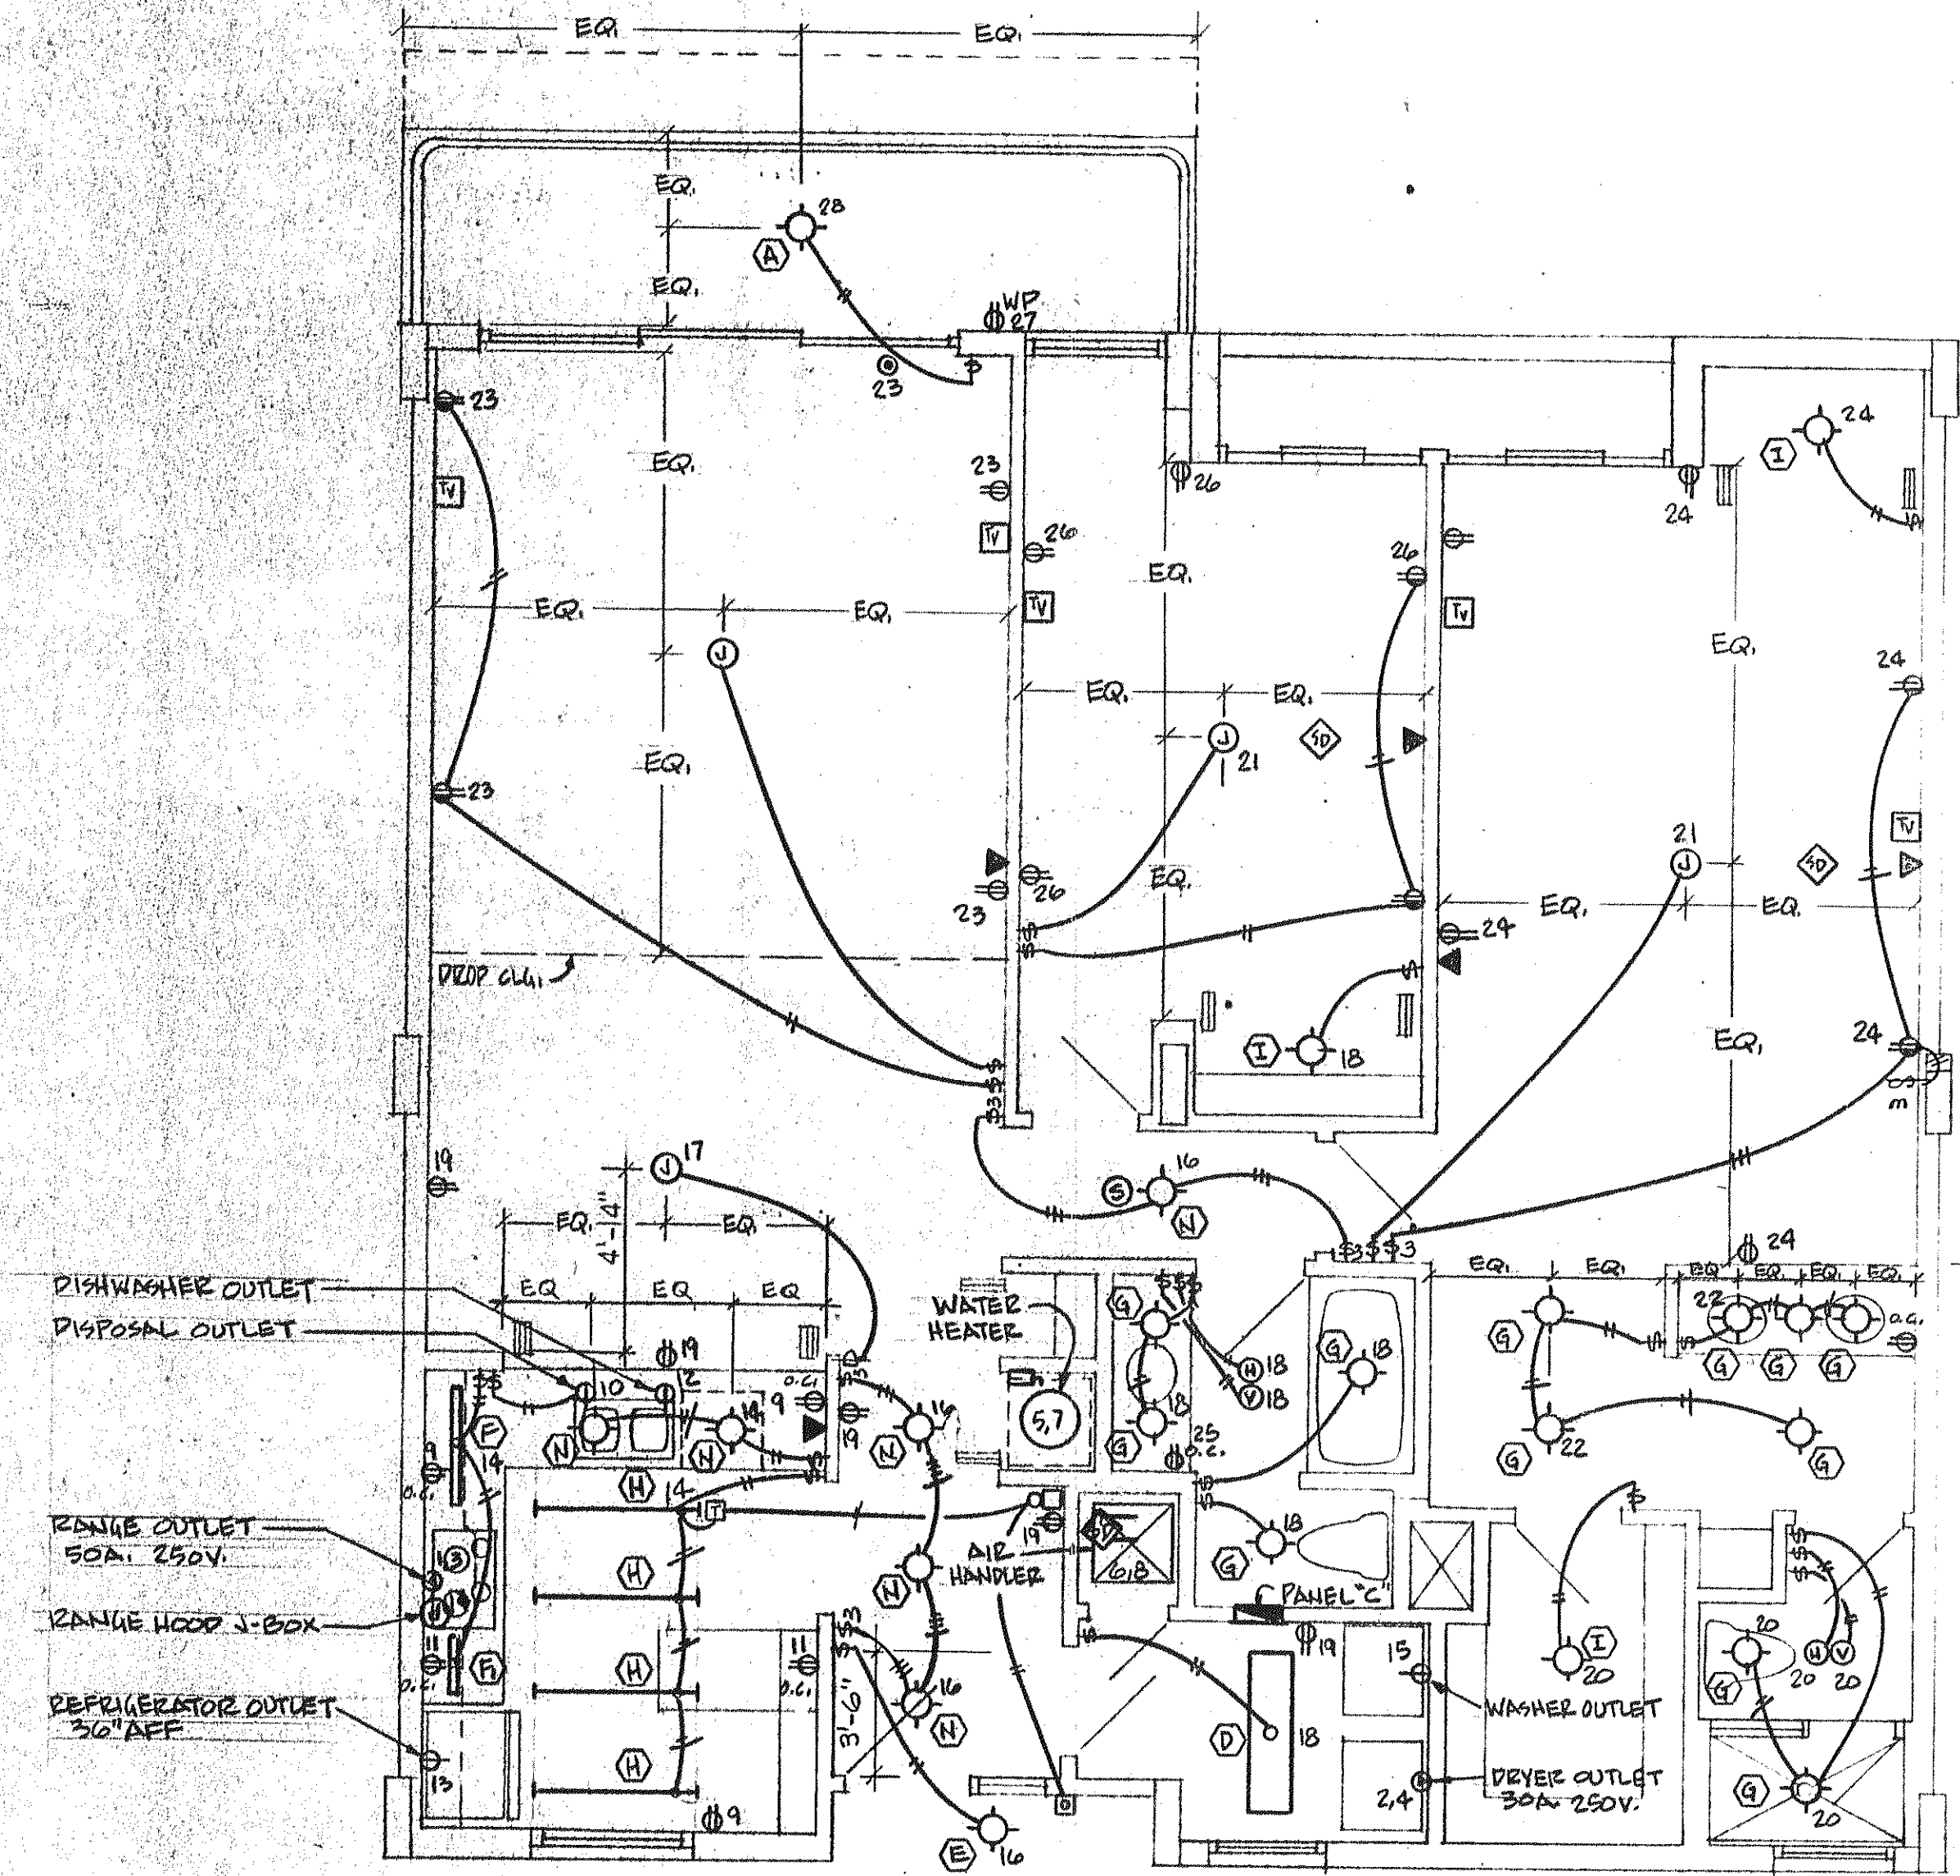

UNIT "C" RIGHT - ELECTRICAL PLAN

scale 1/4" = 1'-0"

VERIFY ACTUAL LOCATION WITH ARCHITECT (TYP.)