


UNIT "C" - LEFT

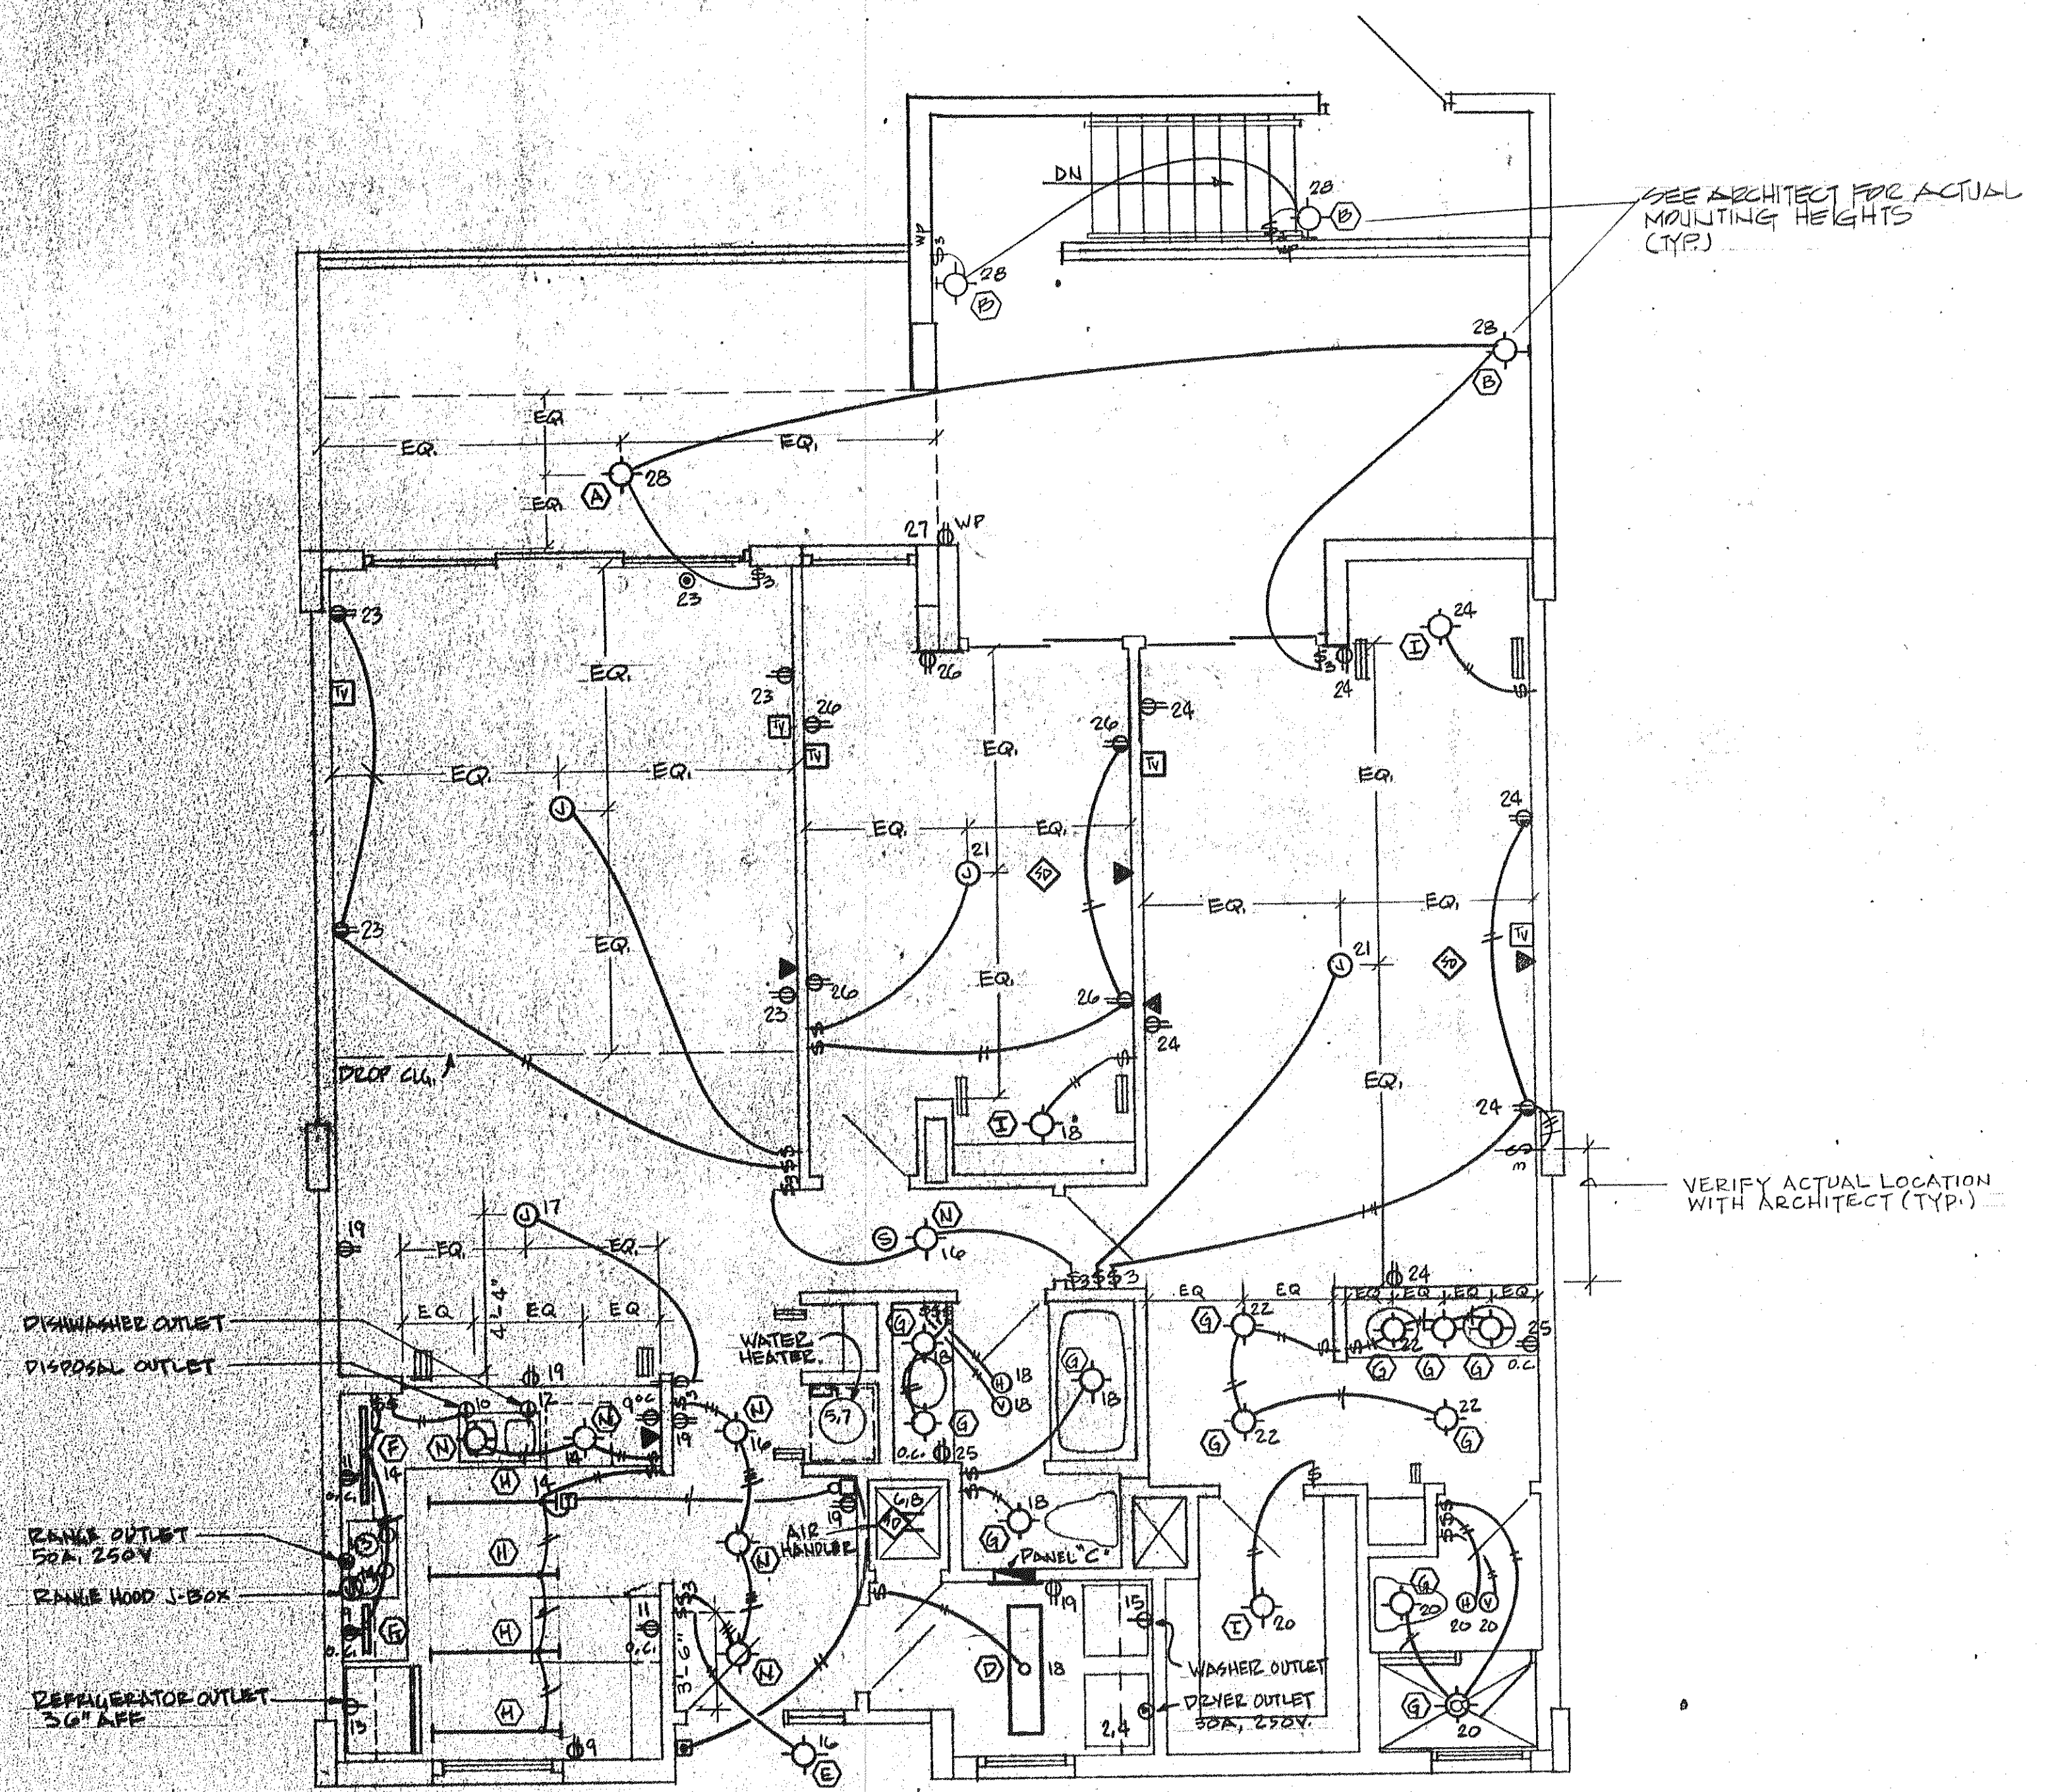

UNIT "C" - RIGHT - ELECTRICAL PLAN

scale 1/4" = 1'-0"

ISSUED	4/1/22
REVISED	
SHEET	E-10
OF	