


UNIT "C" MOD LEFT
 scale 1/4" = 1'-0"

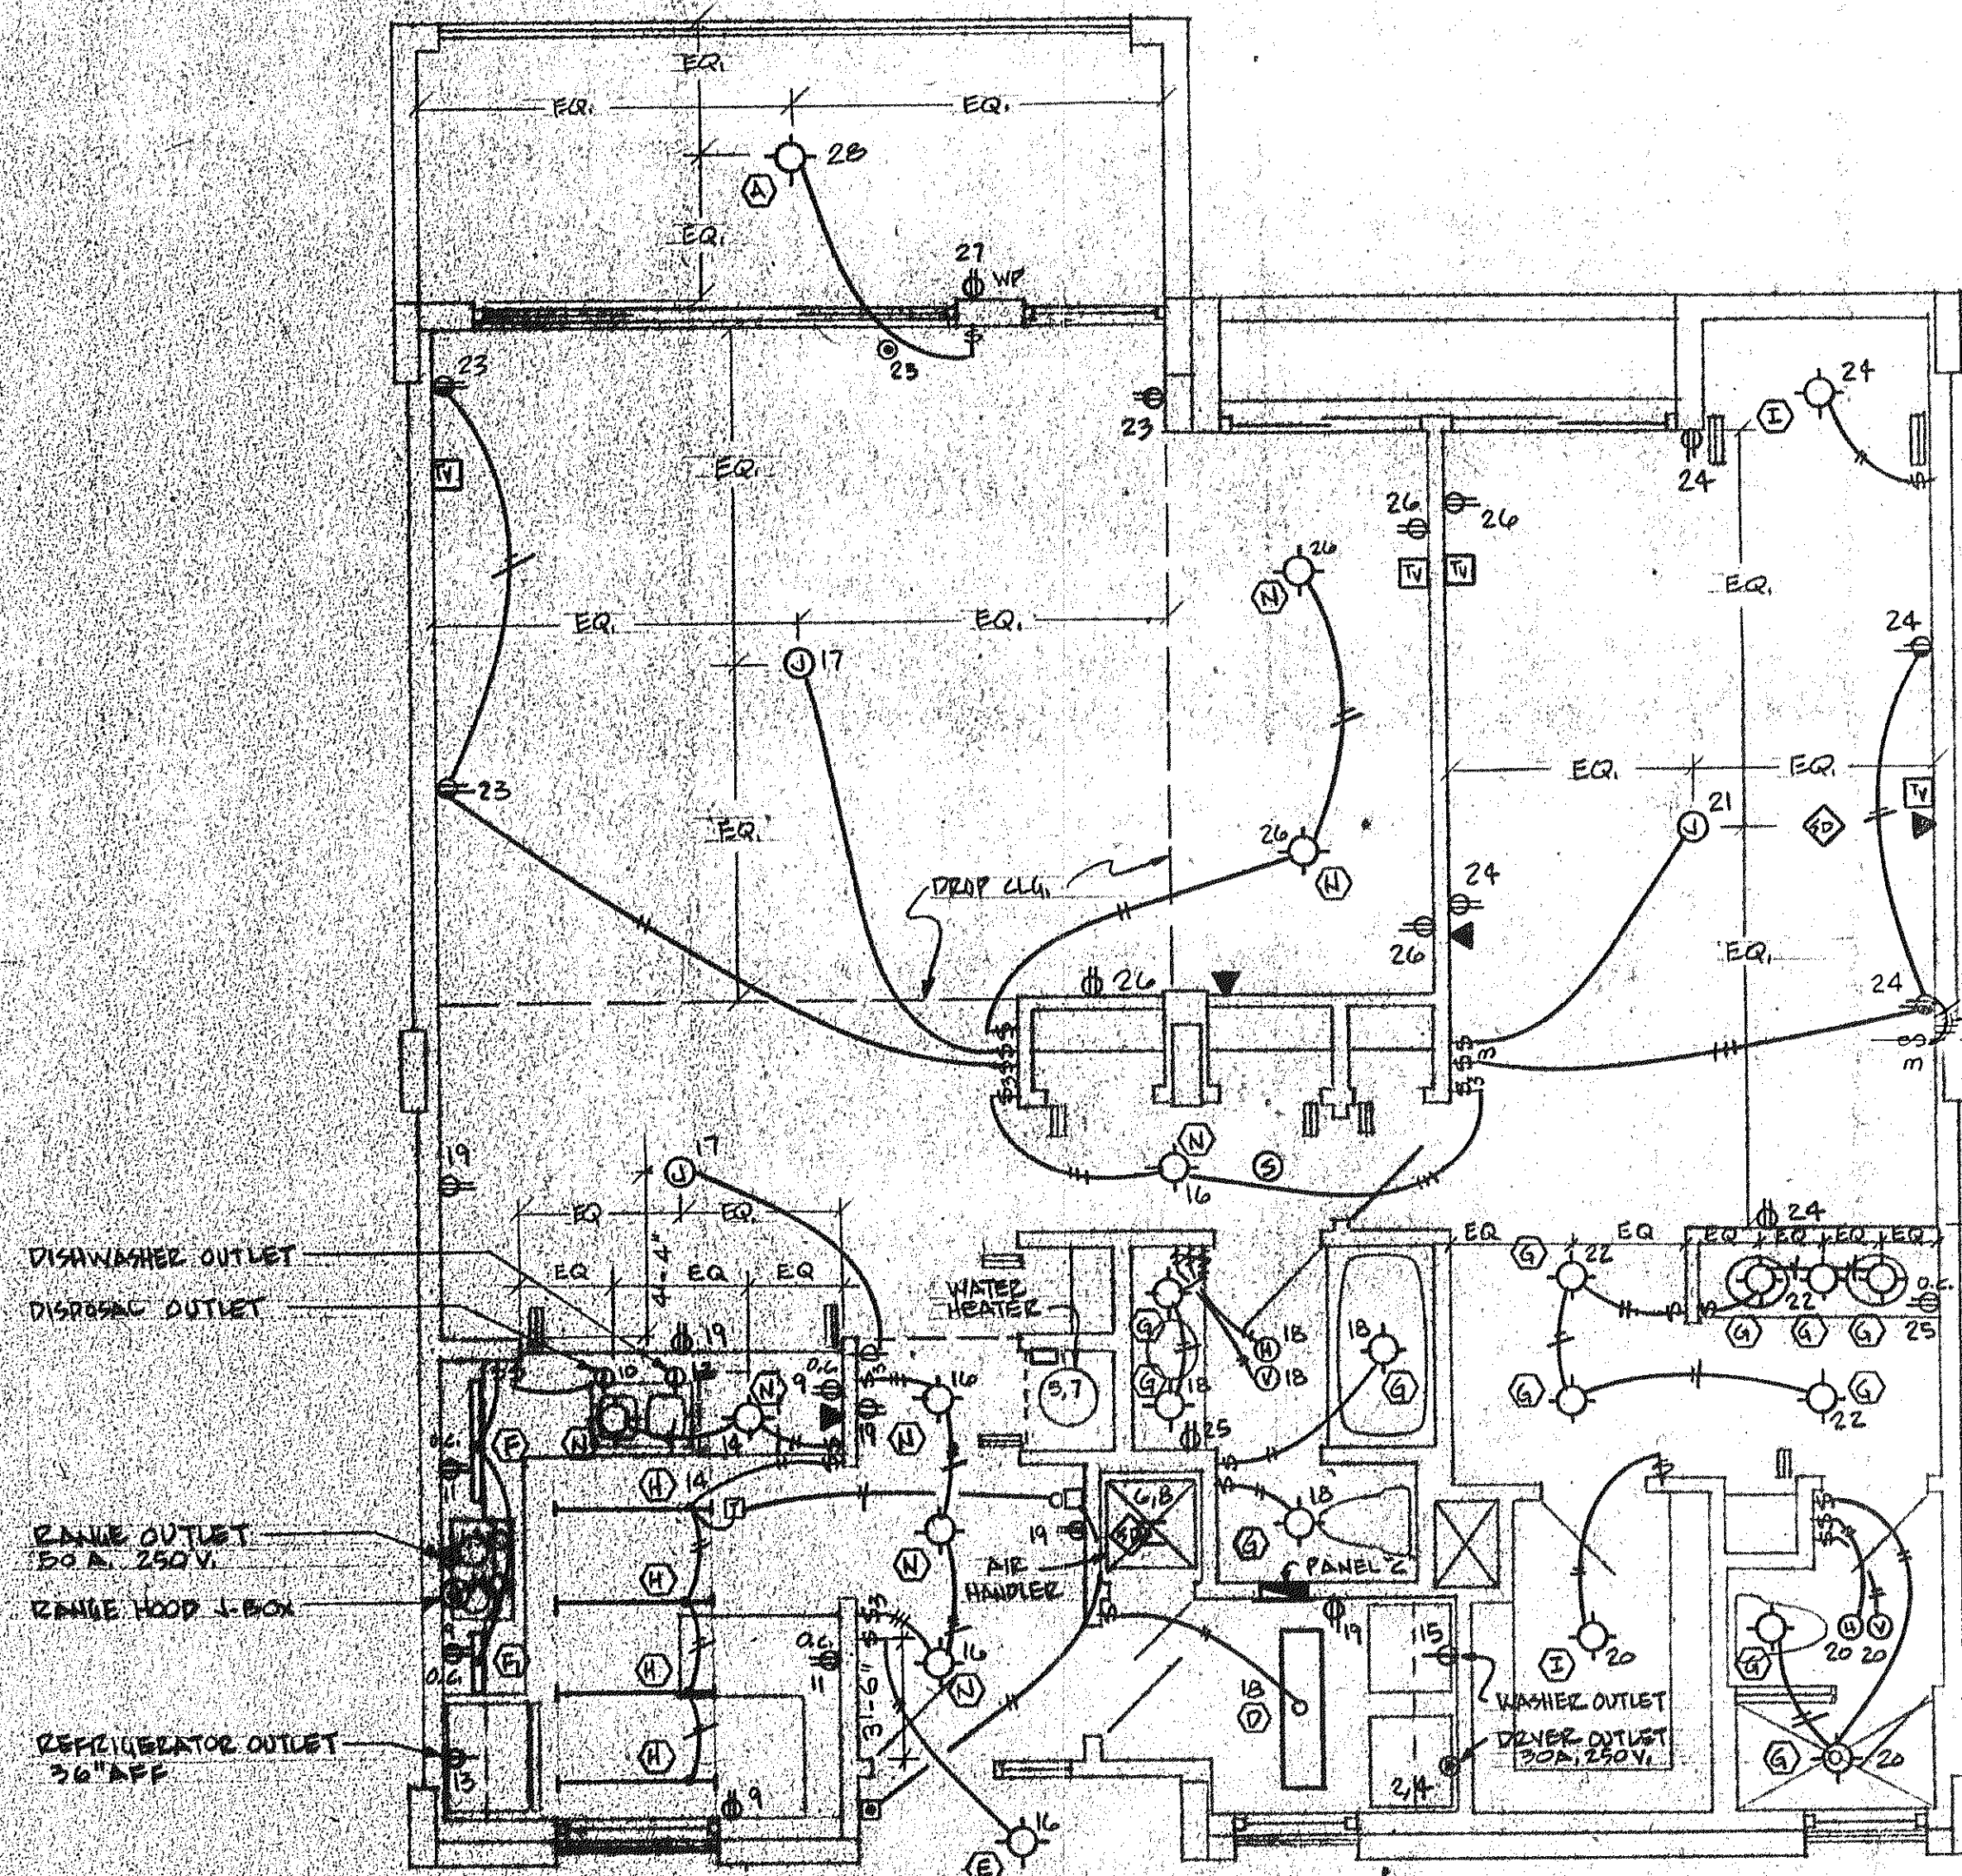

VERIFY ACTUAL LOCATION WITH ARCHITECT (TYP.)

UNIT "C" MOD RIGHT - ELECTRICAL PLAN
 scale 1/4" = 1'-0"

ISSUED	4.11.80
REVISED	
SHEET	E-11
OF	