


**UNIT 'C' LEFT PLUMBING PLAN**

SCALE: 1/8" = 1'-0"

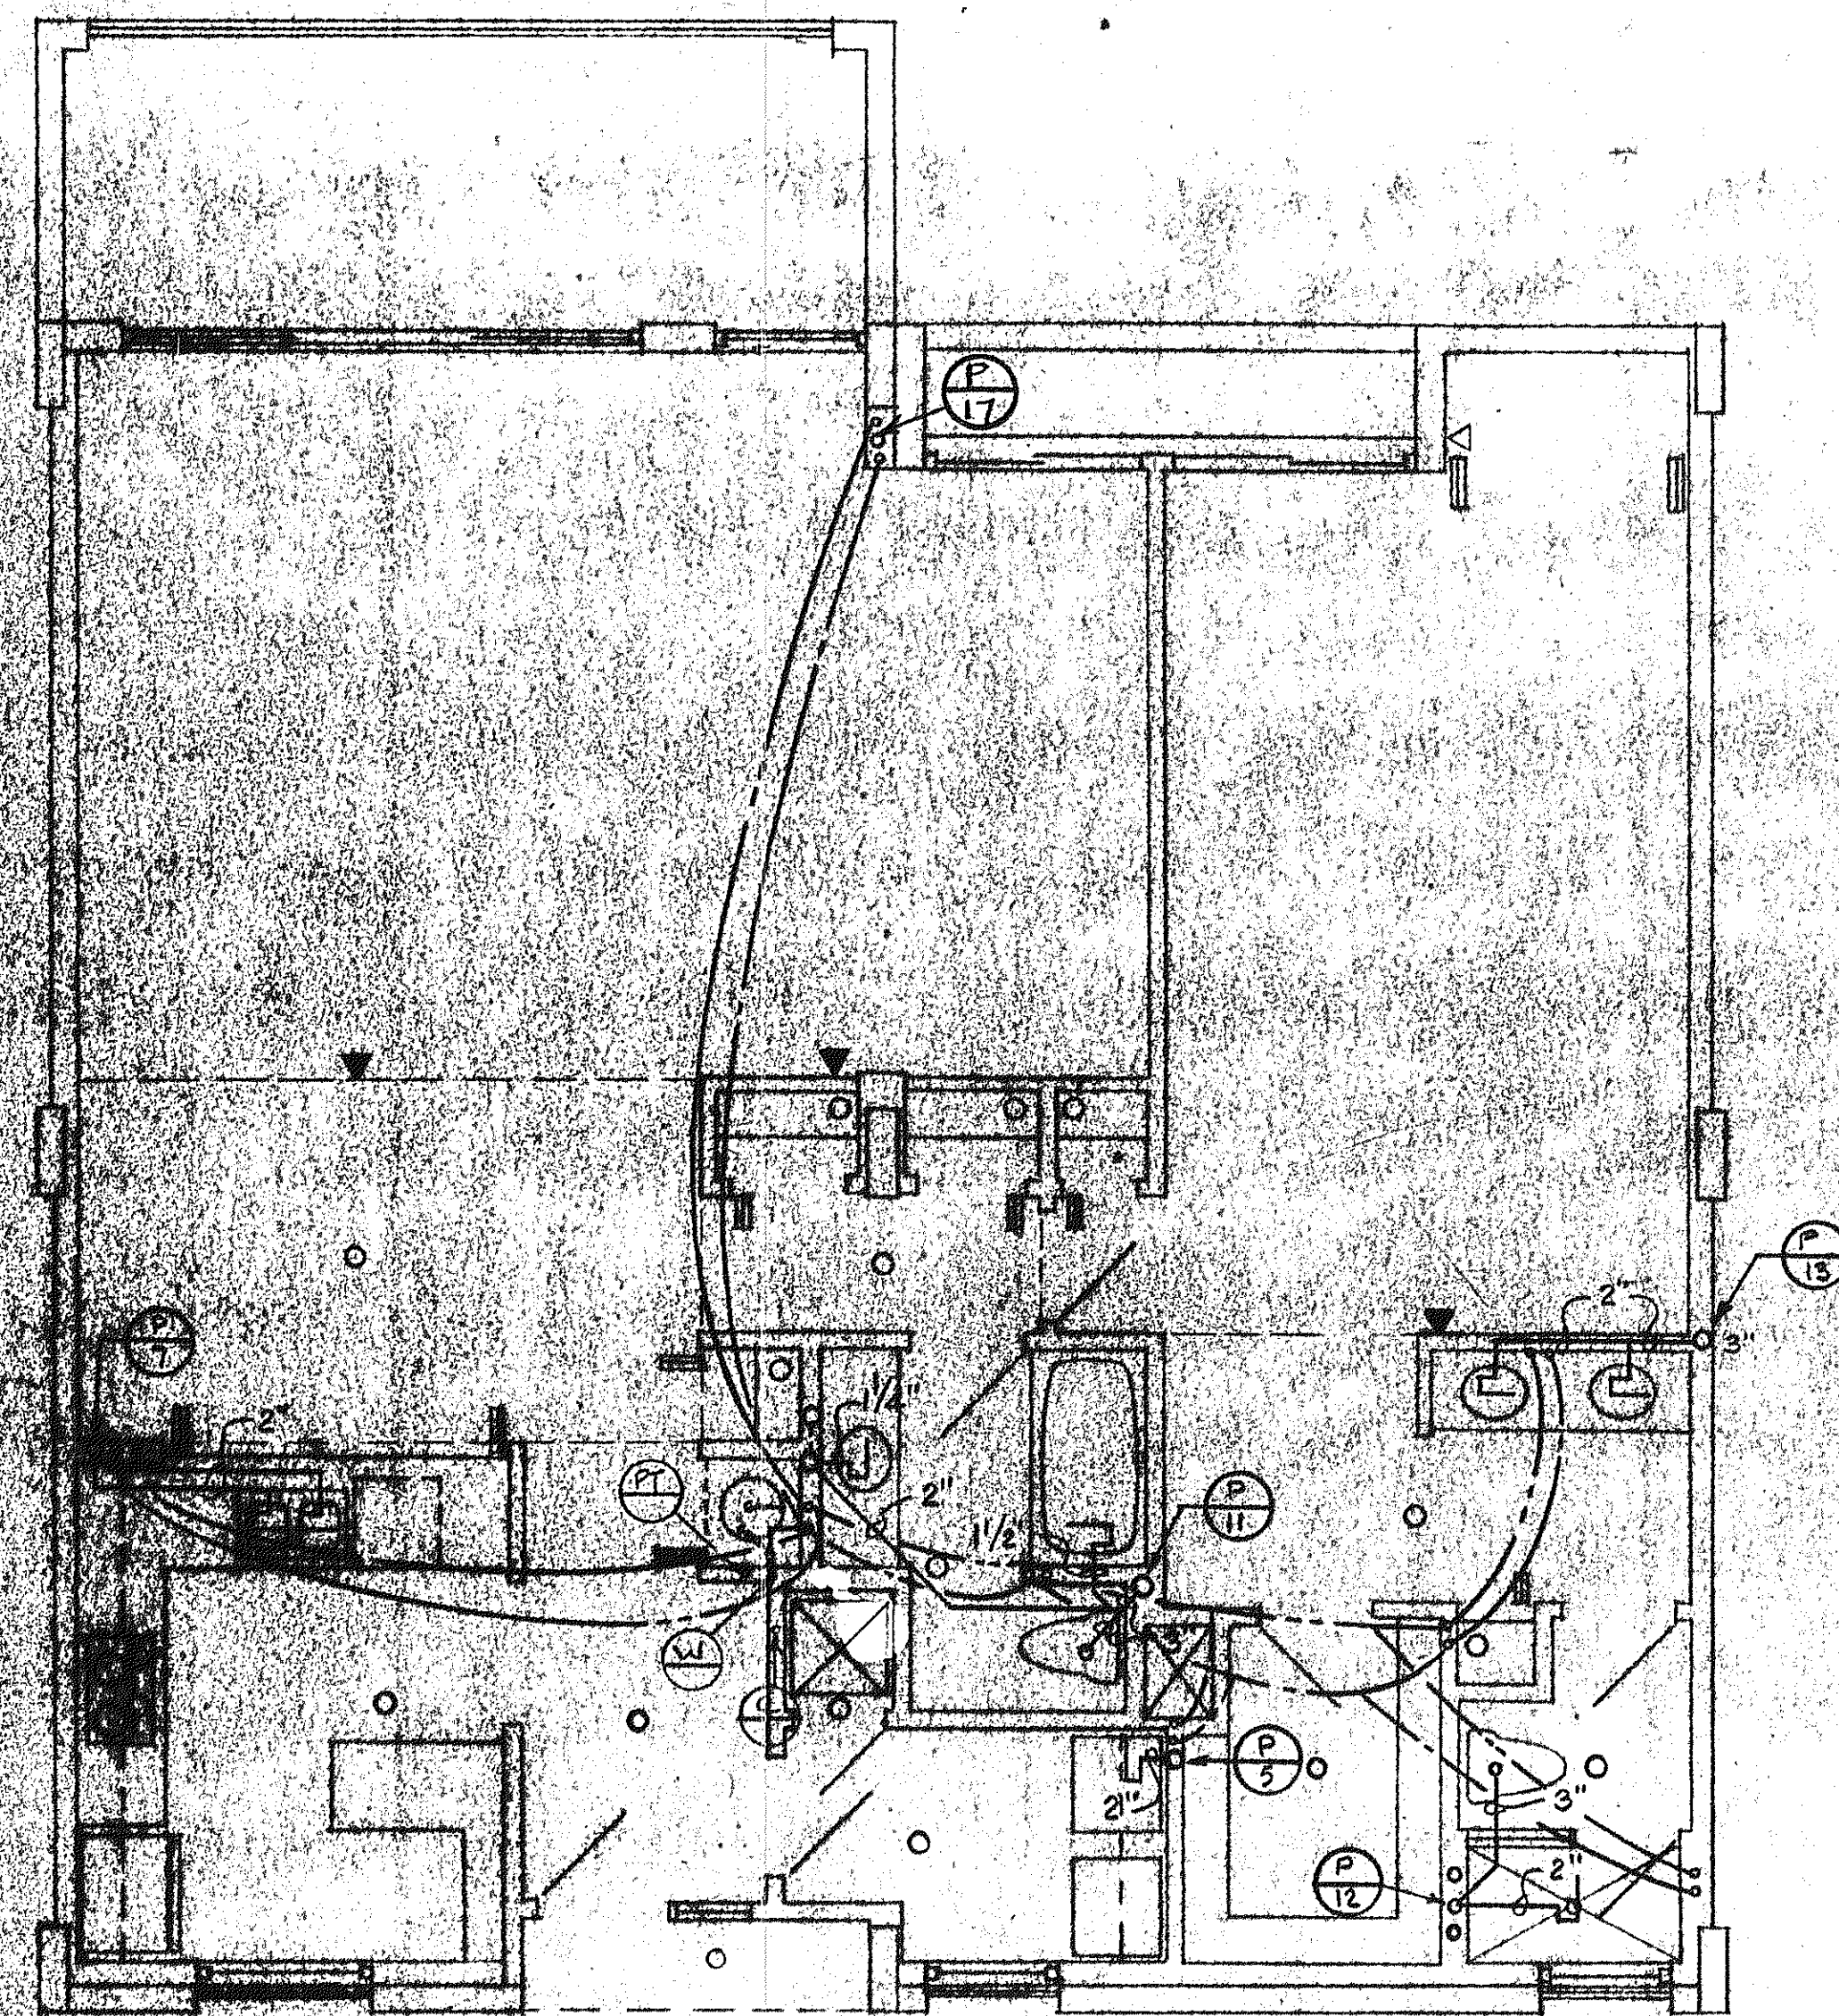

**UNIT PLUMBING PLAN**

ISSUED	4-15-00
REVISED	
SHEET	P-5
BLDG.	3