


UNIT "D" MOD. LEFT PLUMBING PLAN
 scale 1/4" = 1'-0"

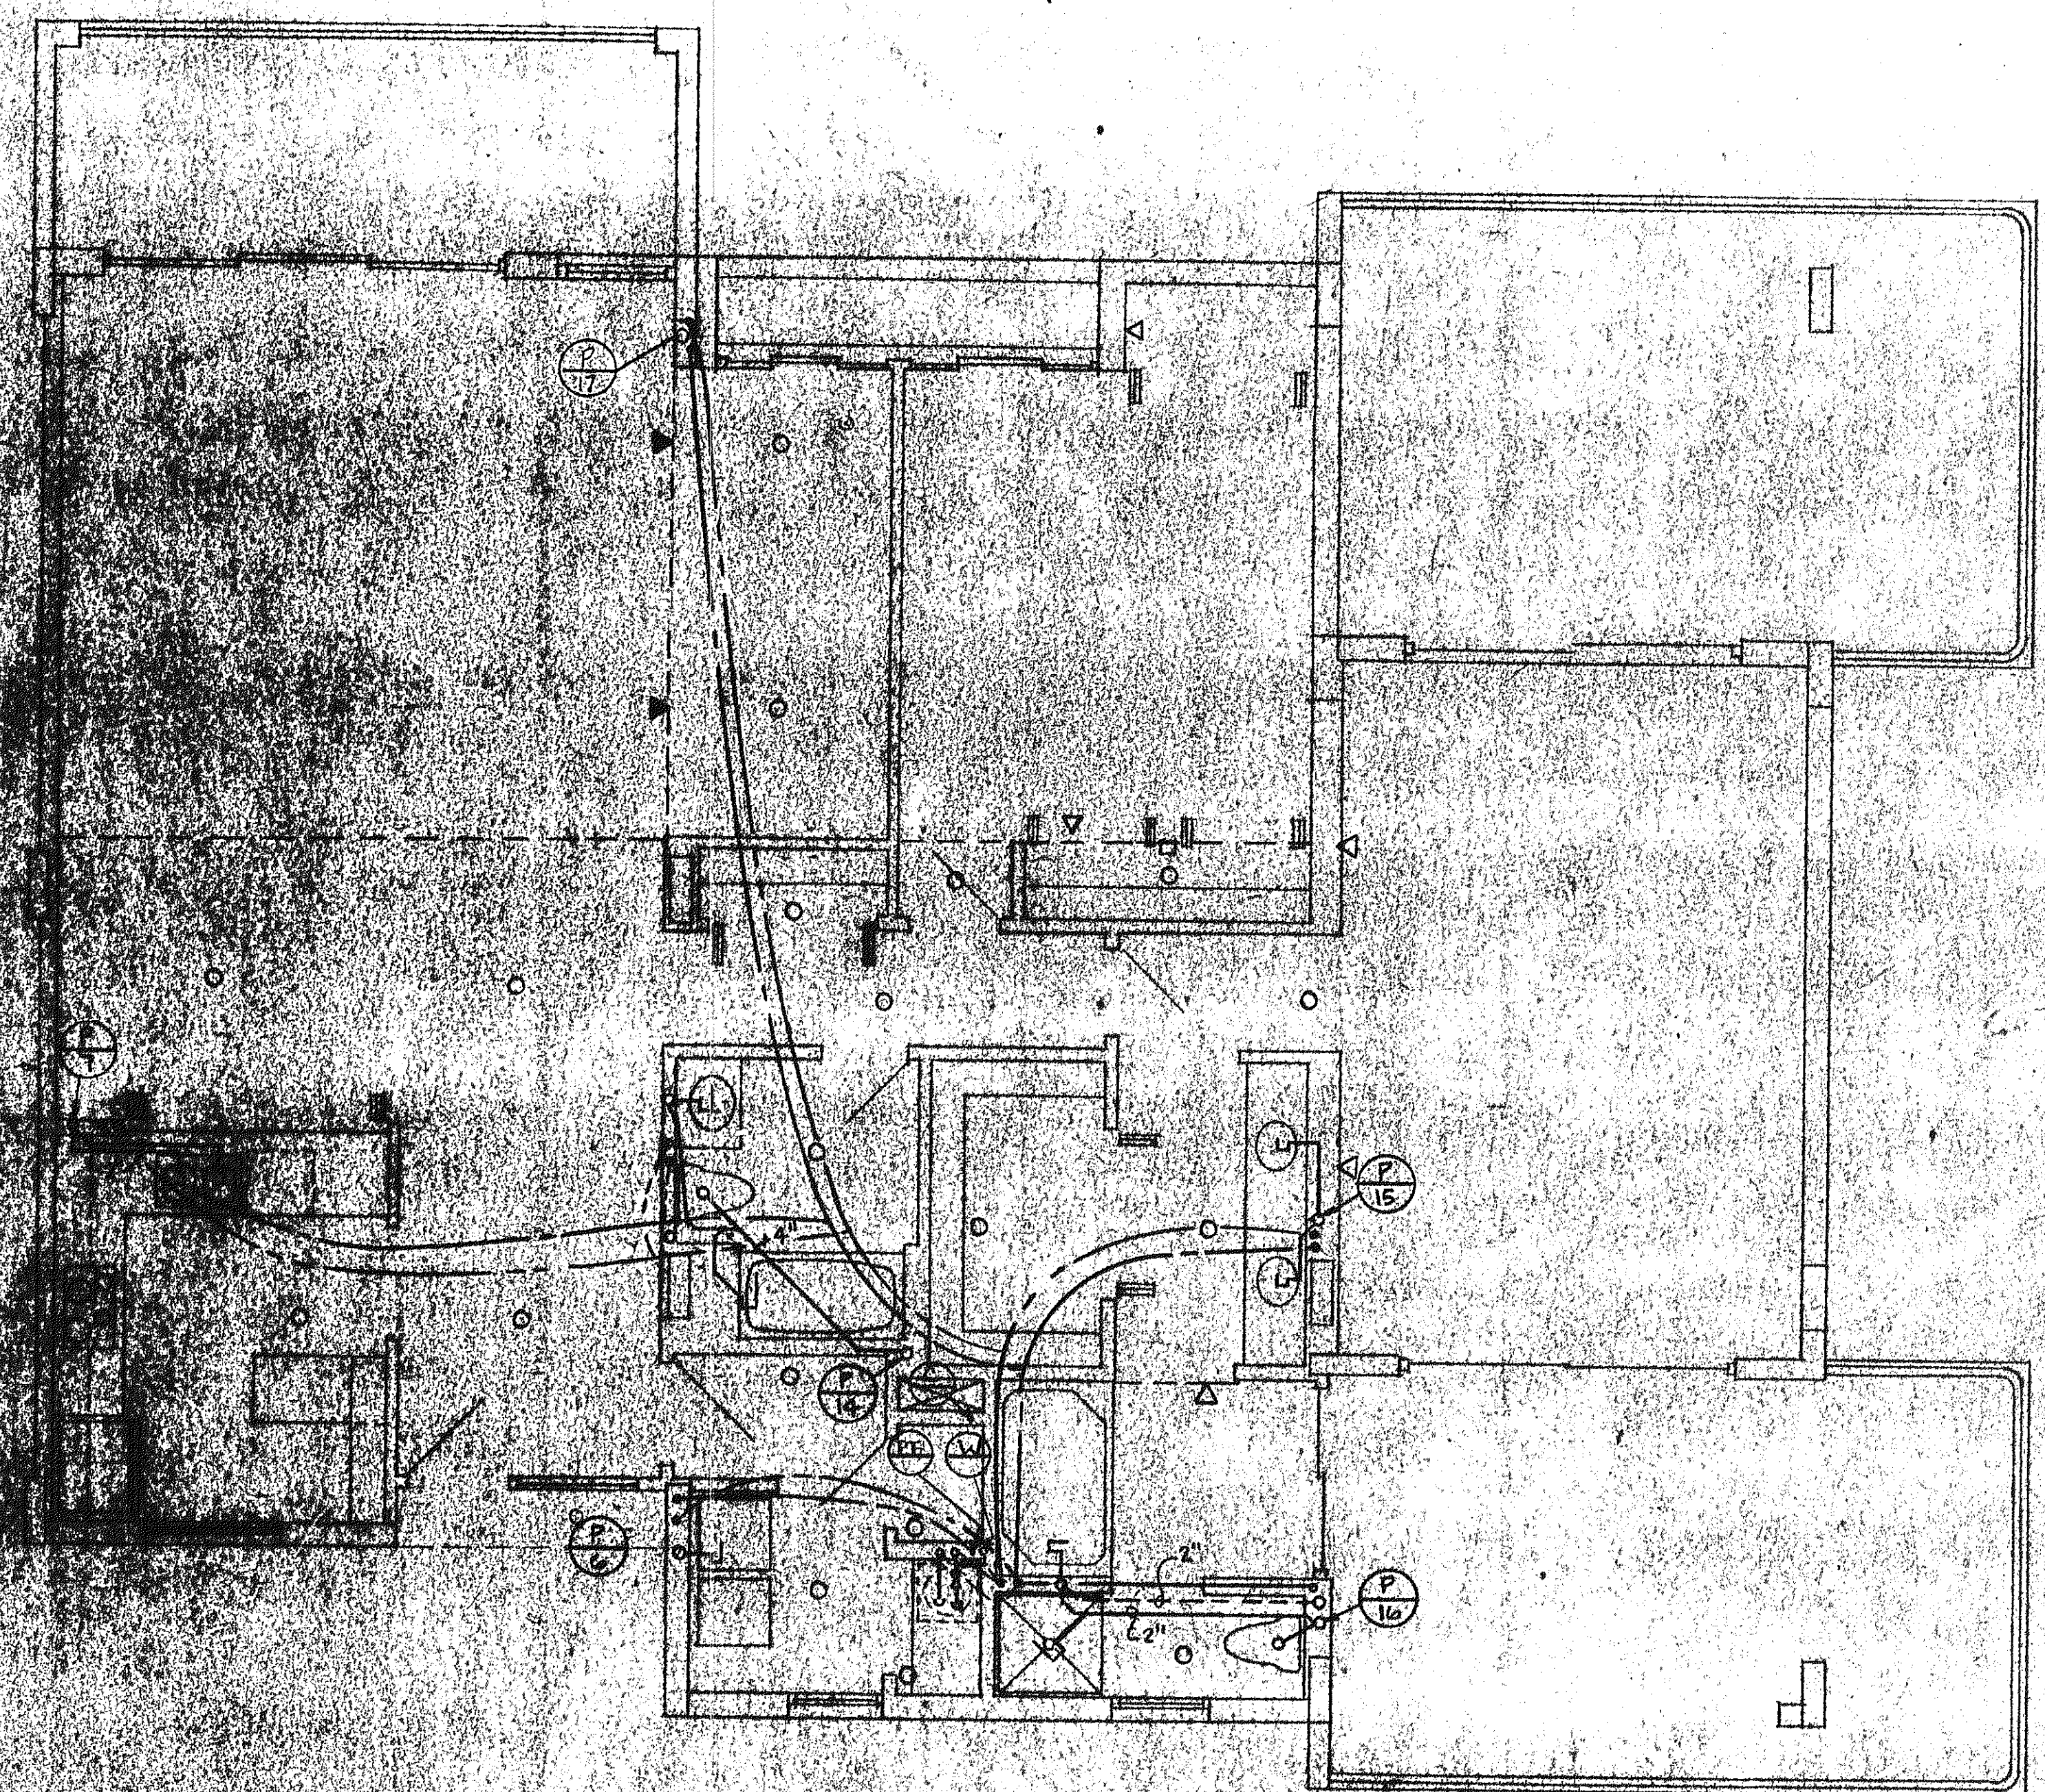

UNIT "D" MOD. RIGHT - PLUMBING PLAN
 scale 1/4" = 1'-0"

ARVIDA CORPORATION, EDWARD J. SEIBERT, AIA, ARCHITECT & PLANNER, P.A., THE SAMA GROUP
 BRABHAM, KLUMBS, DEBAY CONSULTING ENGINEERS, OLSEN, WHITE & ASSOCIATES, STRUCTURAL ENGINEERS

| | |
|---------|------------|
| ISSUED | 4-1-81 |
| REVISED | |
| | |
| | |
| SHEET | P-8 |
| BLDG. | 3 |