
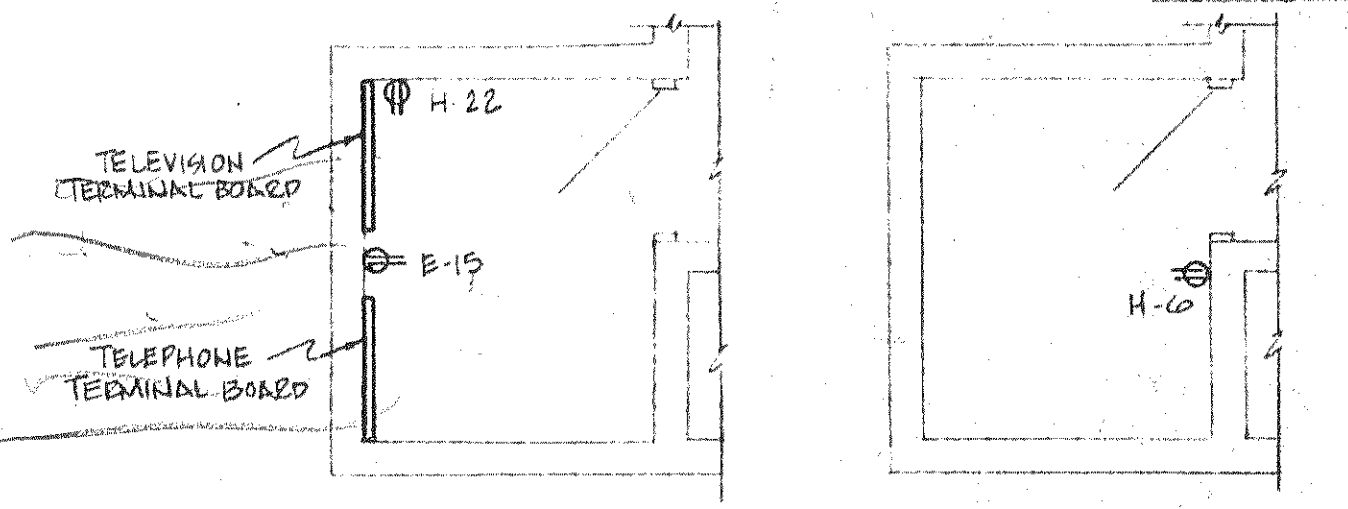


ELECTRICAL PLAN  
 FOR THE PROJECT  
 COMPLETE LAYOUT  
 DATE: 1-22-82

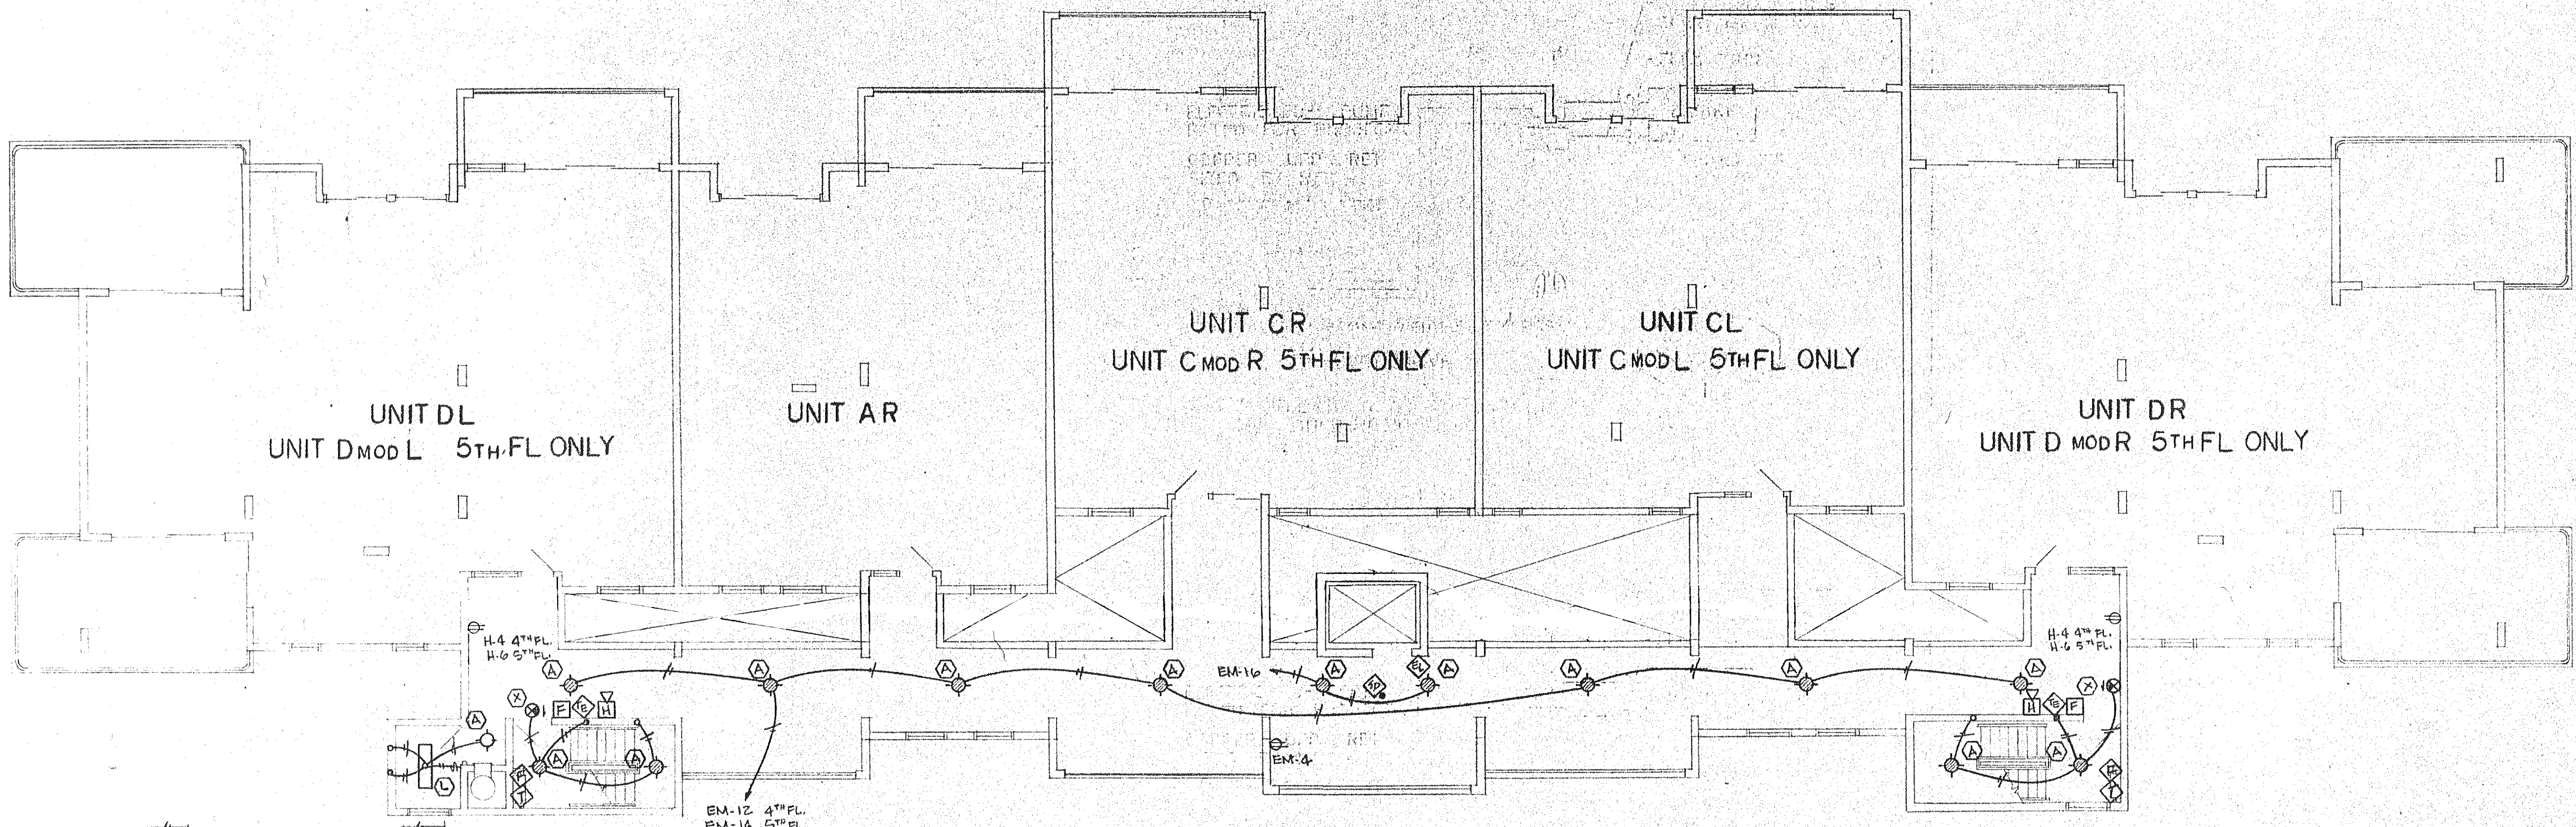

**FOURTH FLOOR**  
**TEL. & T.V. CLOSET**  
 N.T.S.

**FIFTH FLOOR**  
**STORE ROOM**  
 N.T.S.

**BUILDING 3 - FOURTH & FIFTH FLOOR ELECTRICAL PLAN**  
 scale 1/8" = 1'-0"

ELECTRICAL PLAN  
 FOR THE PROJECT  
 COMPLETE LAYOUT  
 DATE: 1-22-82

**SUNSET BEACH**  
 SOF LONG BOAT KEY  
 BENNETT & BISHOP, INC. CONSULTING ENGINEERS & SURVEYORS

ARVIDA CORPORATION, EDWARD J. SEIBERT, AIA, ARCHITECT & PLANNER, PA., THE SWA GROUP  
 BRABHAM, KUHN'S, DEBAY, CONSULTING ENGINEERS, OLSEN, WHITE & ASSOCIATES, STRUCTURAL ENGINEERS

ISSUED	4-1-82
REVISED	
SHEET	<b>E-5</b>
PLD	