


UNIT 'A' - LEFT ELECTRICAL PLAN

SCALE 1/4" = 1'-0"

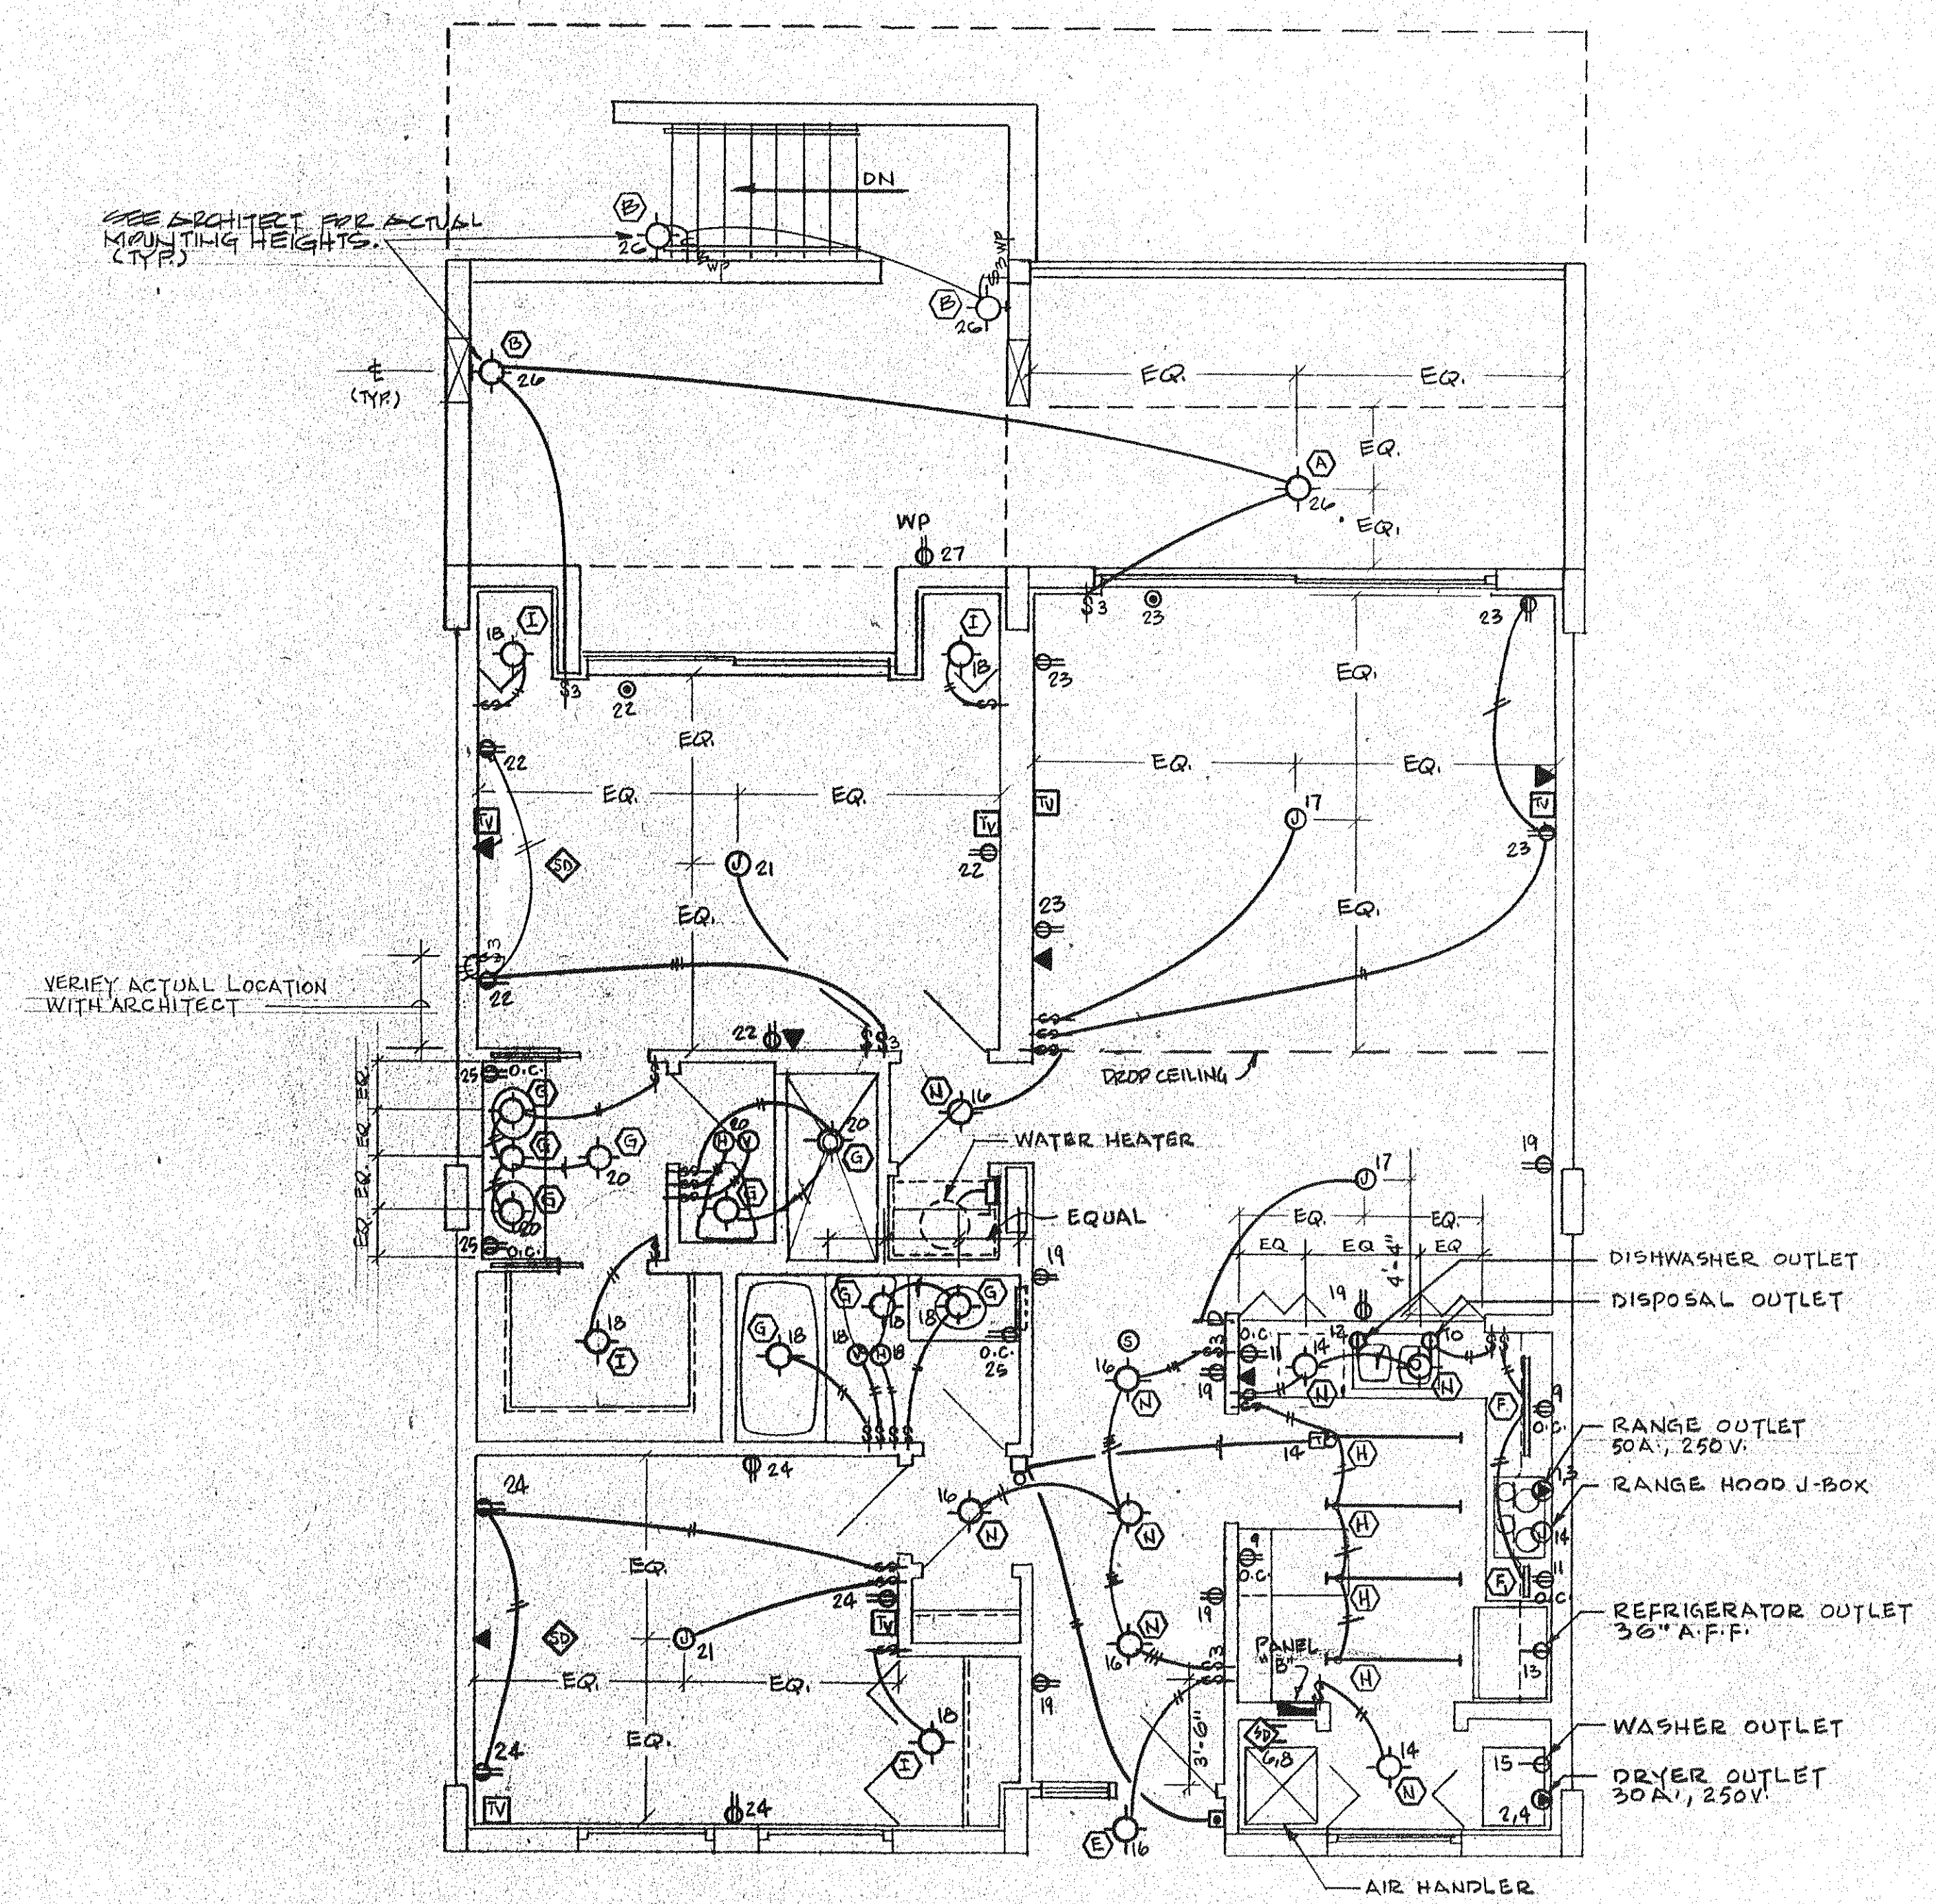

UNIT 'A' - RIGHT ELECTRICAL PLAN

SCALE 1/4" = 1'-0"

ISSUED
4-1-82

REVISED

SHEET
E-8

OF