


**UNIT "C" LEFT**

scale: 1/4" = 1'-0"

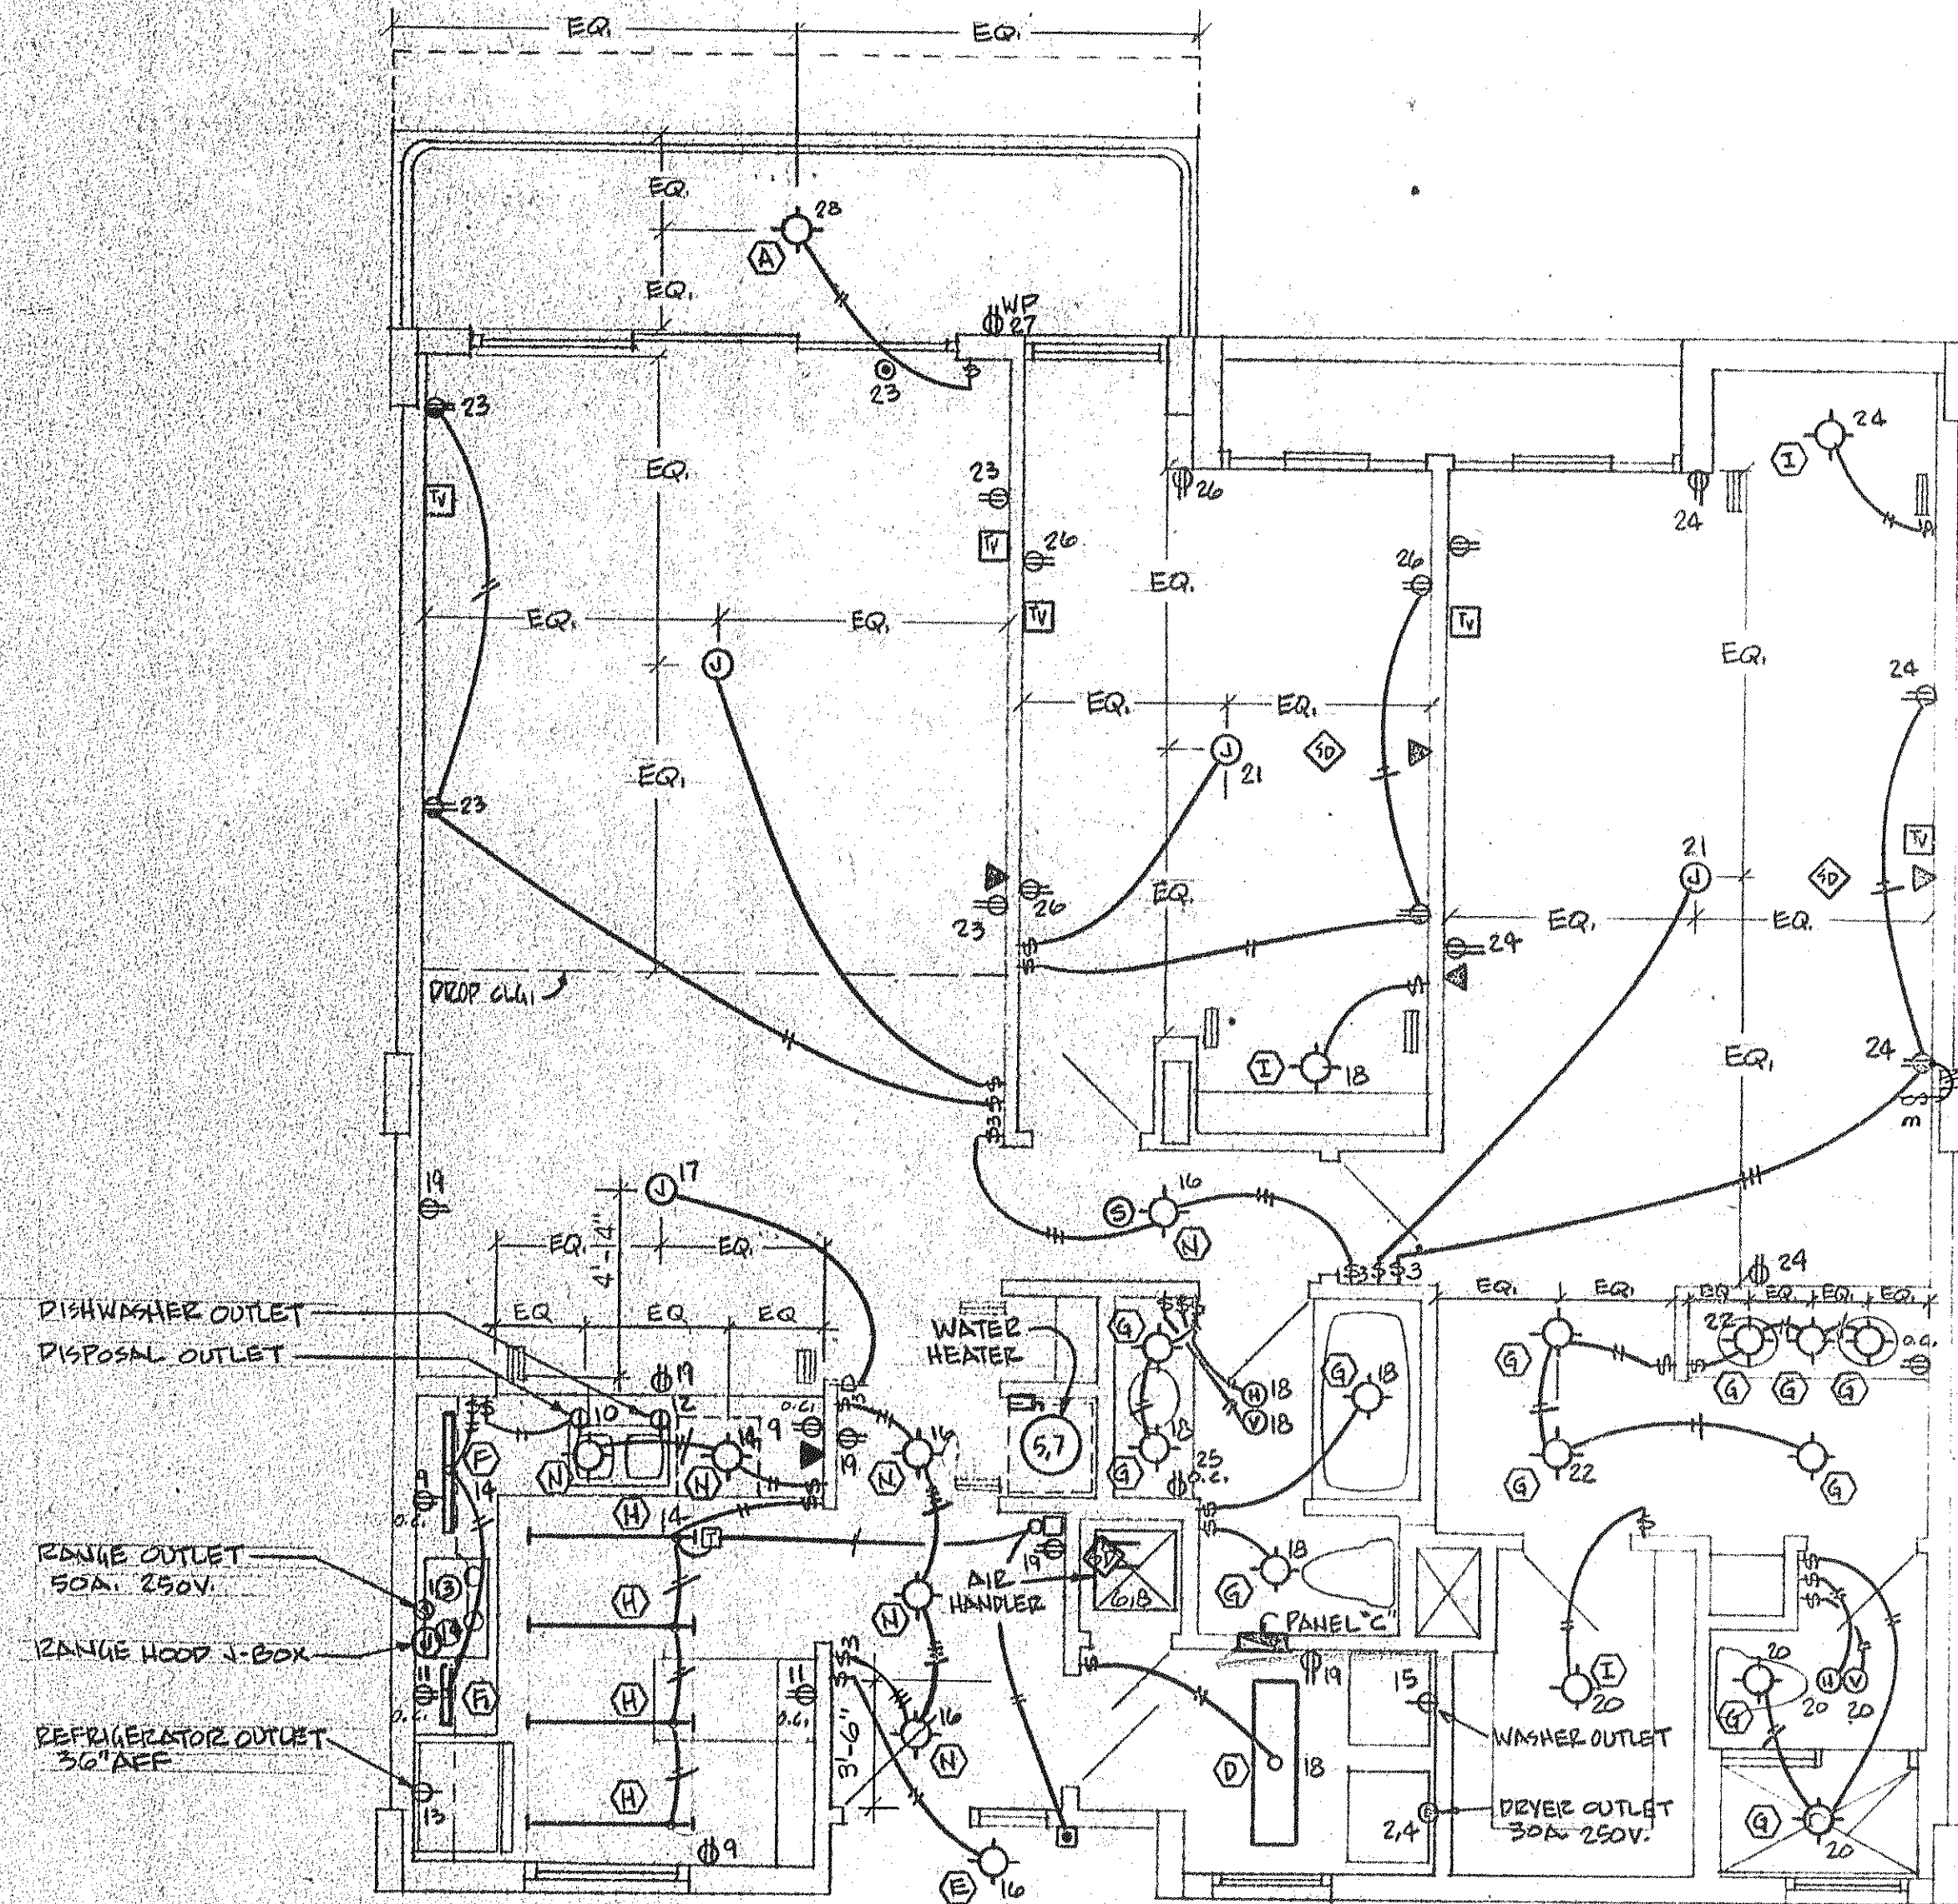

**UNIT "C" RIGHT - ELECTRICAL PLAN**

scale 1/4" = 1'-0"

VERIFY ACTUAL LOCATION WITH ARCHITECT (TYP.)

ISSUED	4/1/23
REVISED	
SHEET	E-9