


**UNIT "C" - LEFT**

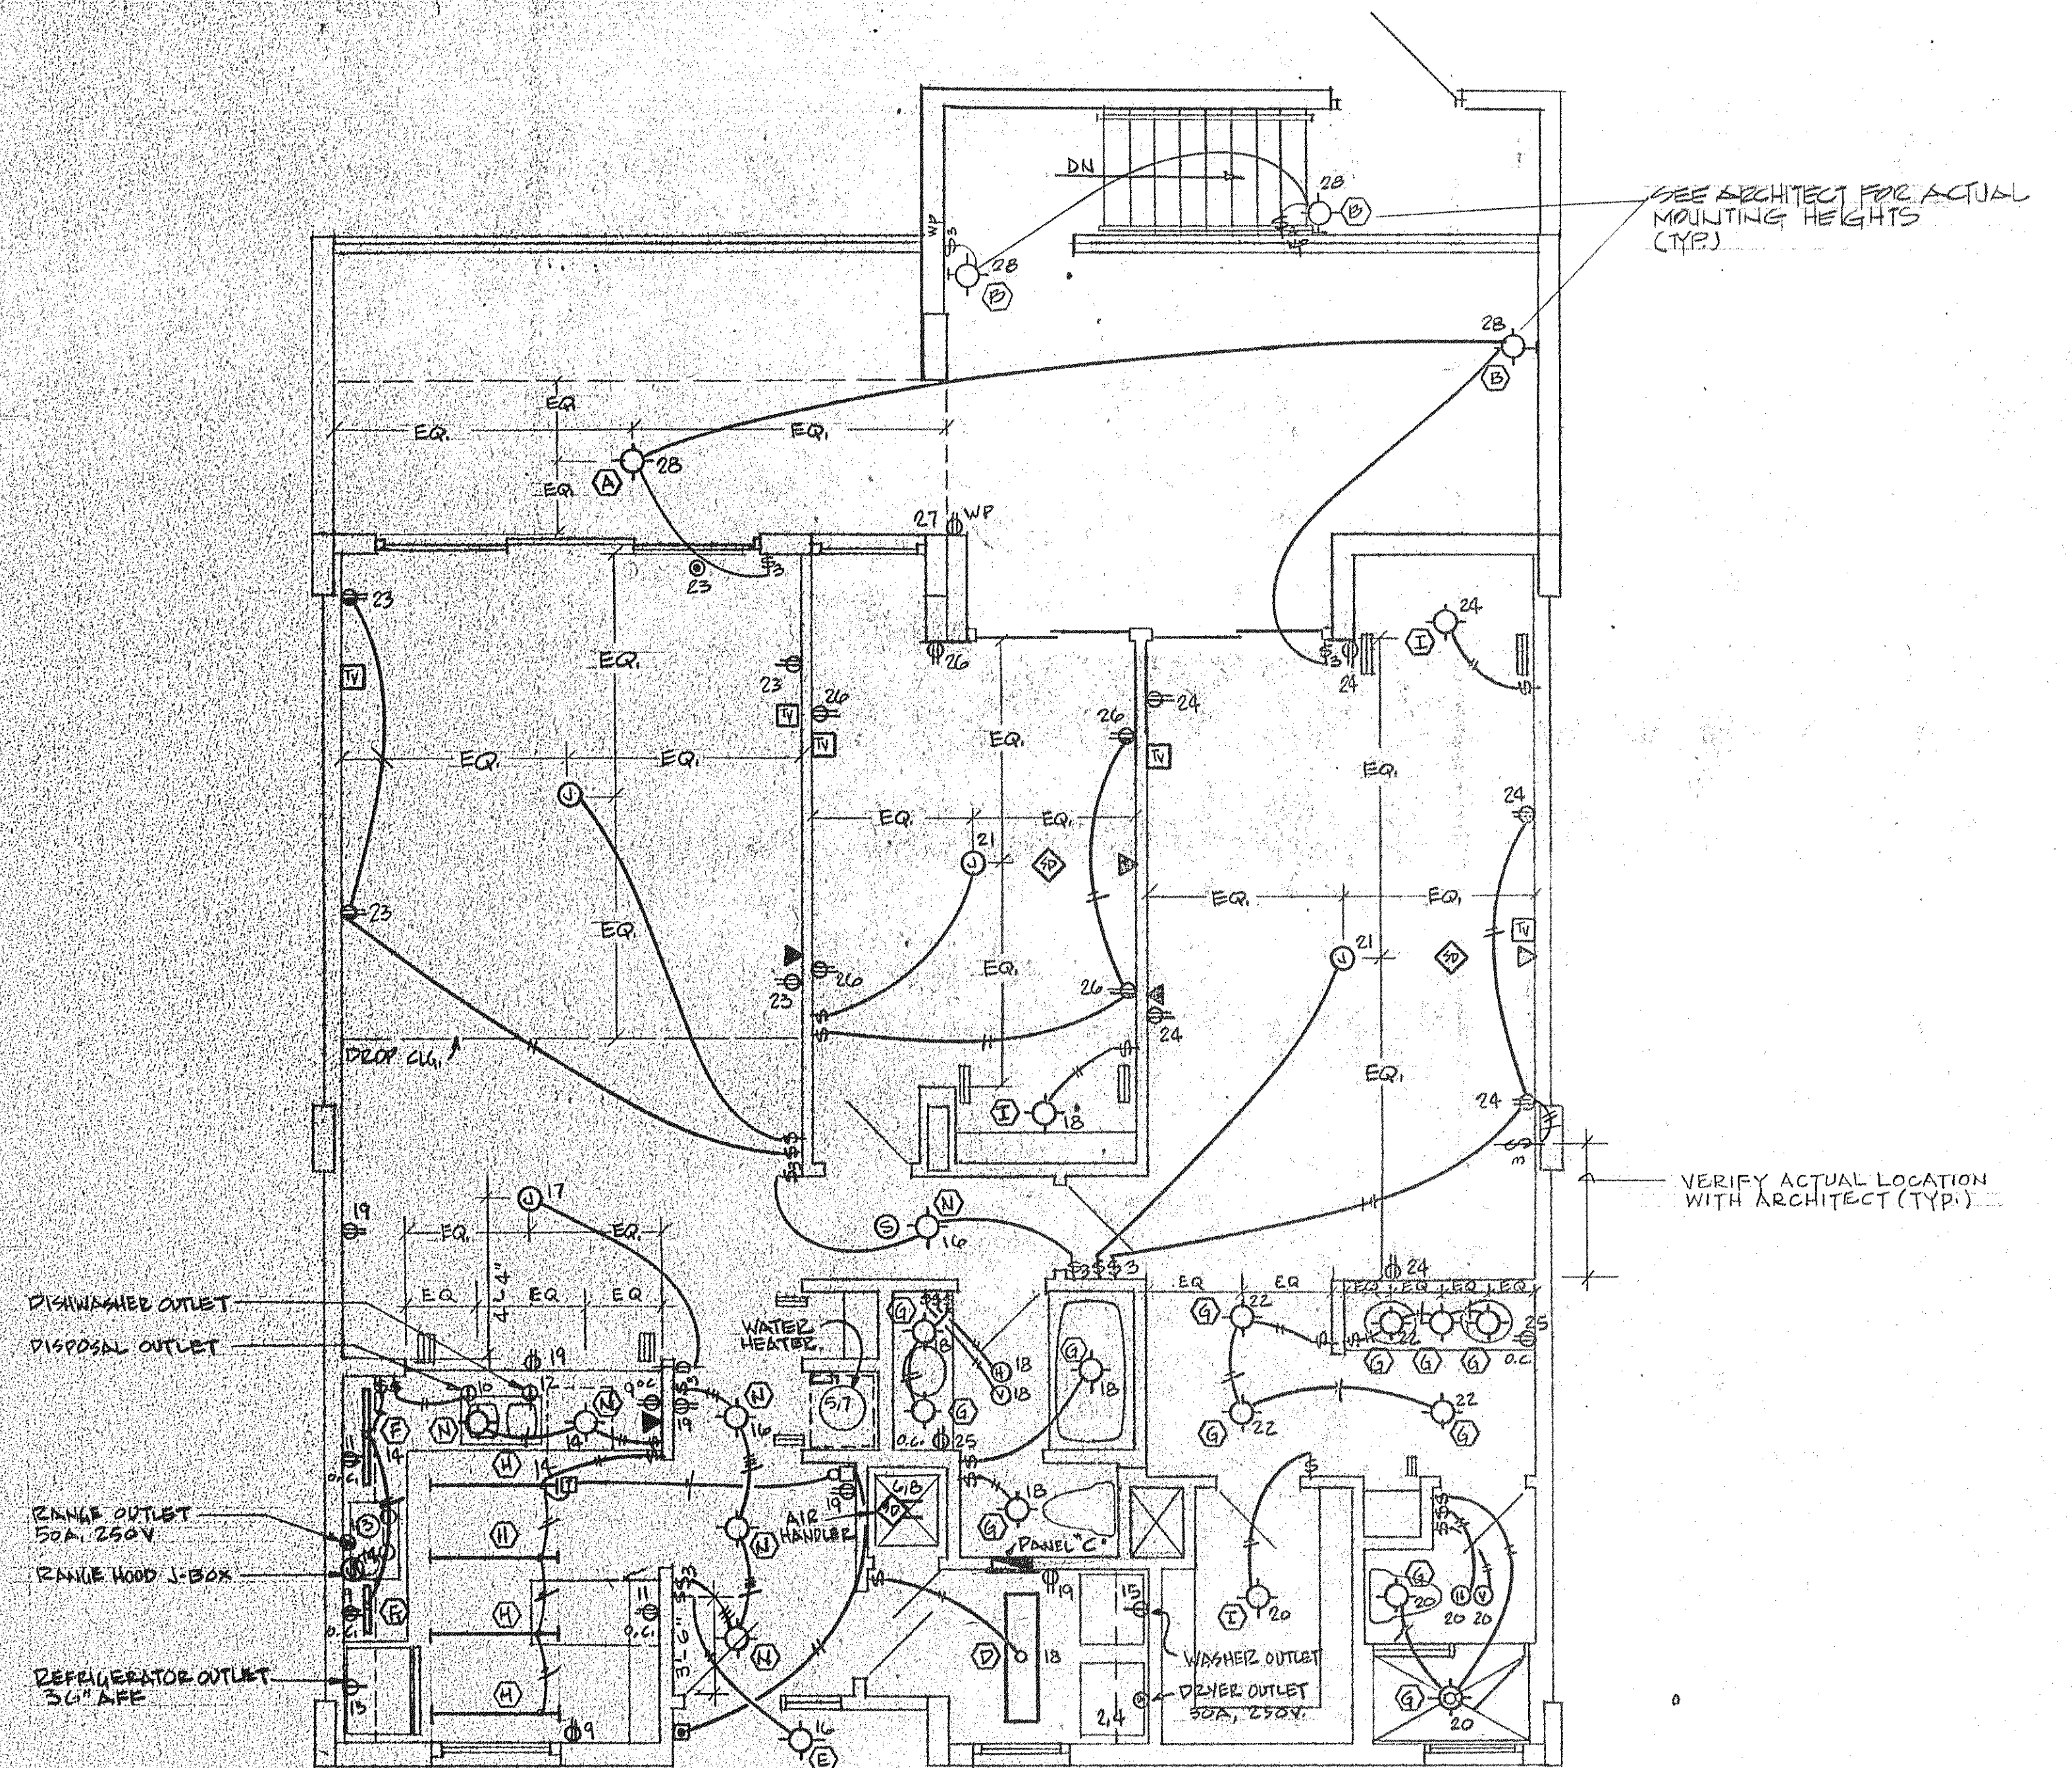

**UNIT "C" + RIGHT - ELECTRICAL PLAN**

scale 1/4" = 1'-0"

ISSUED	4-1-22
REVISED	
SHEET	E-10
OF	