


UNIT 'D' LEFT  
SCALE 1/4" = 1'-0"

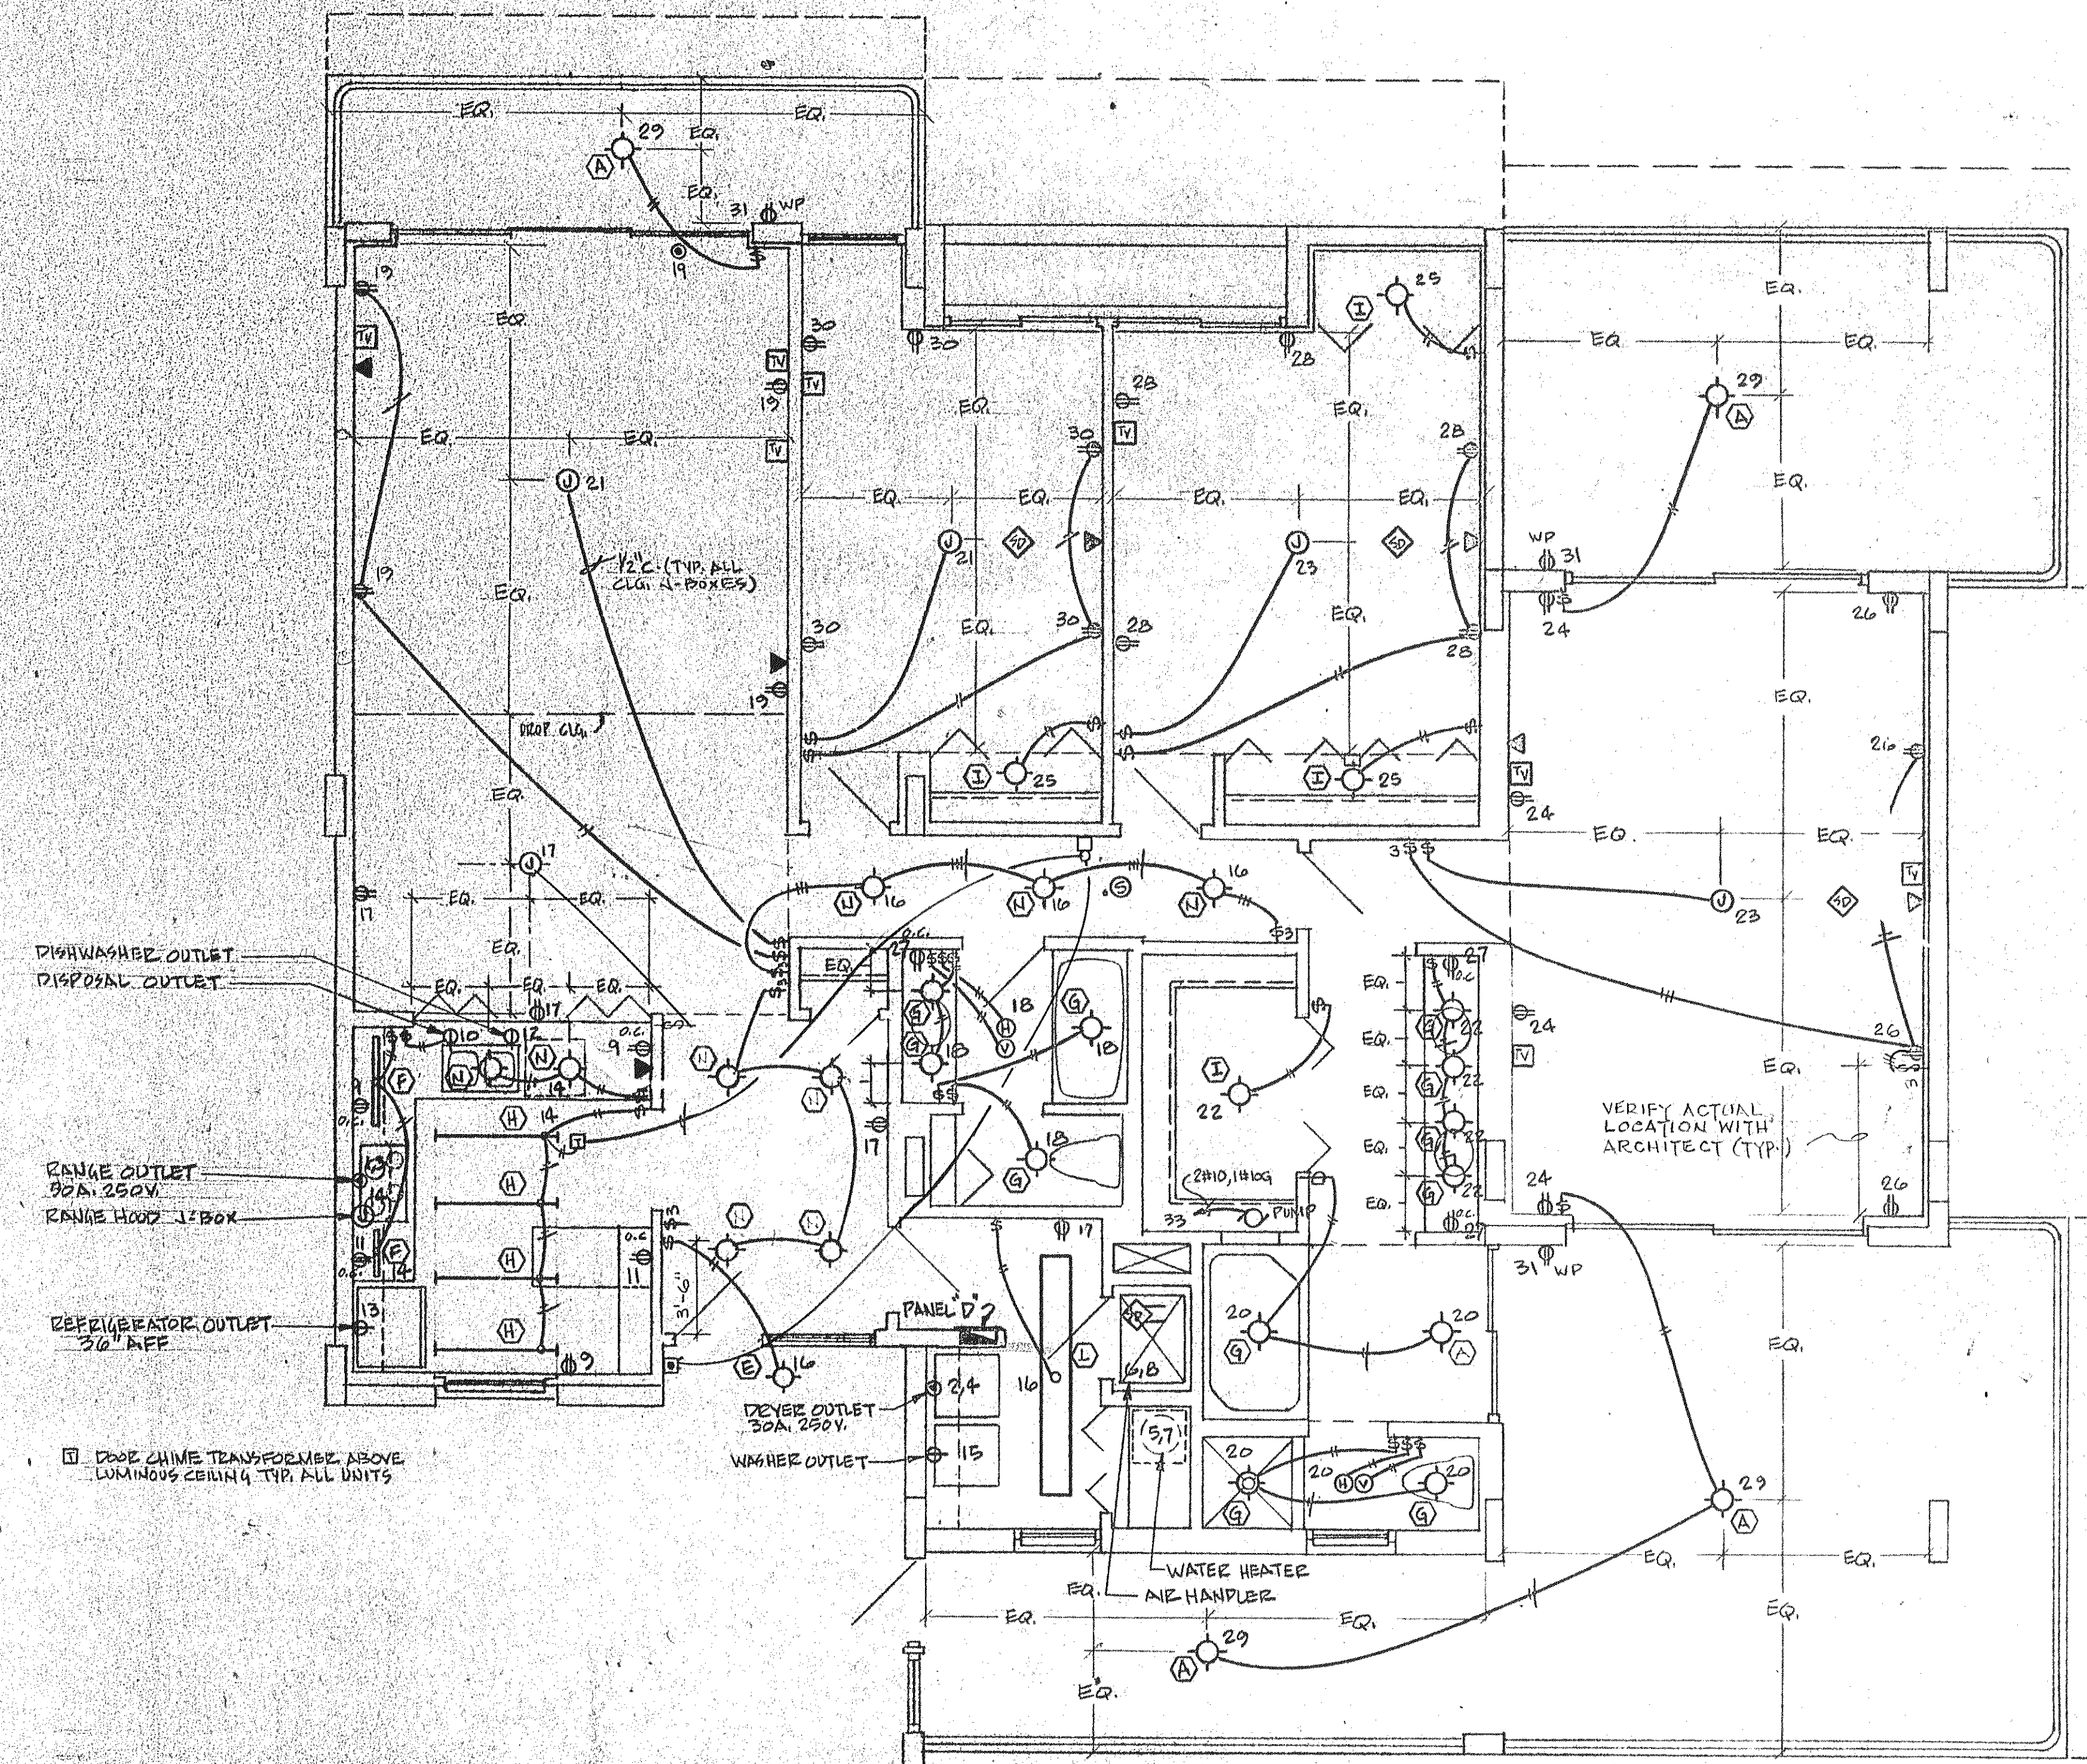

UNIT 'D' RIGHT - ELECTRICAL PLAN  
SCALE 1/4" = 1'-0"

ISSUED	1 1 87
REVISED	
SHEET	E-12
OF	