


UNIT D+ LEFT

SCALE: 1/4" = 1'-0"

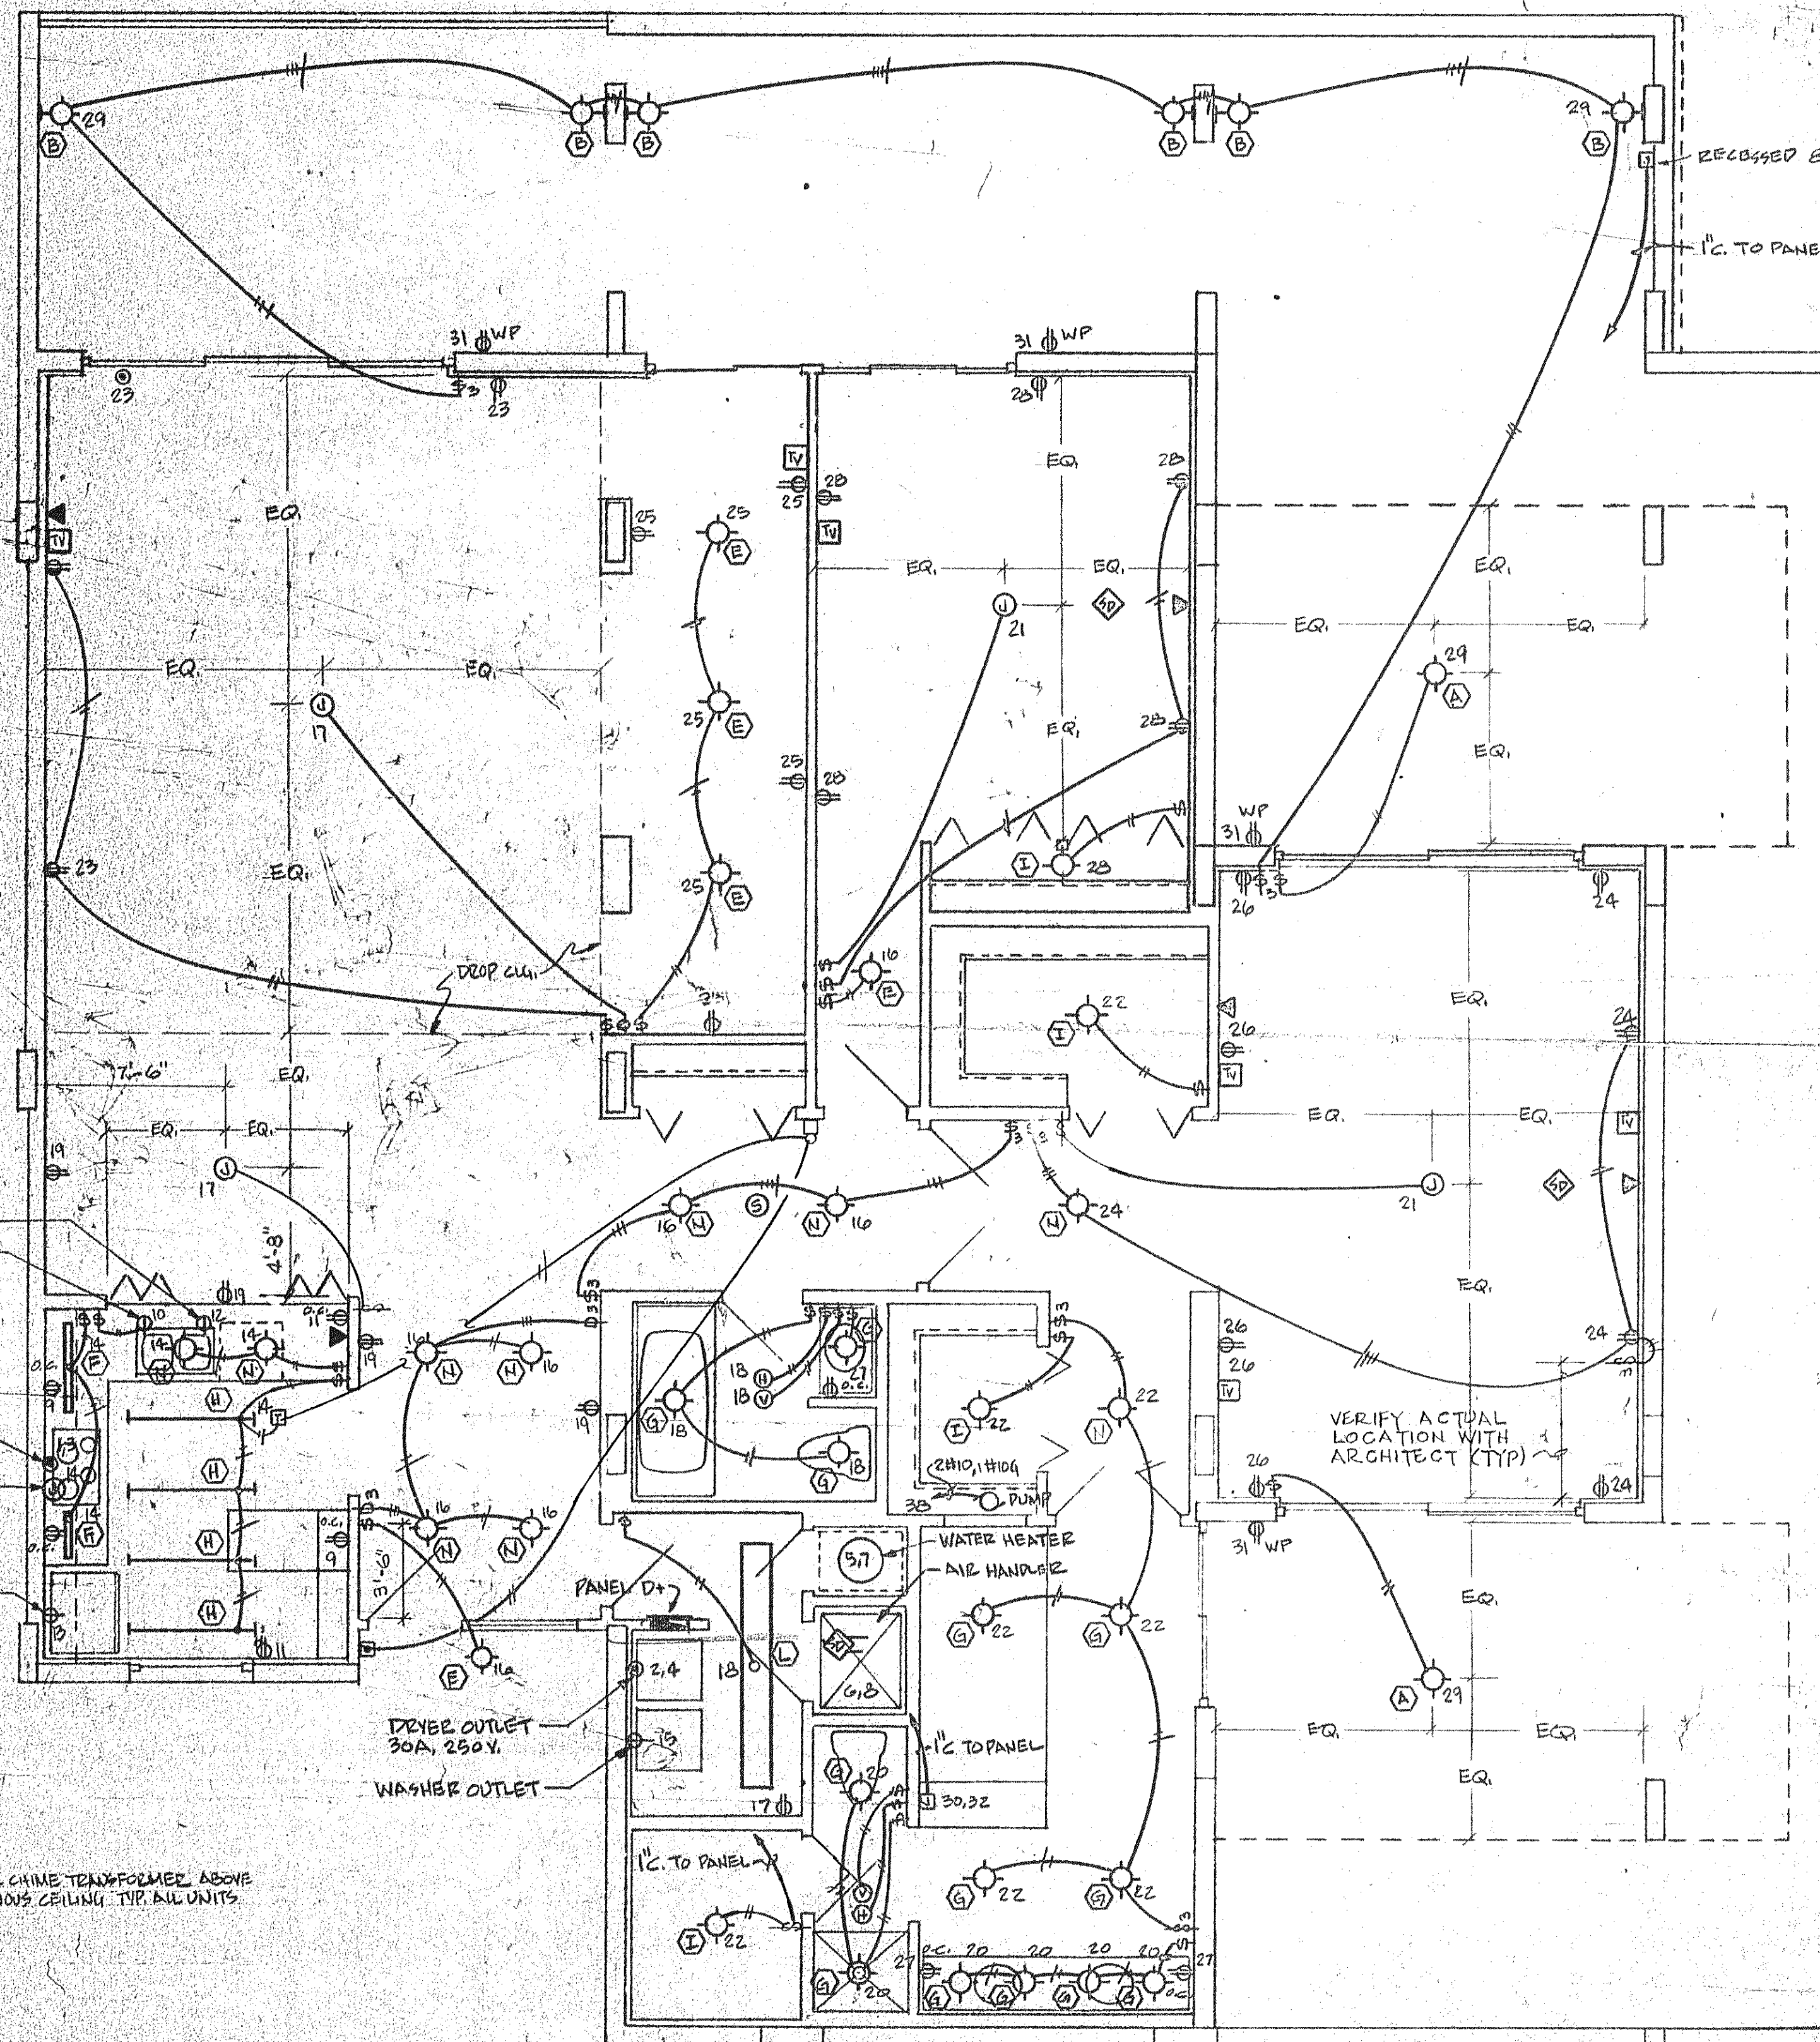

UNIT D+ RIGHT ELECTRICAL PLAN

SCALE: 1/8" = 1'-0"

DISHWASHER OUTLET
DISPOSAL OUTLET

RANGE OUTLET
30A, 250V.
RANGE HOOD J-BOX

REFRIGERATOR OUTLET
30'AFF

DRYER OUTLET
30A, 250V.
WASHER OUTLET

DOOR CHIME TRANSFORMER ABOVE
LUMINOUS CEILING TRIP ALL UNITS

VERIFY ACTUAL
LOCATION WITH
ARCHITECT (CITY)

ISSUED
REVISED
SHEET
E-13
OF