


**UNIT 'A' - LEFT PLUMBING PLAN**  
 SCALE 1/4" = 1'-0"

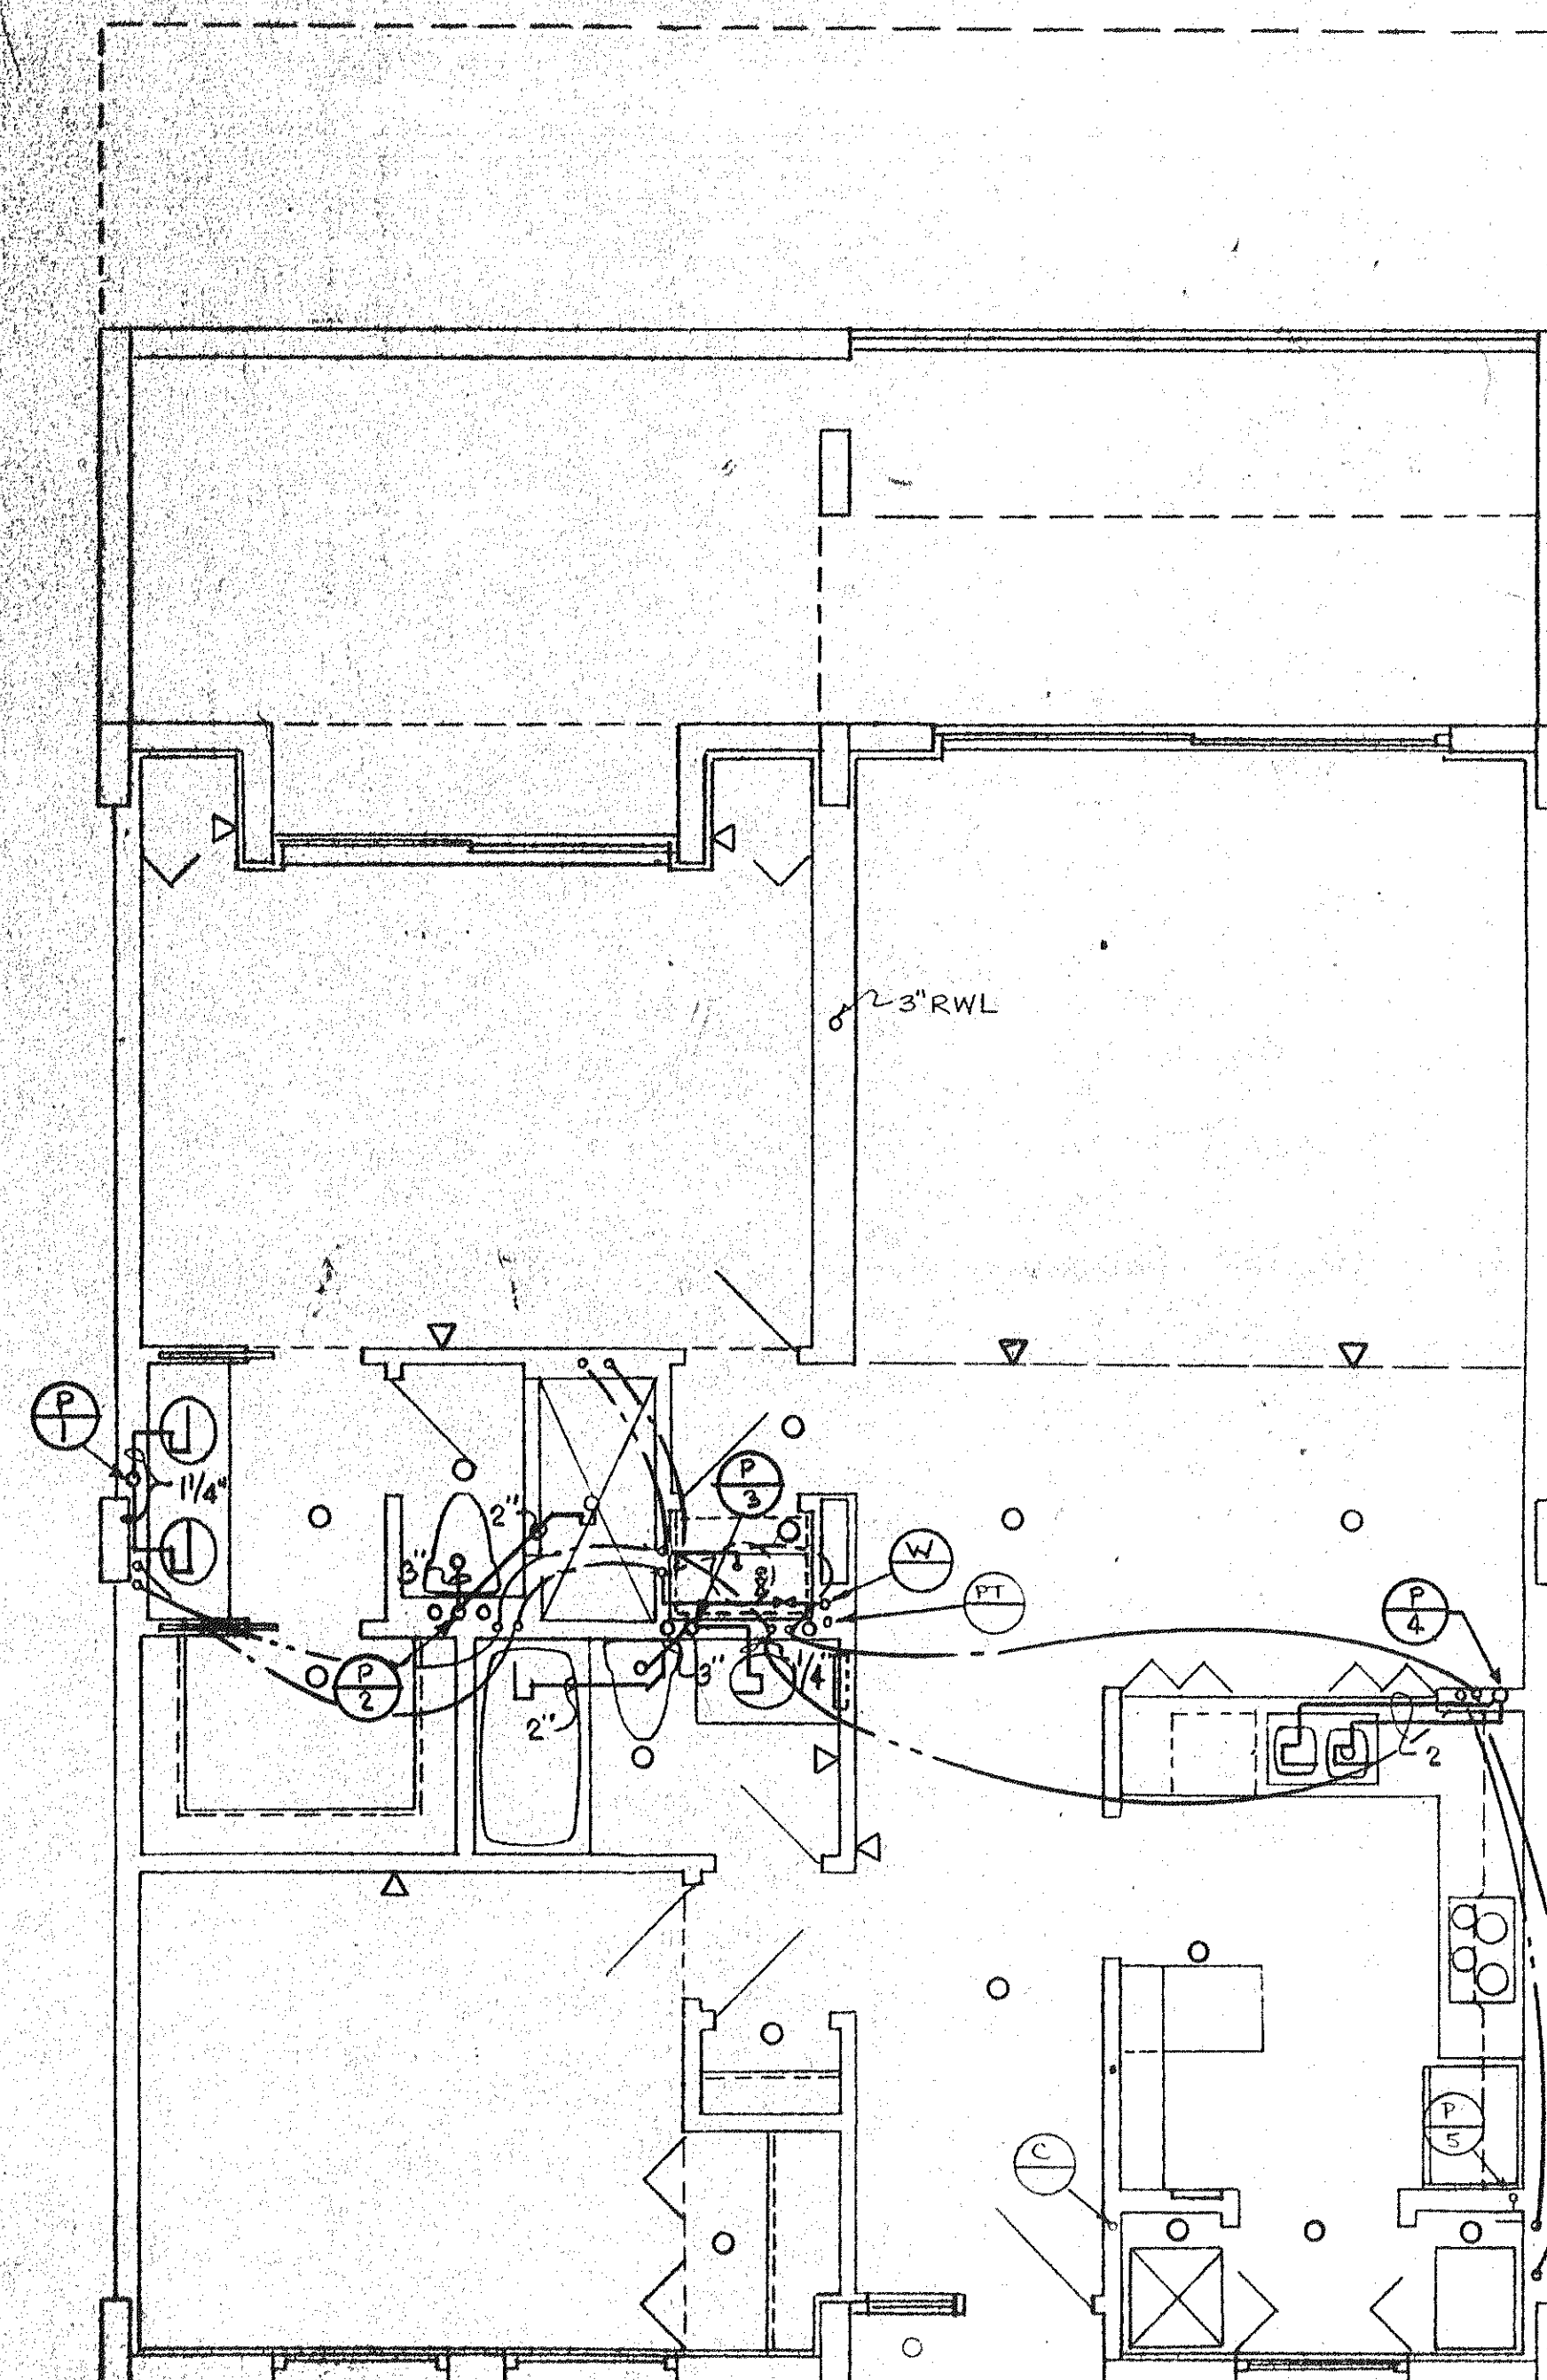

**UNIT 'A' - RIGHT PLUMBING PLAN**  
 SCALE 1/4" = 1'-0"