


UNIT 'C' LEFT PLUMBING PLAN

SCALE: 1/4" = 1'-0"

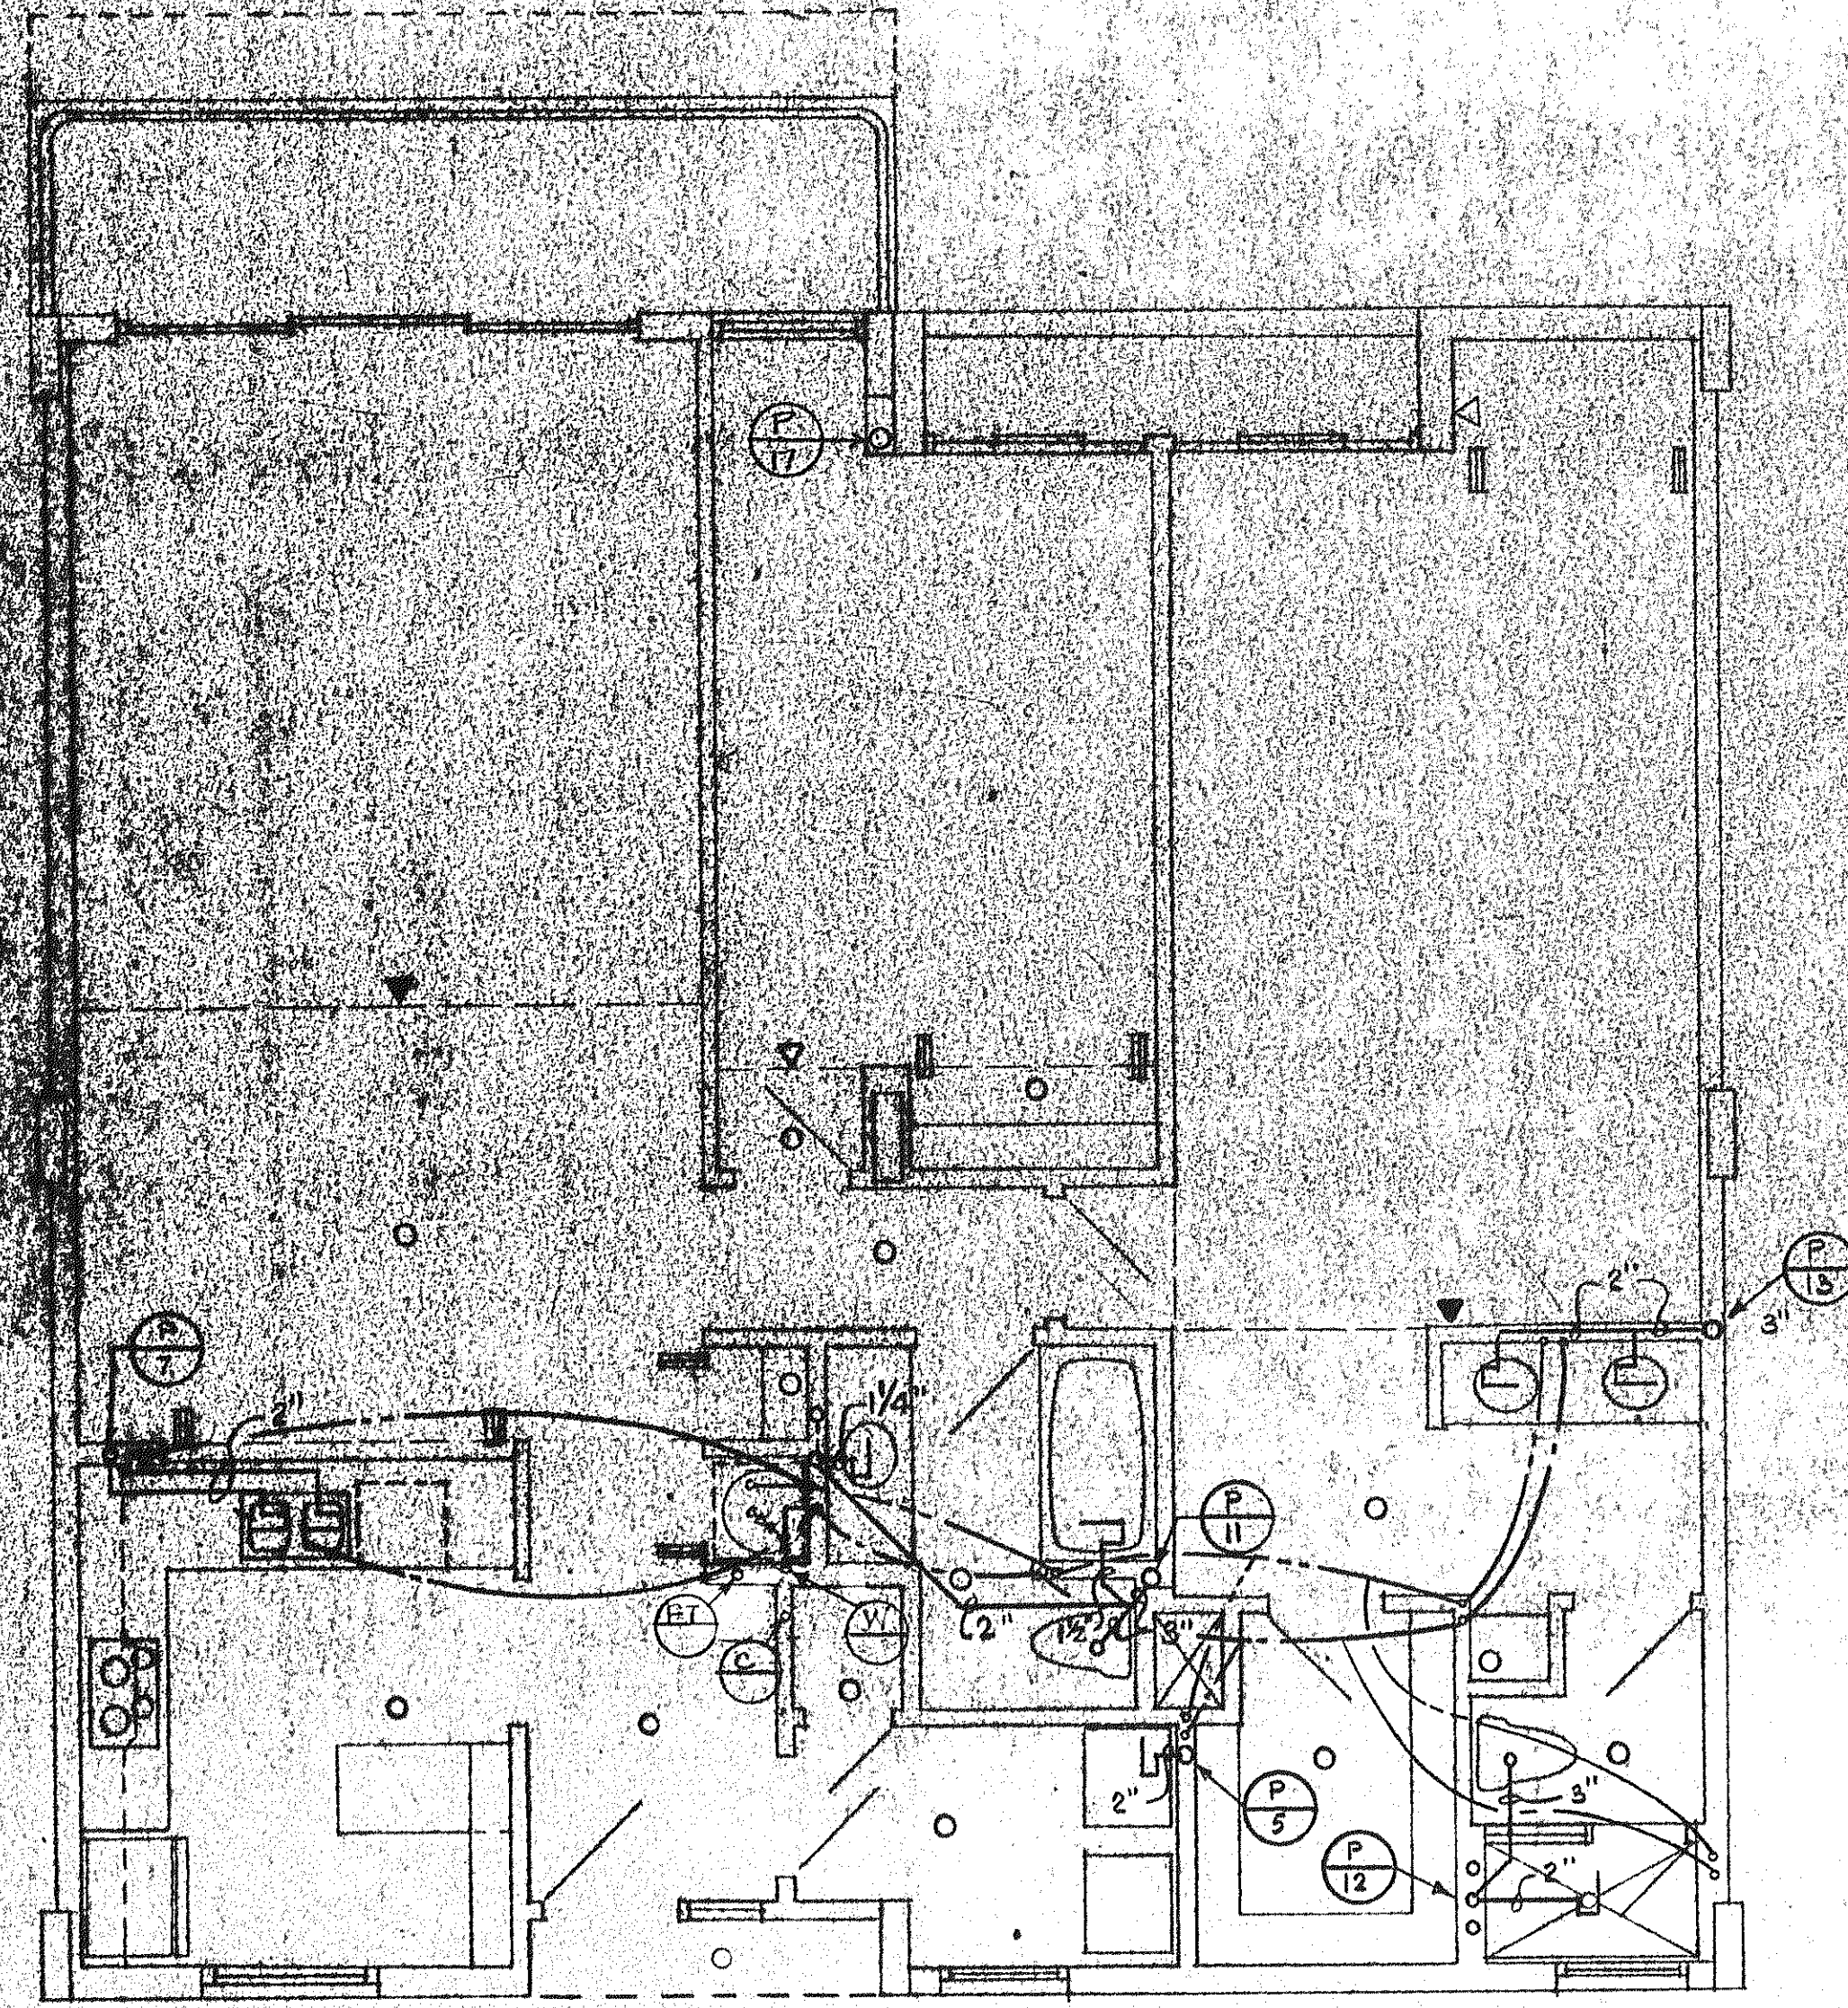

UNIT 'C' RIGHT PLUMBING PLAN

SCALE: 1/4" = 1'-0"

ISSUED	4-1-82
REVISED	
SHEET	P-3
	BLDG. 3