


UNIT 'C' LEFT PLUMBING PLAN
 scale: 1/4" = 1'-0"

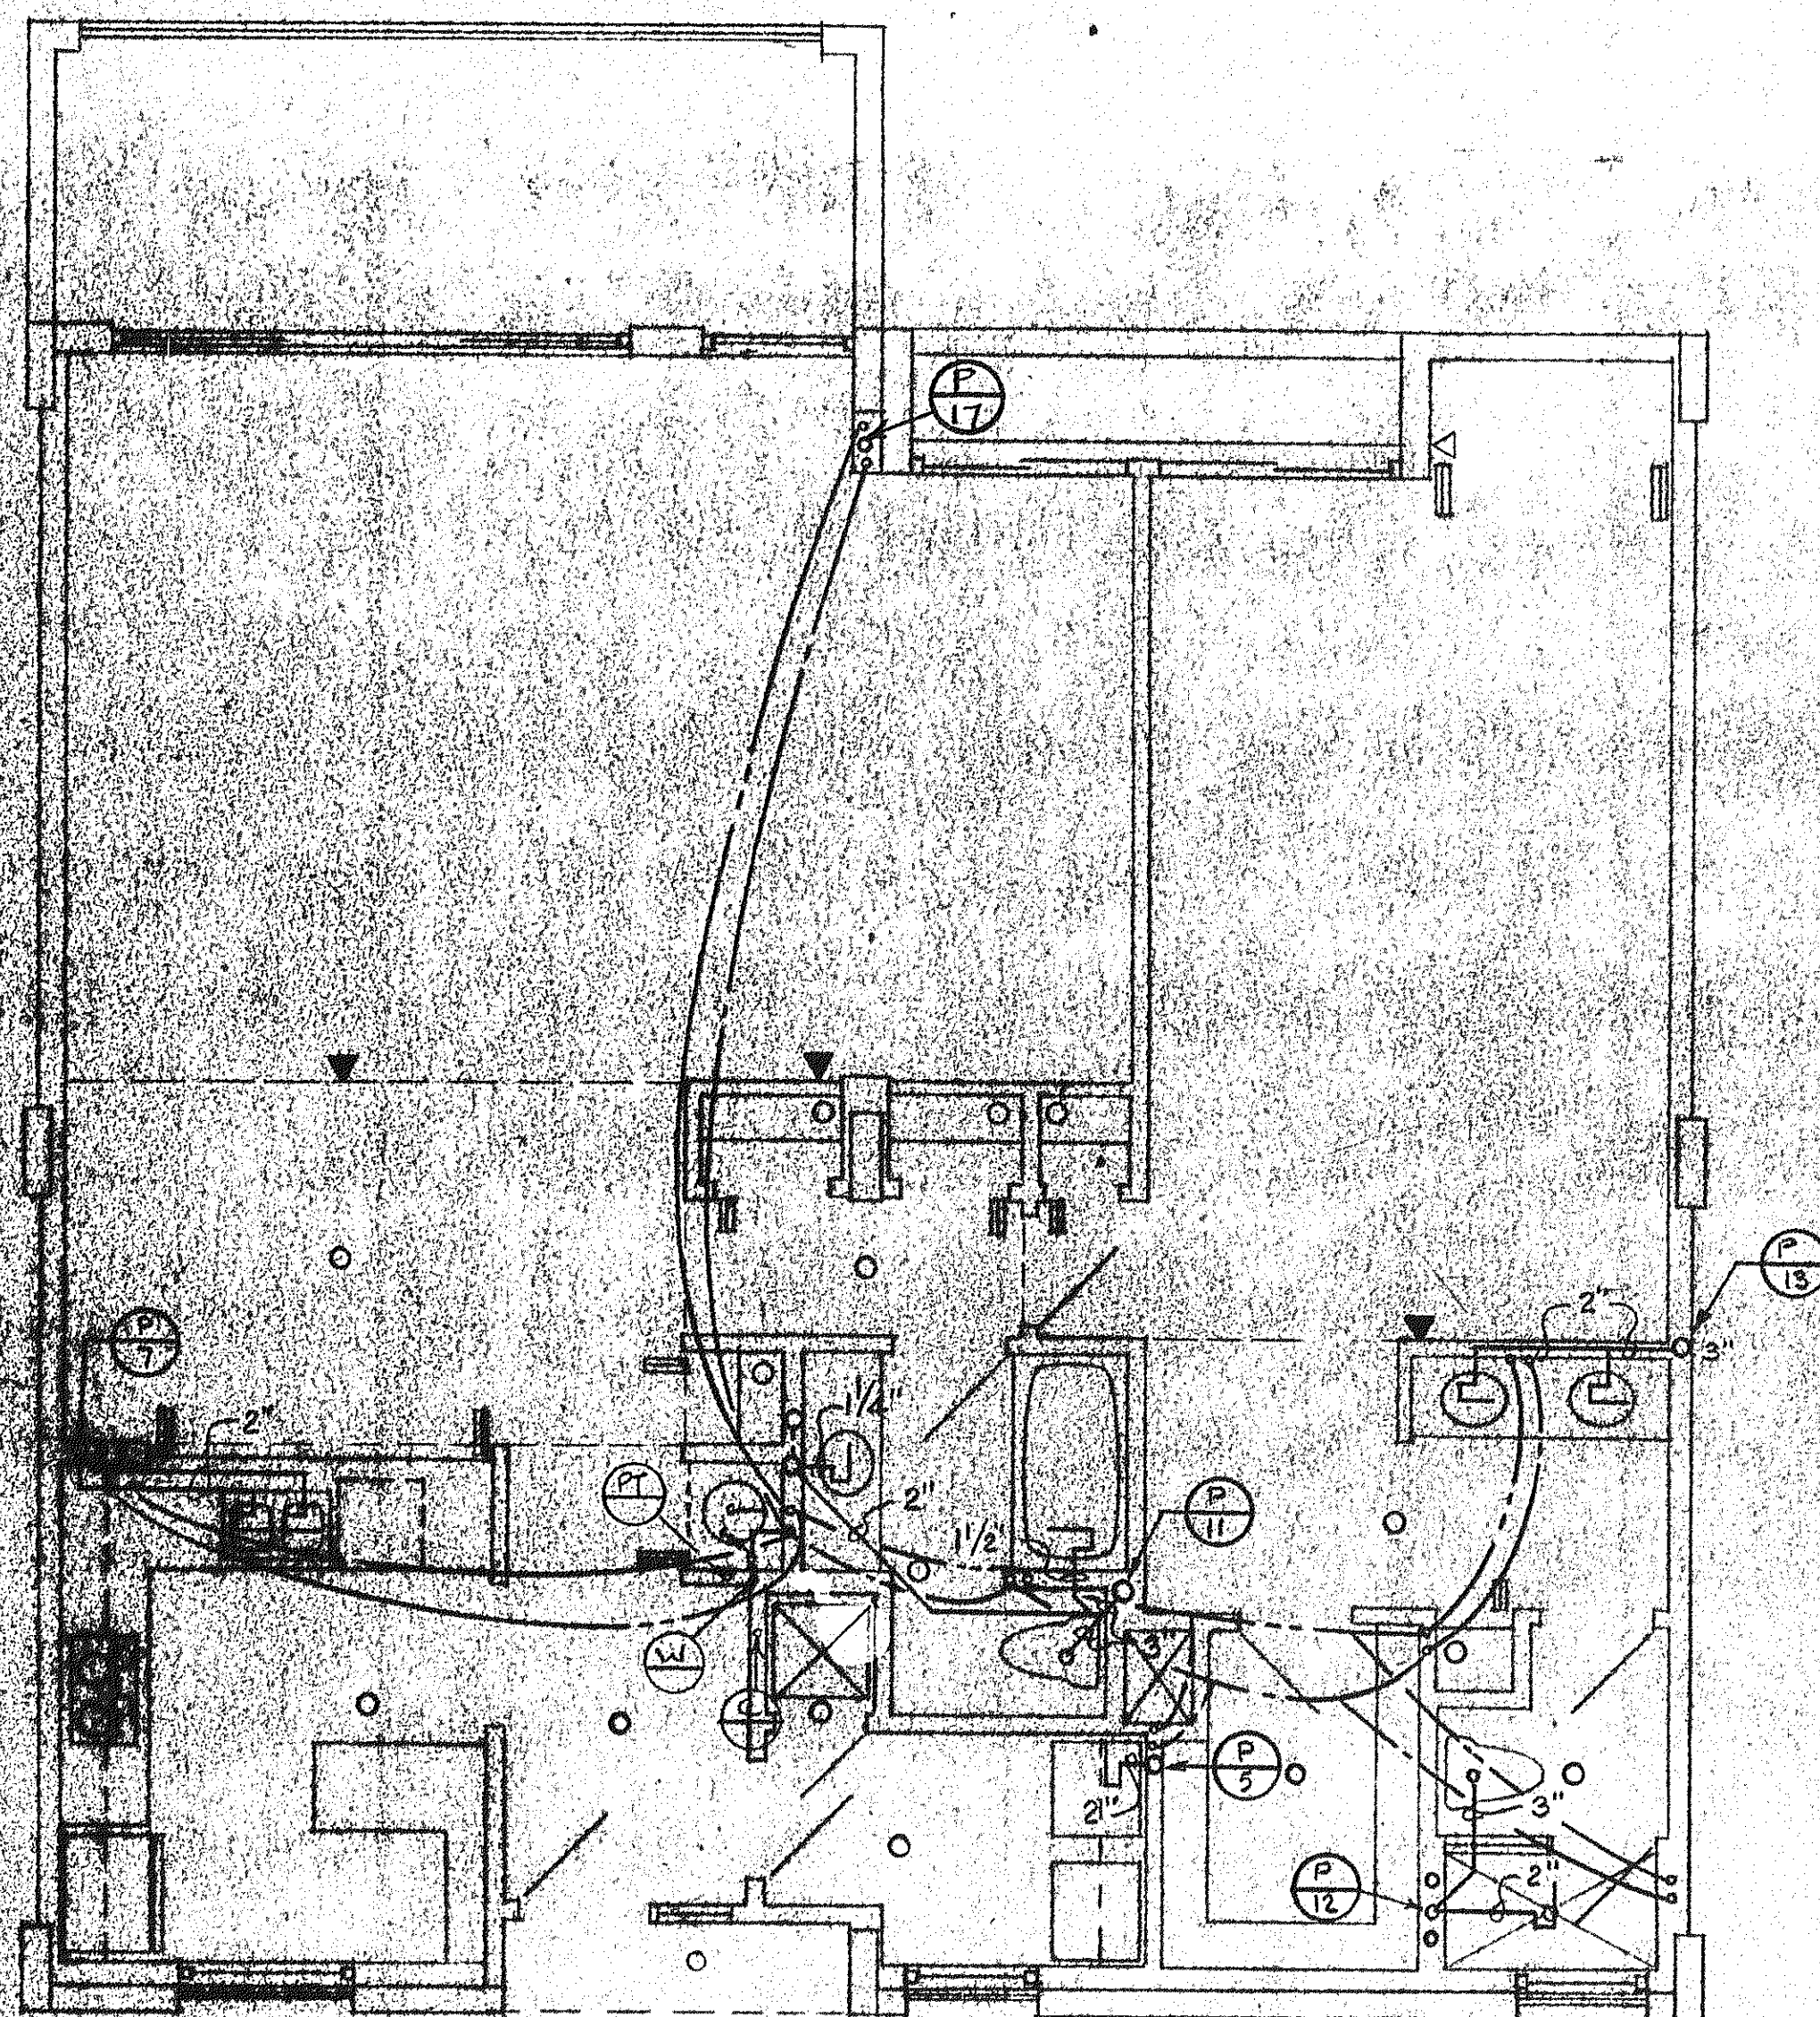

UNIT 'C' RIGHT PLUMBING PLAN

ARVADA CORPORATION, EDWARD J. SEIBERT, P.E., ARCHITECT & PLANNER, P.A., THE S.W.A. GROUP
 SEBASTIAN K. KINGS, DEBAY CONSULTING ENGINEERS, OLSEN WHITE & ASSOCIATES, STRUCTURAL ENGINEERS

ISSUED	
REVISED	
SHEET	
P-5	
BLDG. 3	