


UNIT 'D' LEFT
 SCALE 1/4" = 1'-0"

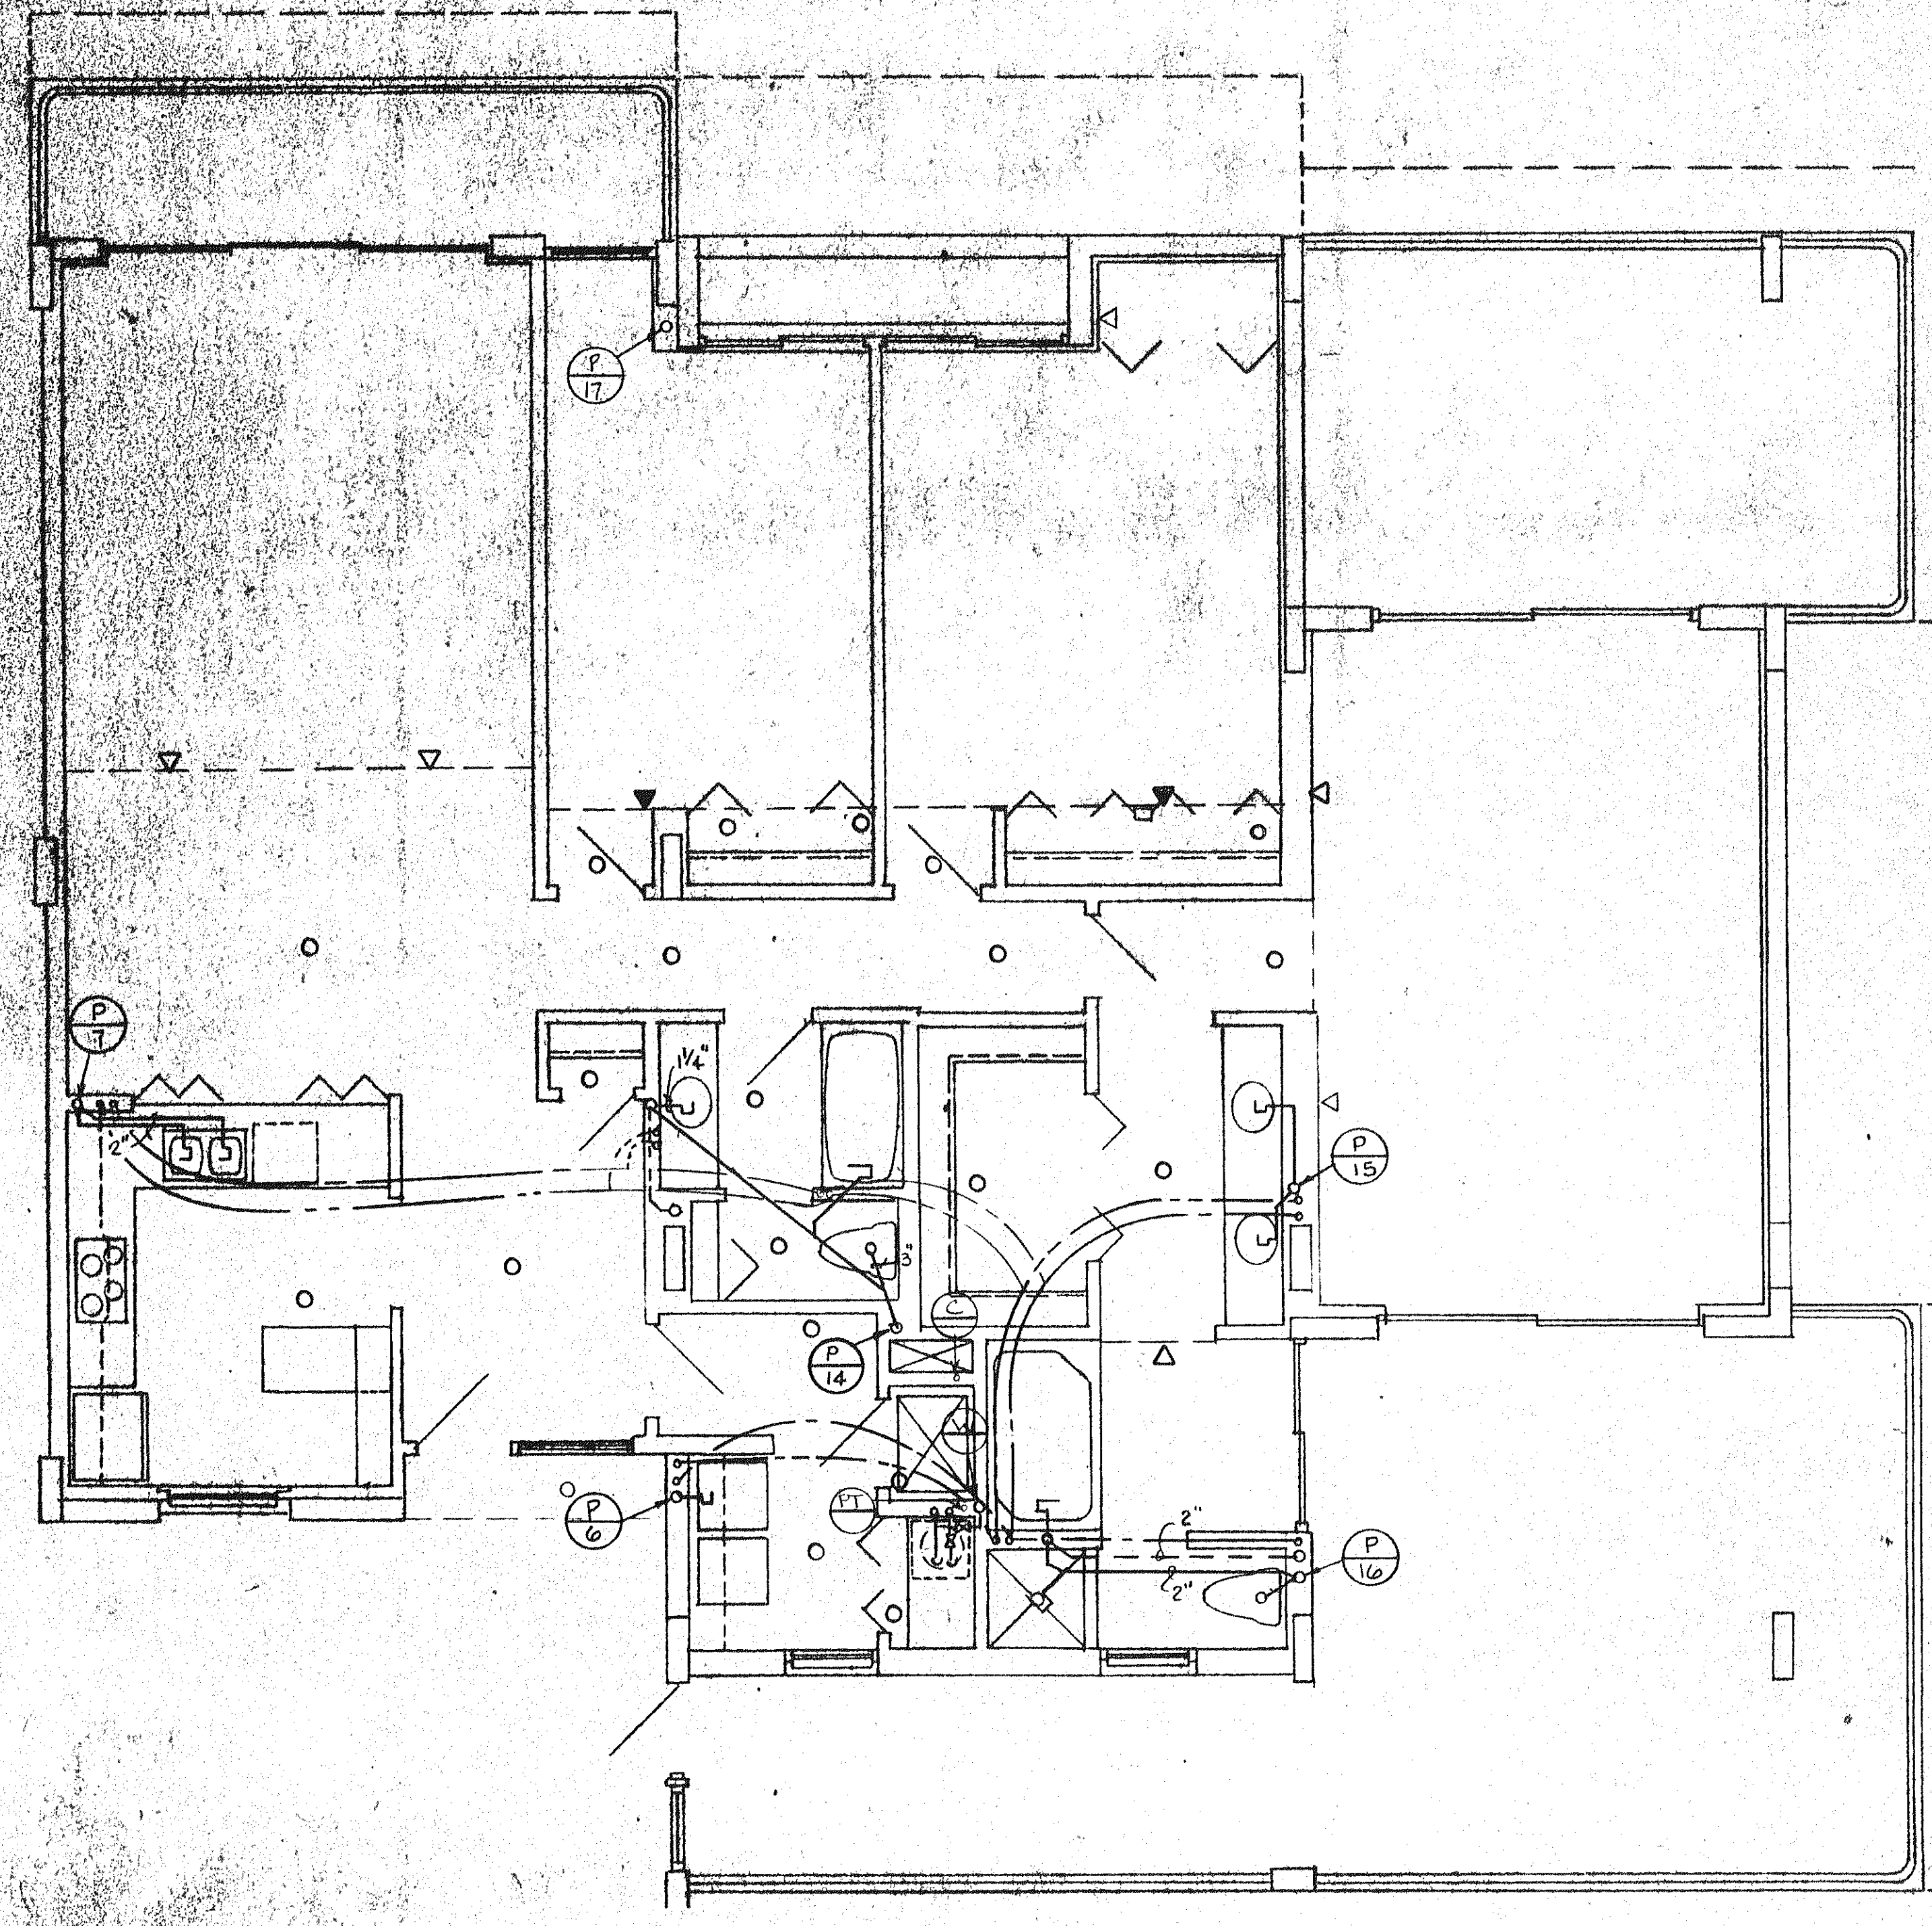

UNIT 'D' RIGHT - PLUMBING PLAN

ISSUED	4-1-82
REVISED	
SHEET	P-6
BLDG.	3
OF	

SUNSET BEACH
 OF LONG BEACH KEY
 ARVIDA CORPORATION, EDWARD J. SEBERT, AIA, ARCHITECT & PLANNER, P.A., THE SVA GROUP
 BRAHAM KUHN DEBAY CONSULTING ENGINEERS, OLSEN WHITE & ASSOCIATES, STRUCTURAL ENGINEERS, BENNETT & BISHOP, INC., CONSULTING ENGINEERS & SURVEYORS