


UNIT "D" MOD. LEFT PLUMBING PLAN

Scale: 1/4" = 1'-0"

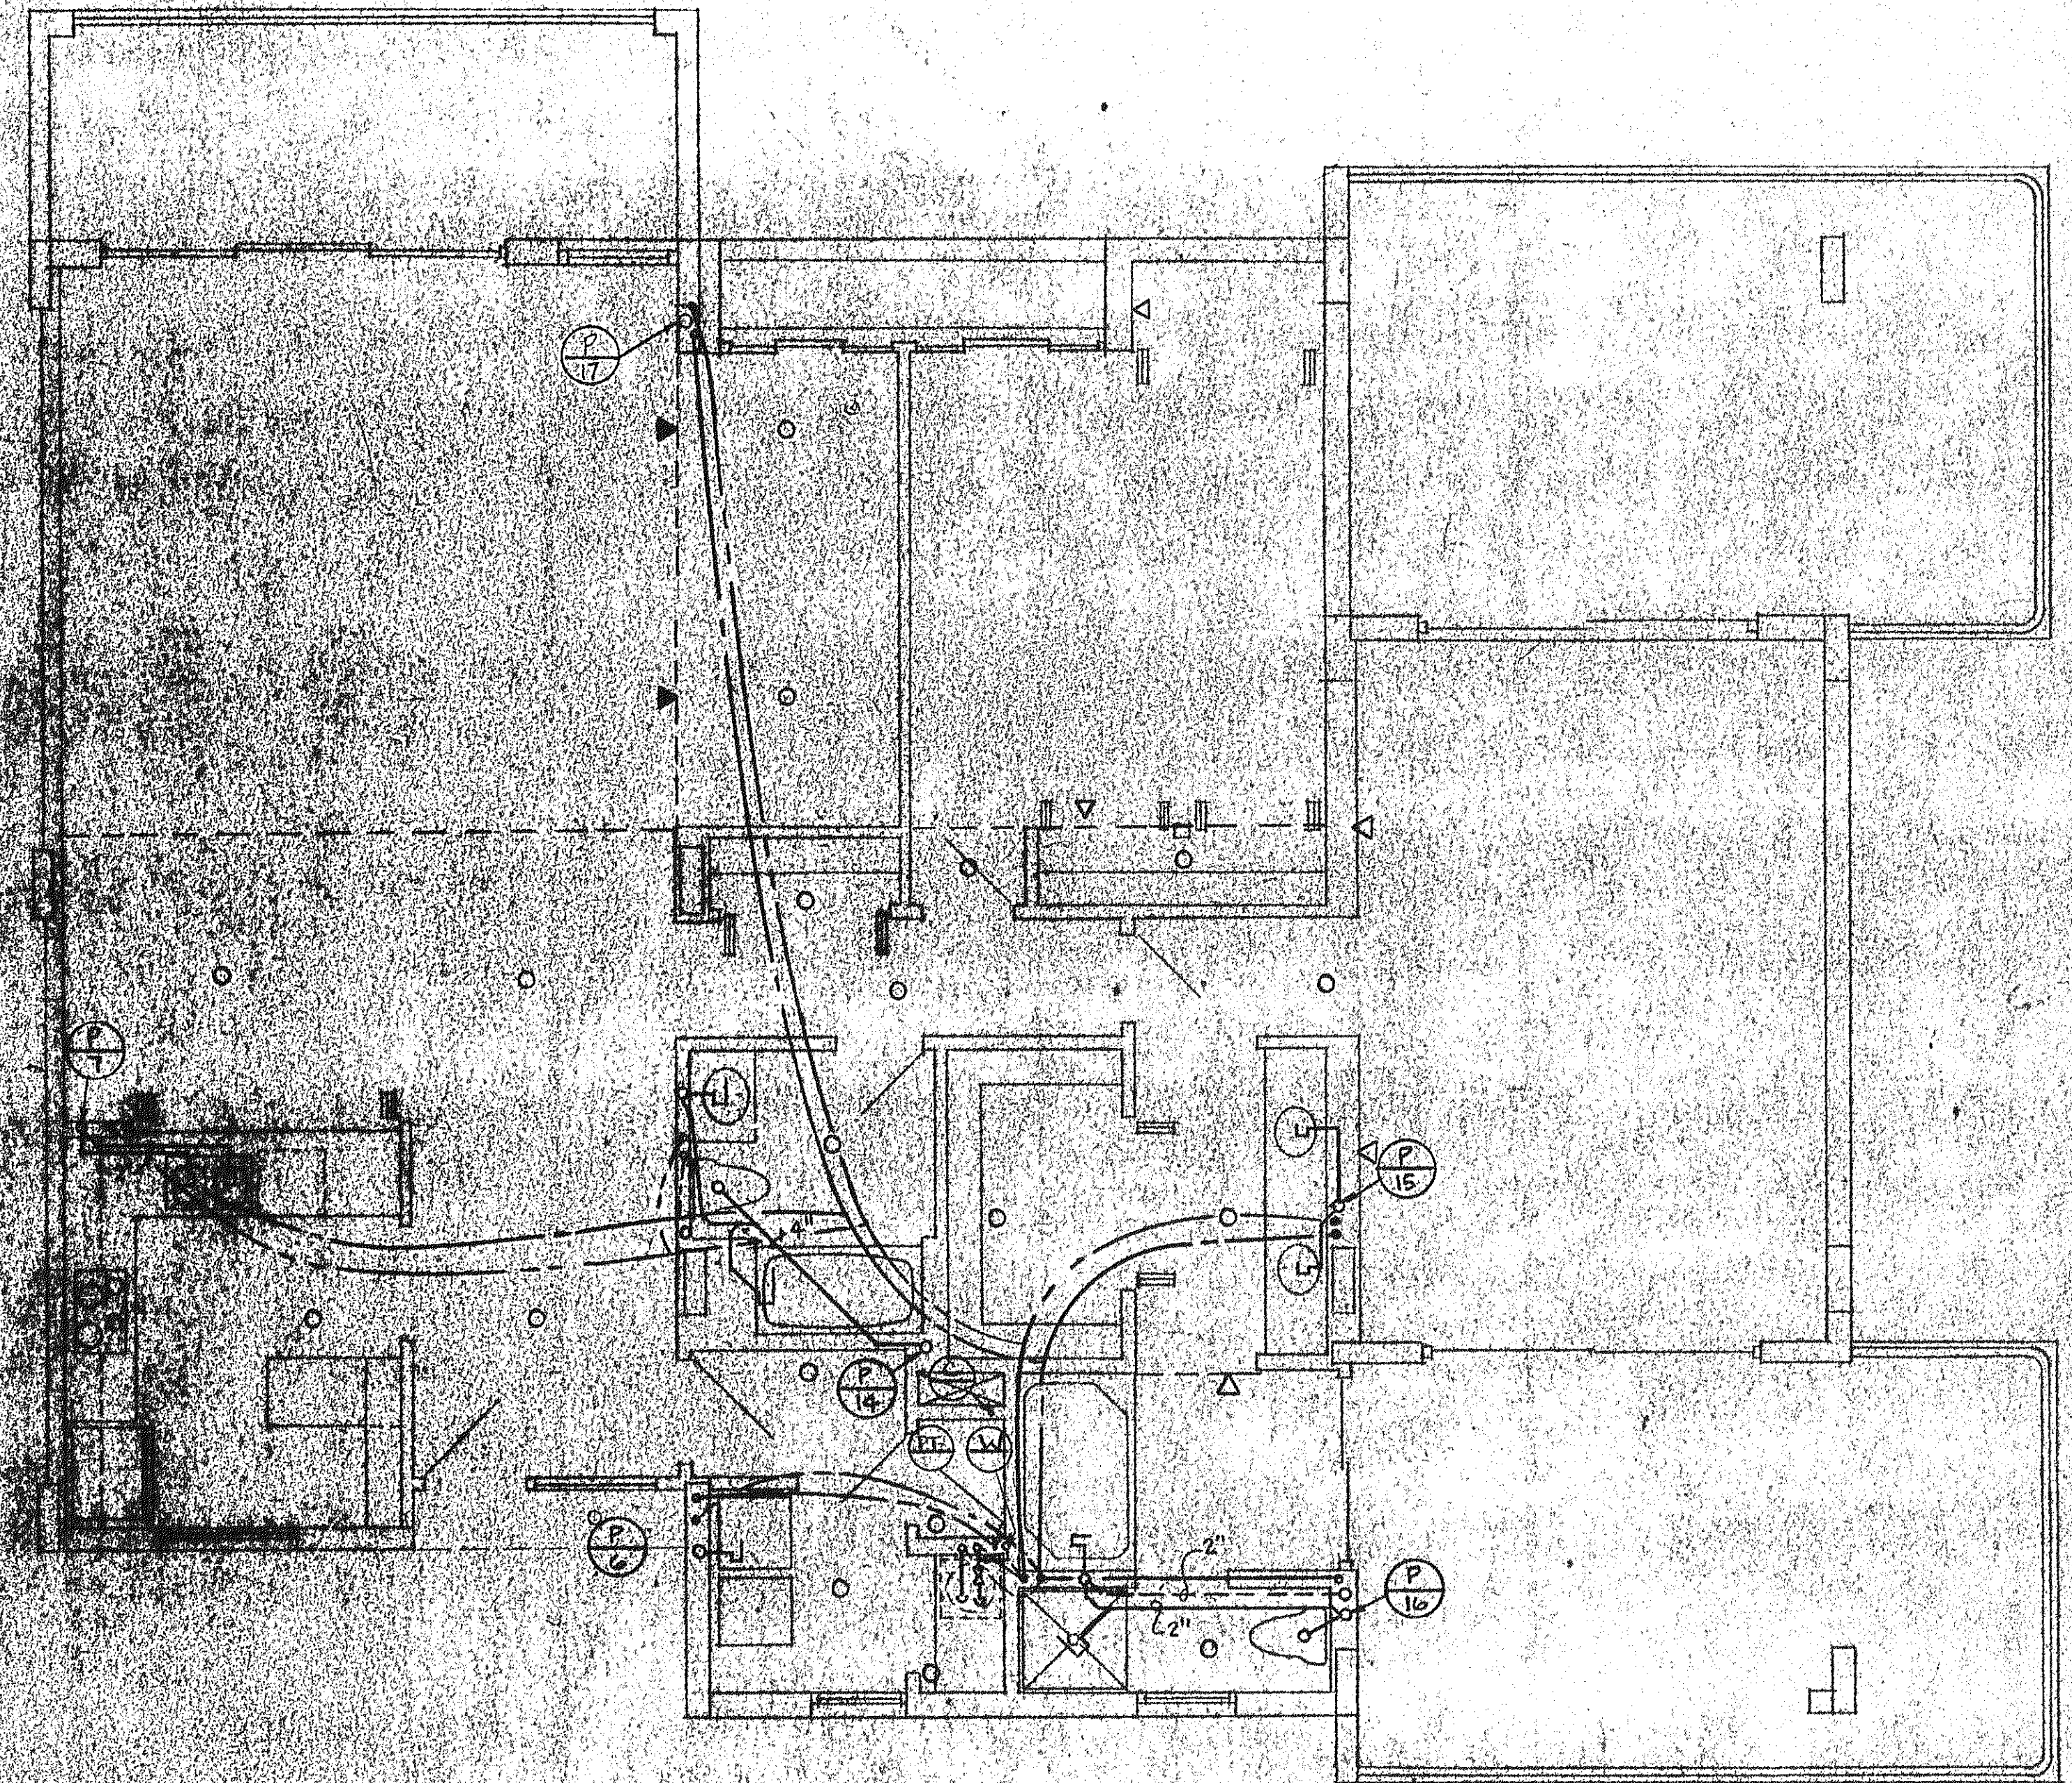

UNIT "D" MOD. RIGHT - PLUMBING PLAN

Scale: 1/4" = 1'-0"

ISSUED
4-1-5

REVISED

SHEET
P-8

BLDG: 3
OF

SUNSET BEACH
LONG BOAT KEY

ARVIDA CORPORATION EDWARD J. SEBERT AIA ARCHITECT & PLANNER P.A. THE SWA GROUP
BRABHAM KURNG DEBBY CONSULTING ENGINEERS OLSEN WHITE & ASSOCIATES STRUCTURAL ENGINEERS BENNETT & BISHOP INC. CONSULTING ENGINEERS & SURVEYORS