

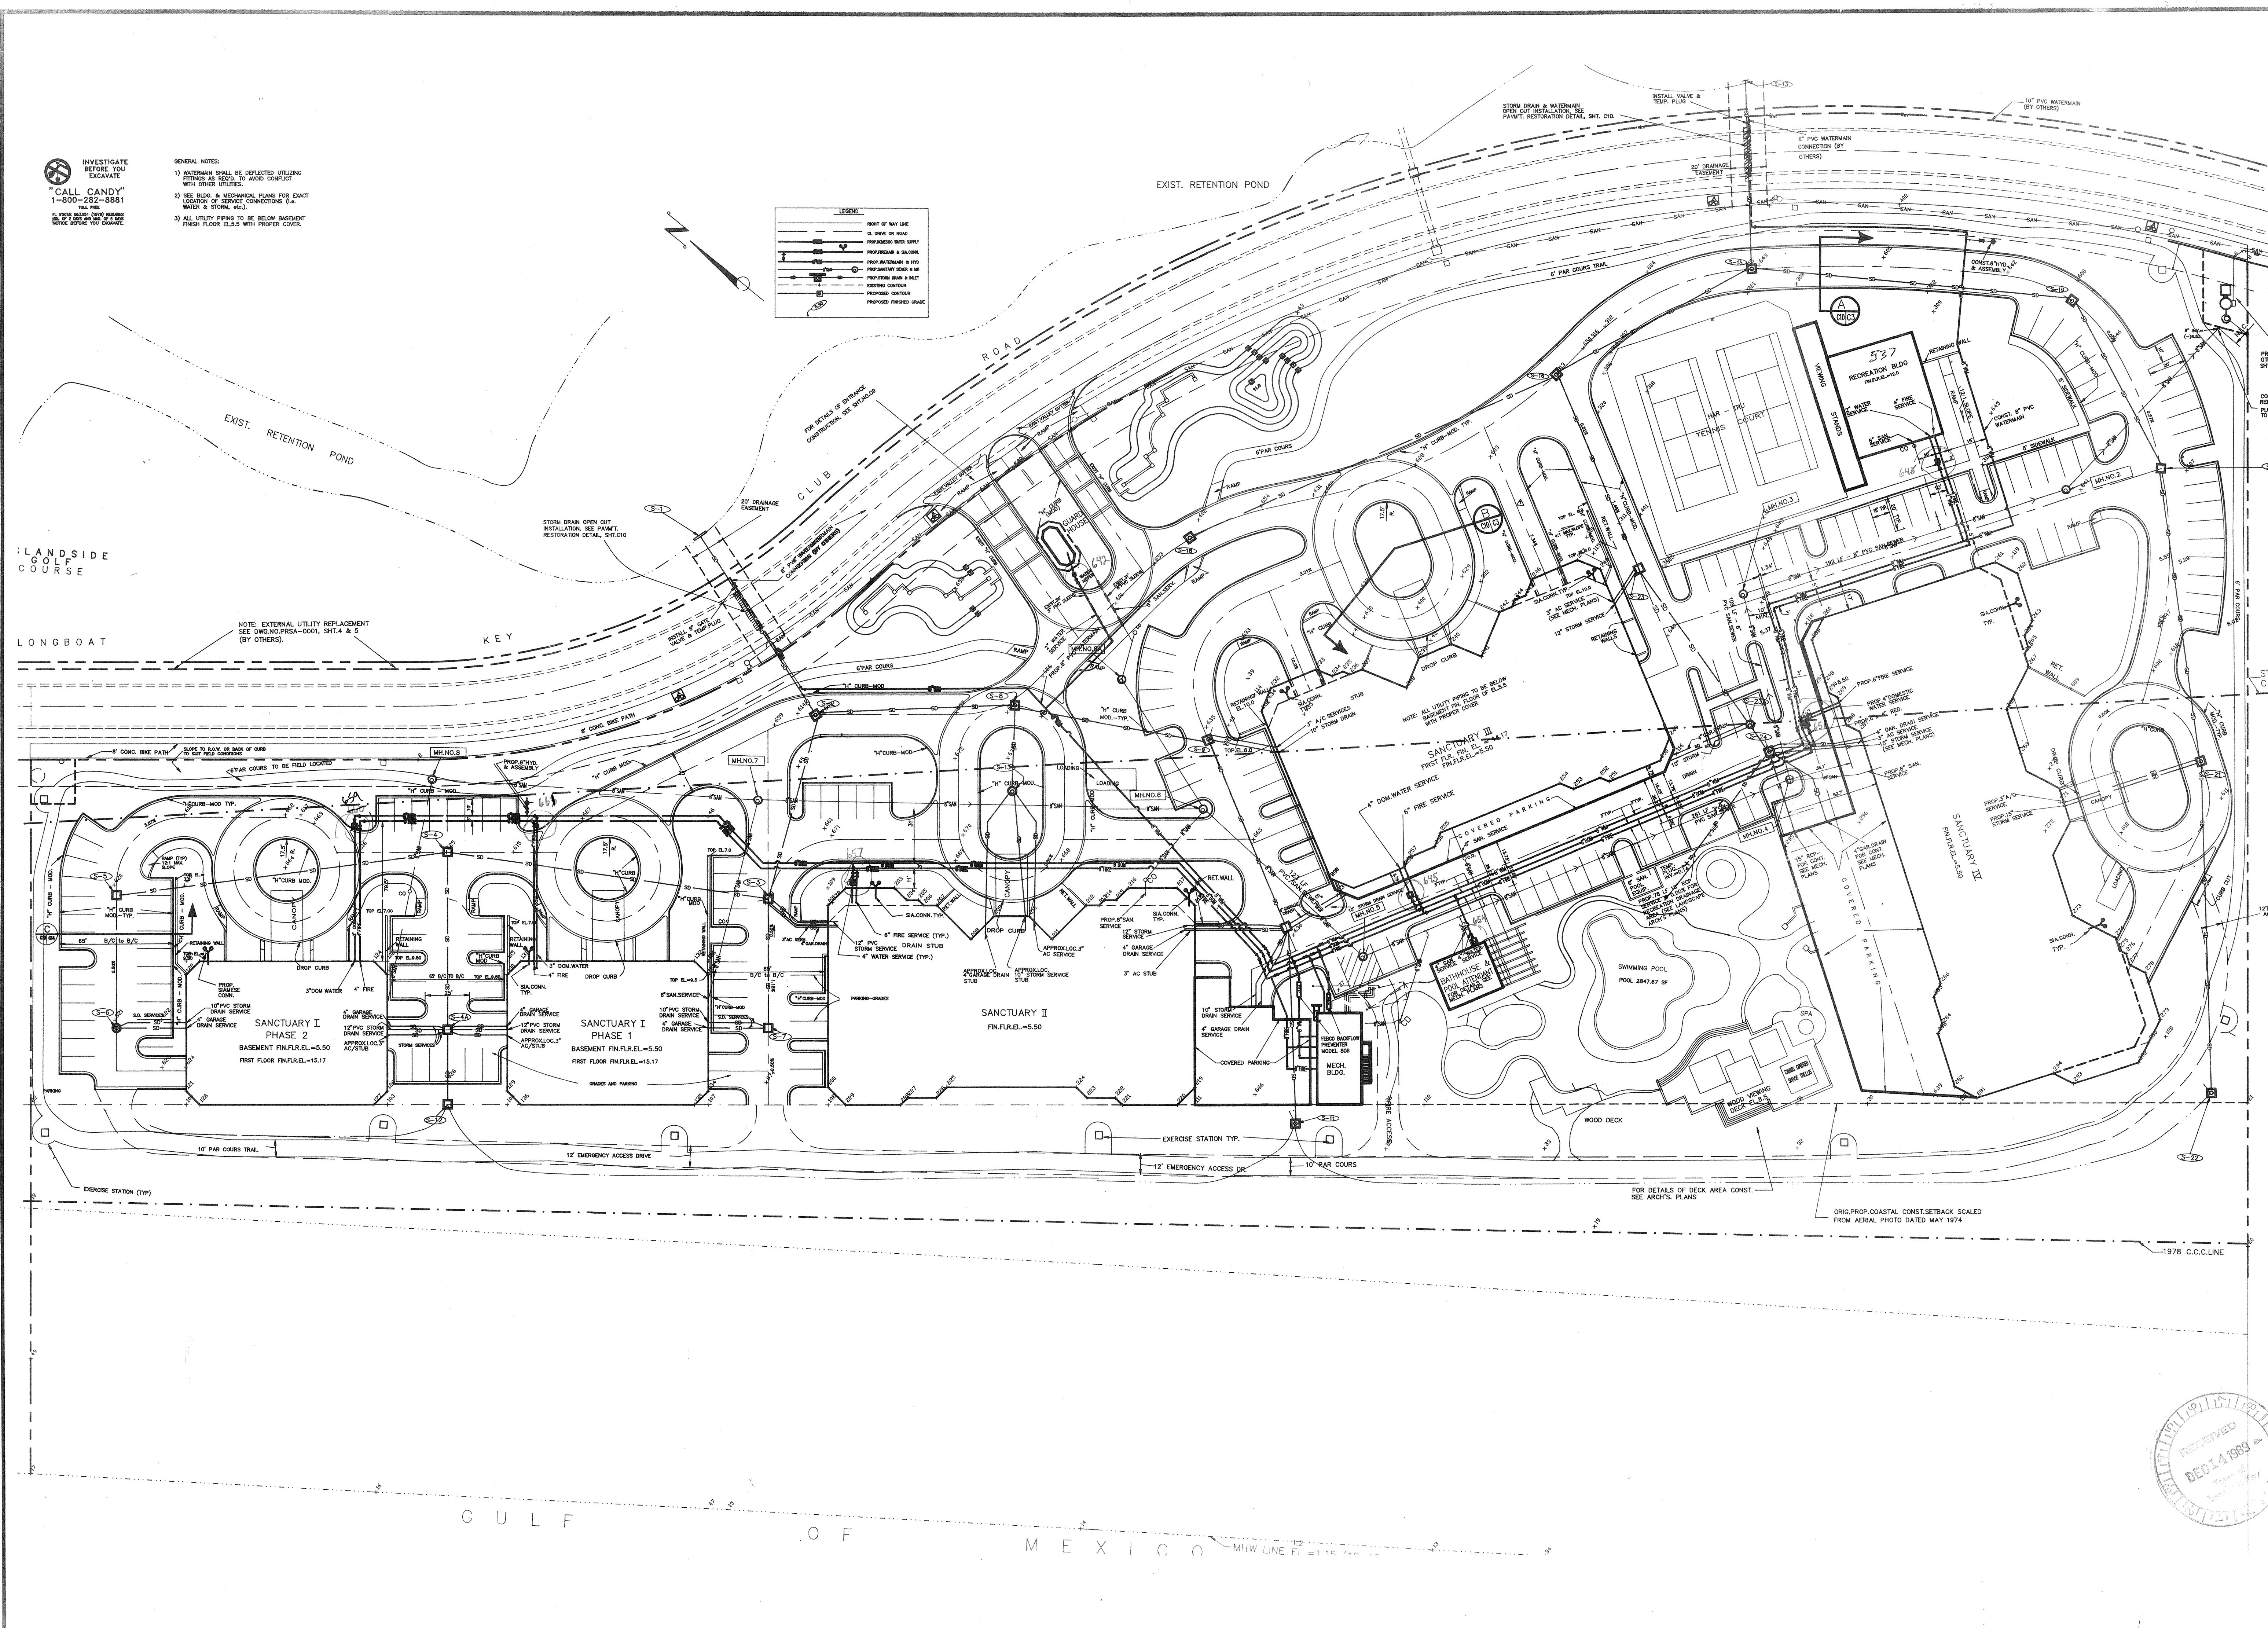


INVESTIGATE BEFORE YOU EXCAVATE
"CALL CANDY"
 1-800-282-8881
 THE FEE IS NON-REFUNDABLE. IF YOU DO NOT CALL BEFORE YOU EXCAVATE.

- GENERAL NOTES:
- 1) WATERMAIN SHALL BE DEFLECTED UTILITIES FITTINGS AS NEAR TO ROAD CURB/STREET WITH OTHER UTILITIES.
 - 2) SEE BLDG. & MECHANICAL PLANS FOR EXACT LOCATION OF SERVICE CONNECTIONS (I.A. MAINS & STORM, W.S.).
 - 3) ALL UTILITIES SHOWN TO BE BELOW BASEMENT FINISH FLOOR E.L.S. WITH PROPER COVER.

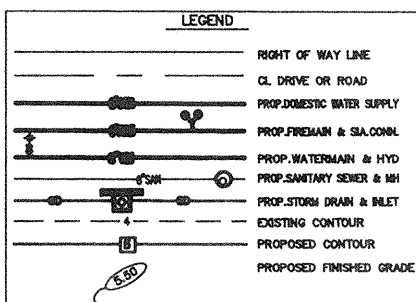

DESIGNED BY D. JOLLES	PROJECT ENGINEER
DATE: 12-13-89	SCALE: 1" = 40'
CHECKED BY P. LUCKLA	DRAWN BY P. LUCKLA
PROJECT NO. YALE-0001-10	REVISION
L.T.R. DATE	DATE
TOWN OF LONGBOAT KEY, FLORIDA	
THE SANCTUARY - YALE PROPERTIES - UTILITIES AS-BUILT DRAWING	
ENGINEER BISHOP & ASSOCIATES - 78 SARASOTA CENTER BLVD. SARASOTA, FLORIDA 34240 (813) 378-6362	
SHEET NUMBER 1 OF 2	REVISION

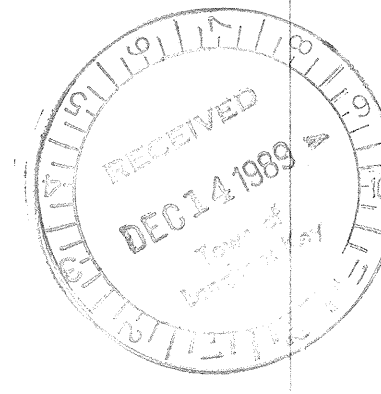

SANCTUARY