


PLAN
SCALE: 1"=20'

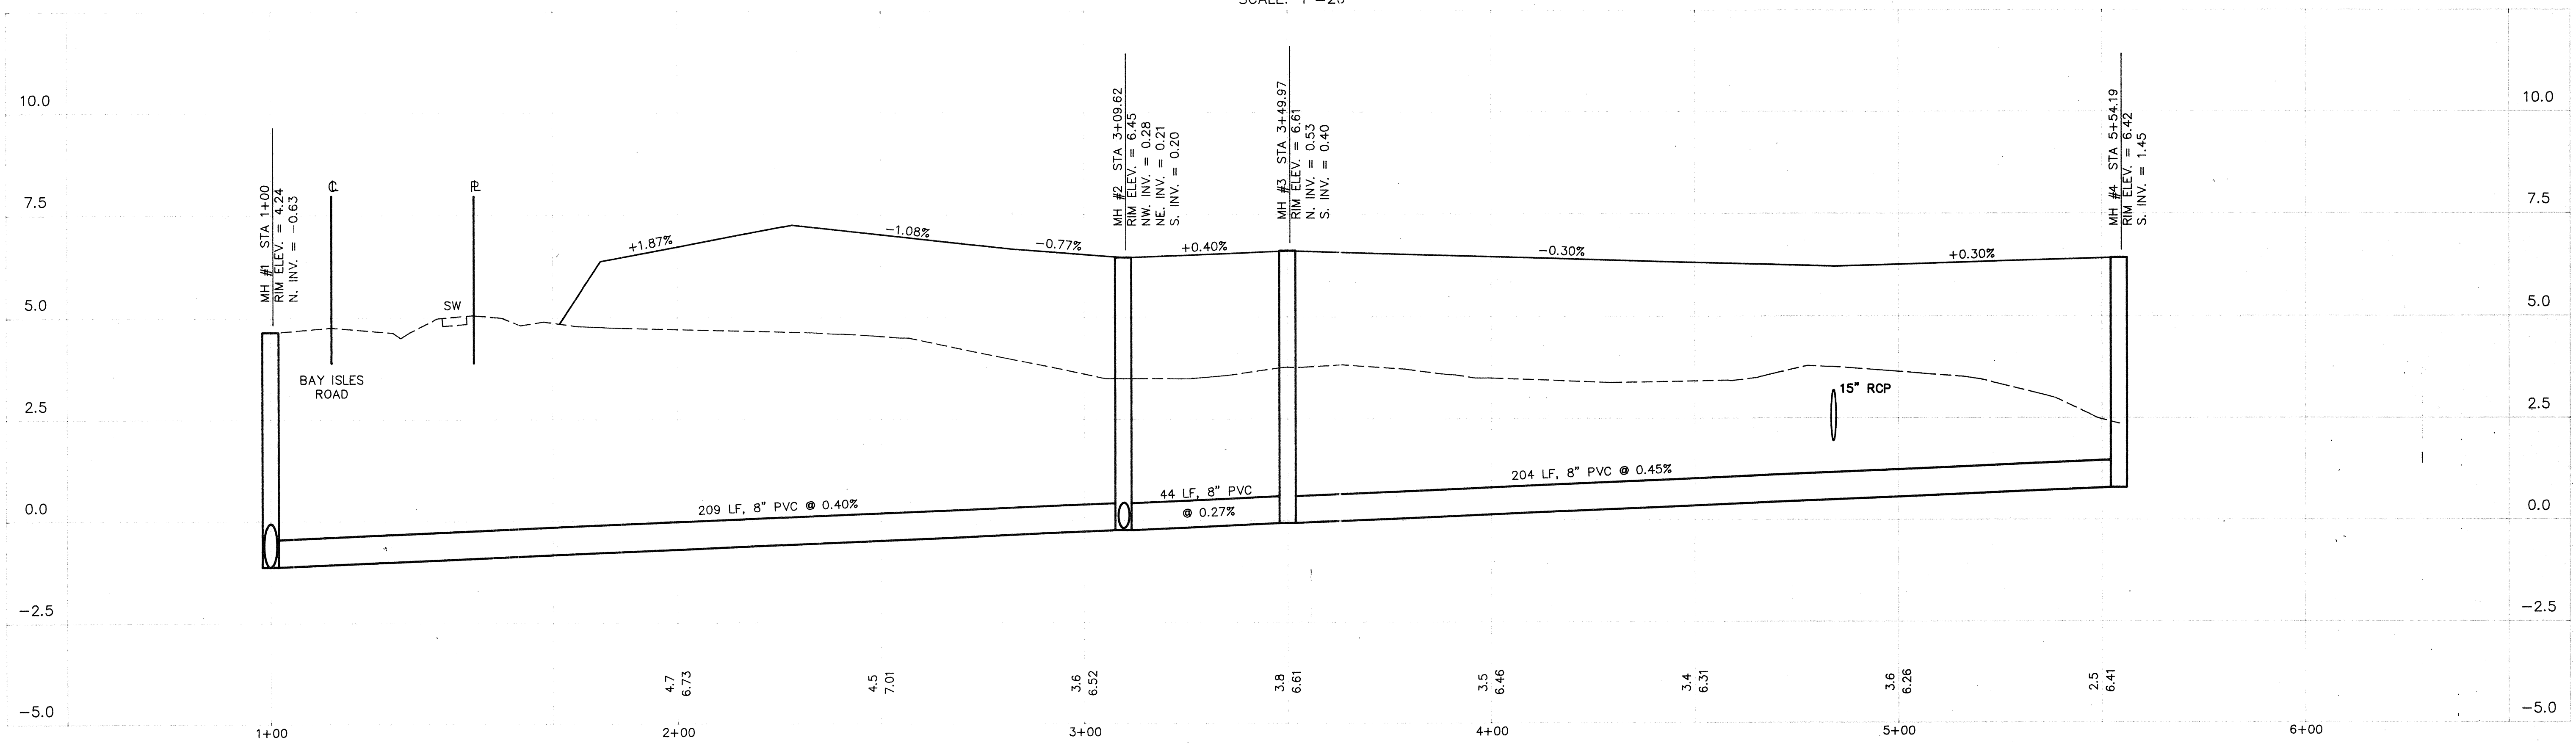

PROFILE
SCALE: HORIZ.: 1"=20'
VERT.: 1"=2'

OWNER GEORGIAN PROPERTIES, LTD. WESTHILL FARM JURBY ROAD RAMSY, ISLE OF MAN	PROJECT NAME WESTON POINTE LONGBOAT KEY, FLORIDA SANITARY PLAN/PROFILE - RECORD DRAWING	NORTH 	SHEET 8	REVISIONS	MINDER & RHODES ENGINEERING CORPORATION <i>Engineers - Planners - Surveyors</i> 3900 CLARK ROAD SARASOTA, FL. 34233 (813) 922-7868 														
				<table border="1" style="width:100%; border-collapse: collapse;"> <thead> <tr> <th style="width:5%;">NO.</th> <th style="width:10%;">DATE</th> <th style="width:50%;">DESCRIPTION</th> <th style="width:10%;">BY</th> </tr> </thead> <tbody> <tr> <td>1</td> <td>5/3/93</td> <td>ADD RECORD DRAWING INFORMATION</td> <td>DBH</td> </tr> </tbody> </table>	NO.	DATE	DESCRIPTION	BY	1	5/3/93	ADD RECORD DRAWING INFORMATION	DBH	<table border="1" style="width:100%; border-collapse: collapse;"> <tr> <td style="width:33%;">Designed M&R</td> <td style="width:33%;">Checked</td> <td style="width:33%;">Approved</td> </tr> <tr> <td>Drawn AJR</td> <td>Scale 1"=20'</td> <td>Date 8/20/92</td> </tr> </table>	Designed M&R	Checked	Approved	Drawn AJR	Scale 1"=20'	Date 8/20/92
NO.	DATE	DESCRIPTION	BY																
1	5/3/93	ADD RECORD DRAWING INFORMATION	DBH																
Designed M&R	Checked	Approved																	
Drawn AJR	Scale 1"=20'	Date 8/20/92																	
				APPROVED P.E. No. 33150 Date 8/20/92 Proj. No. S1088 CAD. DWG. S1088RD1															