


PLAN
SCALE: 1"=20'

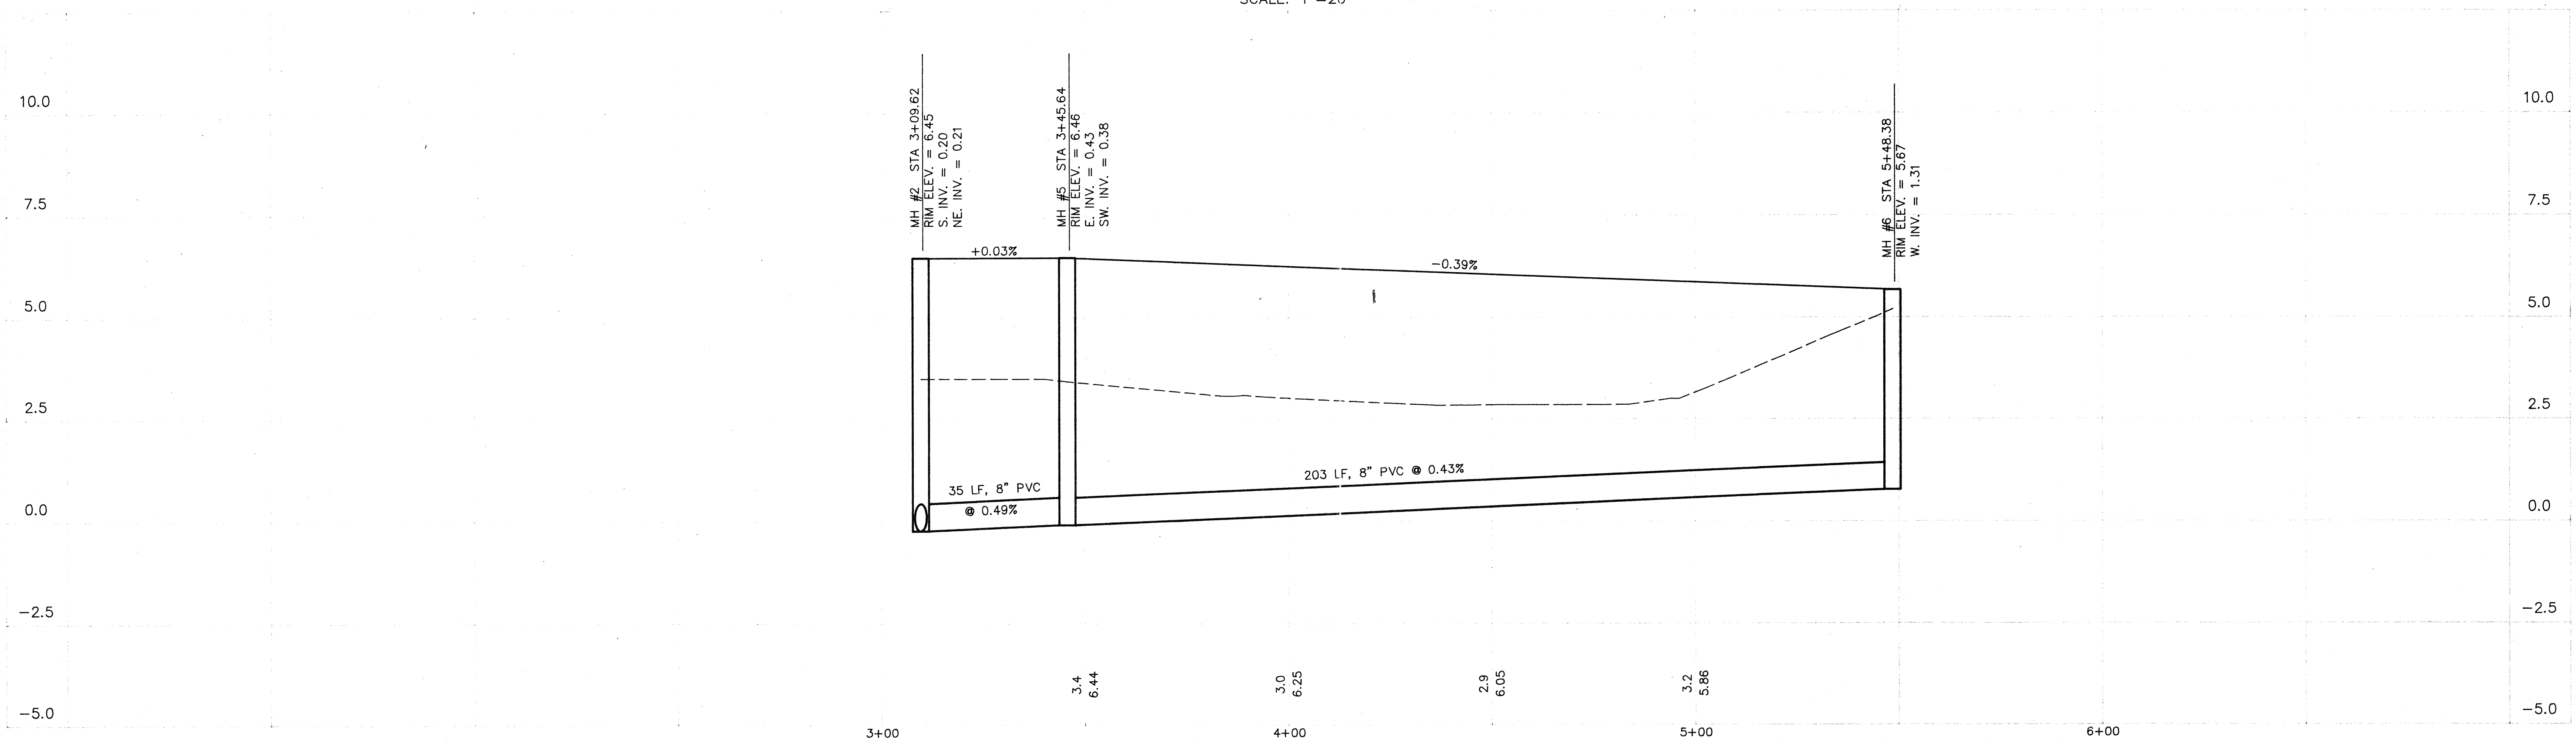

PROFILE
SCALE: HORIZ.: 1"=20'
VERT.: 1"=2'

OWNER GEORGIAN PROPERTIES, LTD. WESTHILL FARM JURBY ROAD RAMSY, ISLE OF MAN	PROJECT NAME WESTON POINTE LONGBOAT KEY, FLORIDA SANITARY PLAN/PROFILE - RECORD DRAWING	NORTH 	SHEET 9	REVISIONS NO. DATE DESCRIPTION BY	MINDER & RHODES ENGINEERING CORPORATION Engineers - Planners - Surveyors 3900 CLARK ROAD SARASOTA, FL, 34233 (813) 922-7845 Approved: P.E. No. 33275 Date: 8/20/92 Drawn: AJR Scale: 1"=20' Date: 8/20/92 CAD DWG: S1088RD2
--	--	-----------	-------------------	--------------------------------------	---