


PLAN
SCALE: 1"=20'

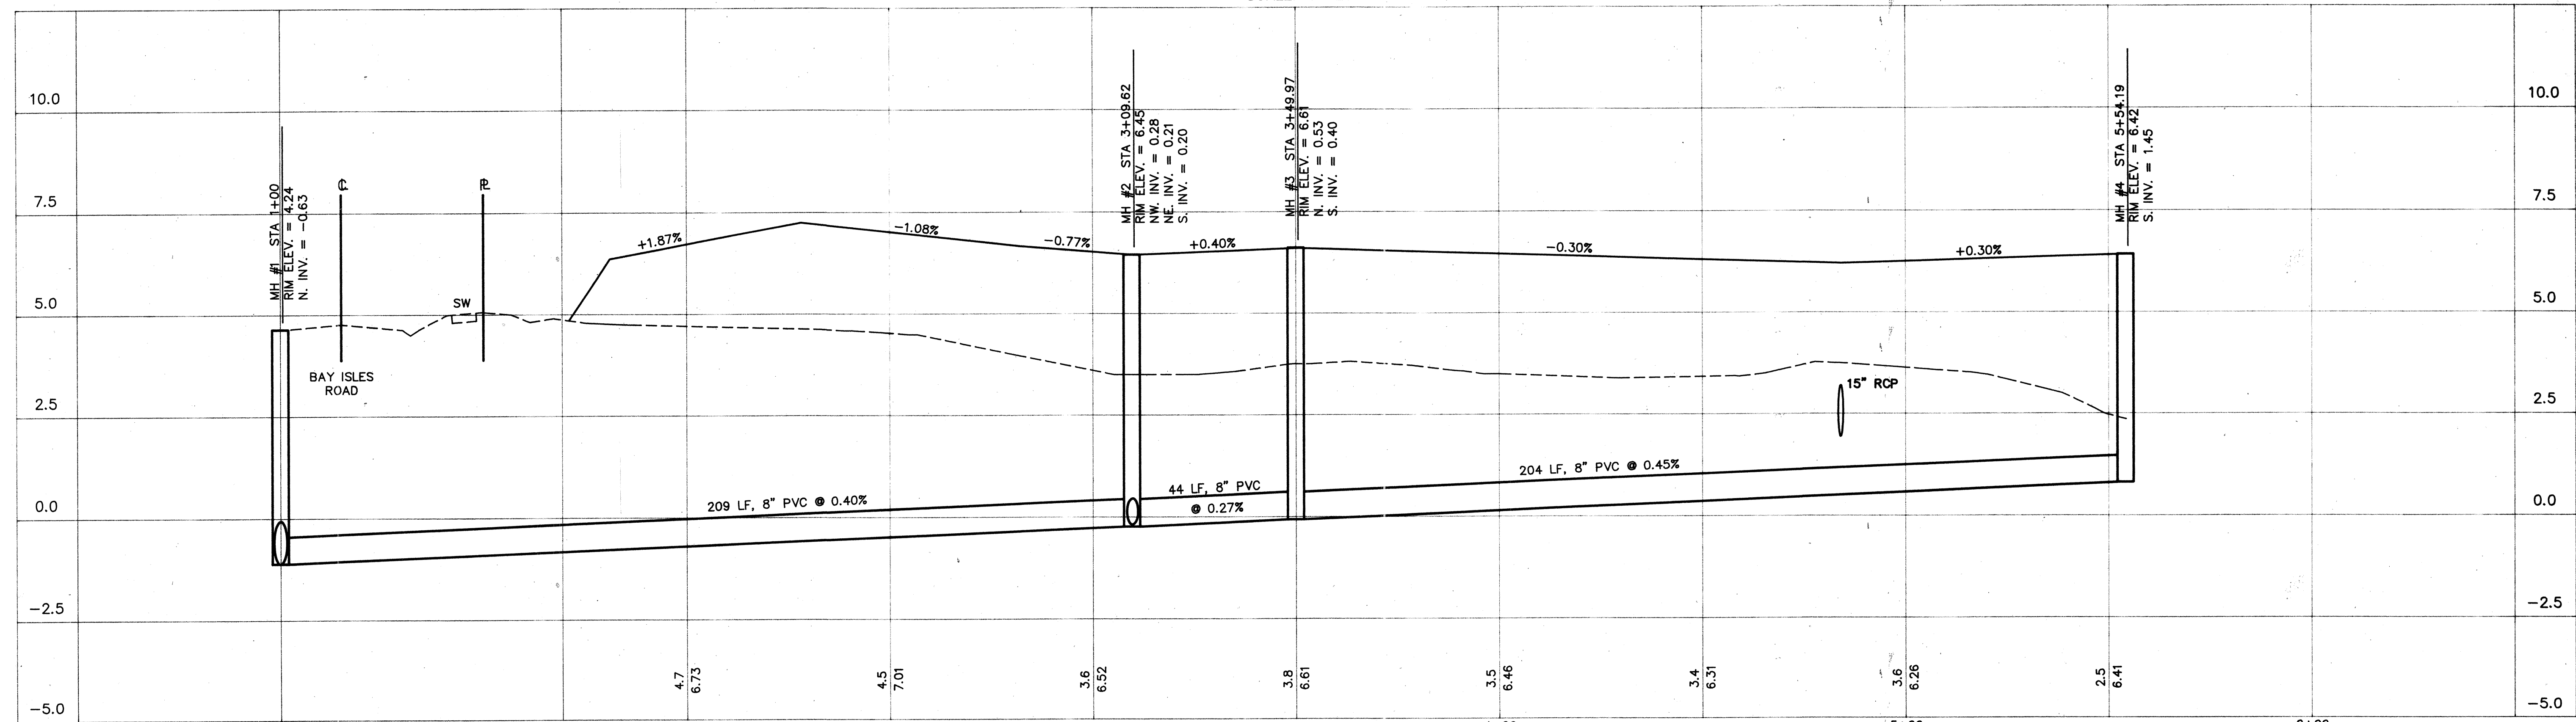

PROFILE
SCALE: HORIZ.: 1"=20'
VERT.: 1"=2'

OWNER GEORGIAN PROPERTIES, LTD. WESTHILL FARM JURBY ROAD RAMSY, ISLE OF MAN	PROJECT NAME WESTON POINTE LONGBOAT KEY, FLORIDA SANITARY PLAN/PROFILE - RECORD DRAWING	NORTH 	SHEET 8	REVISIONS	MINDER & RHODES ENGINEERING CORPORATION <i>Engineers - Planners - Surveyors</i> 3900 CLARK ROAD SARASOTA, FL 34233 (941) 552-7844 Designed M&R Checked Approved Drawn AJR Scale 1"=20' Date 8/20/92
				1 5/3/93 ADD RECORD DRAWING INFORMATION DBH NO. DATE DESCRIPTION BY	APPROVED P.E. No. 33160 Date 12/10/93 Prj. No. S1088 CAD DWG. S1088RD1