



EXISTING	PROPOSED	UTILITY
WM	WM	WATER MAIN w/ FIRE HYDRANT
FM	FM	SANITARY FORCE MAIN
SM	SM	SANITARY SEWER w/MANHOLE
SD	SD	STORM DRAIN
BE	BE	BURIED ELECTRIC CABLE
OE	OE	OVERHEAD ELECTRIC CABLE
BT	BT	BURIED TELEPHONE CABLE
OT	OT	OVERHEAD TELEPHONE CABLE
GM	GM	BURIED GAS MAIN

INVESTIGATE BEFORE YOU EXCAVATE


"CALL CANDY"
1-800-282-8881
TOLL FREE

FL. STATUTE 553.851 (1979) REQUIRES MIN. OF 2 DAYS AND MAX. OF 5 DAYS NOTICE BEFORE YOU EXCAVATE.

ALSO NOTIFY:
FPL 953-7265
GTE (SYKES ENTERPRISES) 1-800-628-3103
TOWN OF LONGBOAT KEY 383-3721

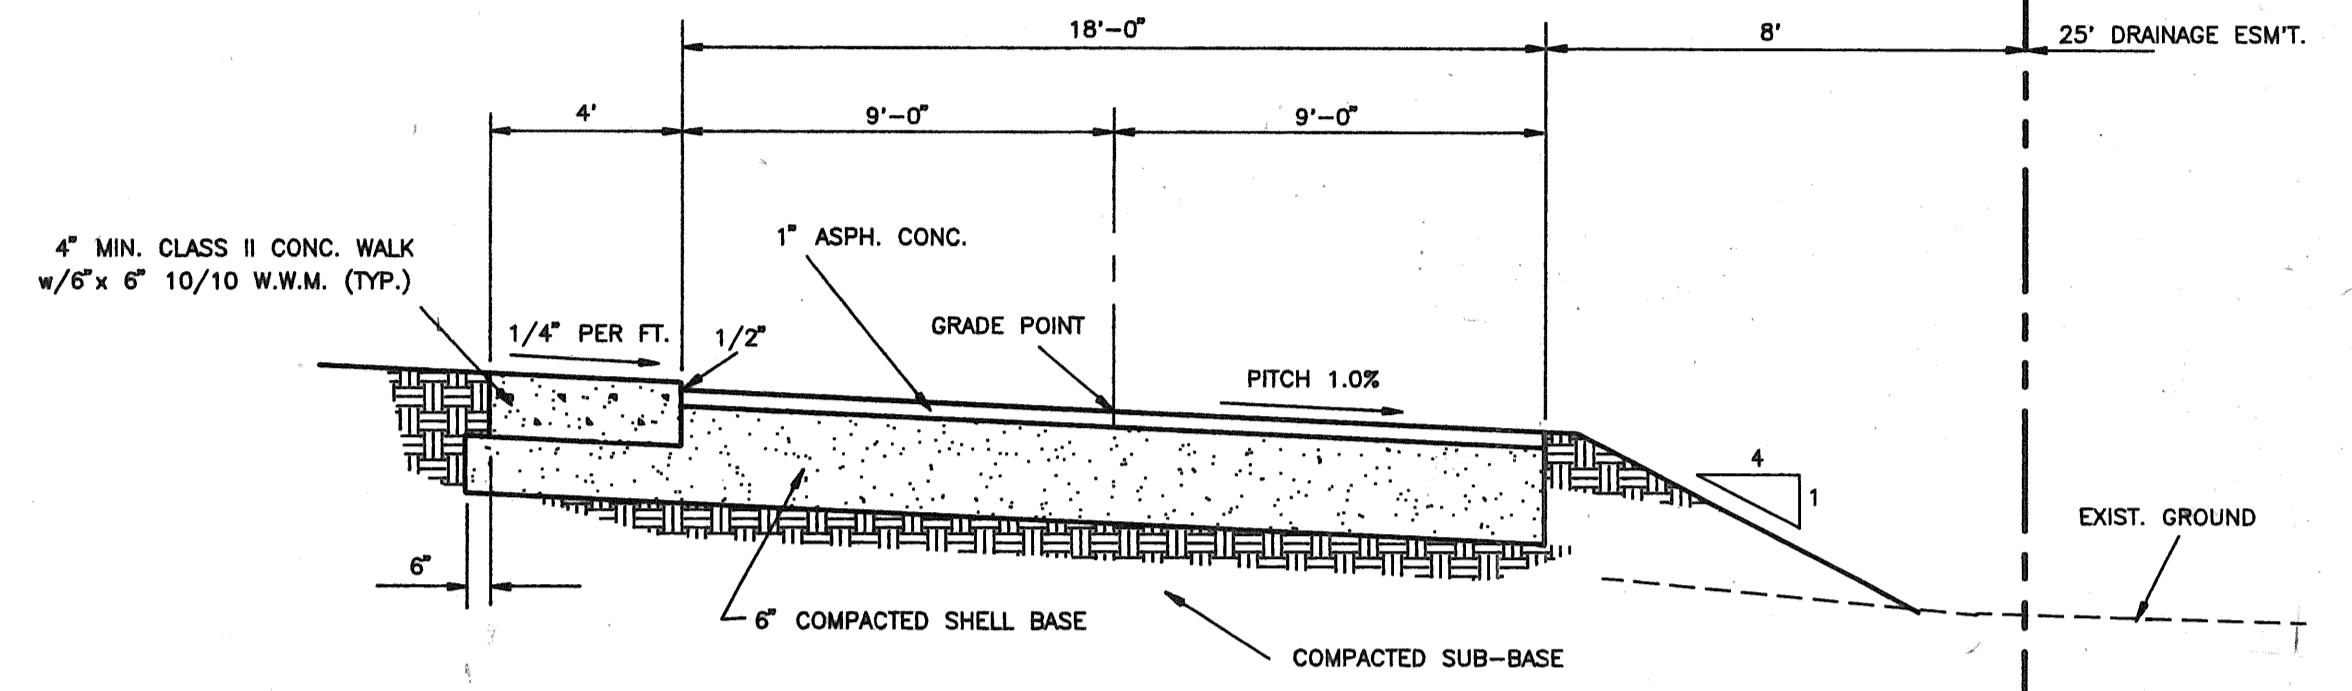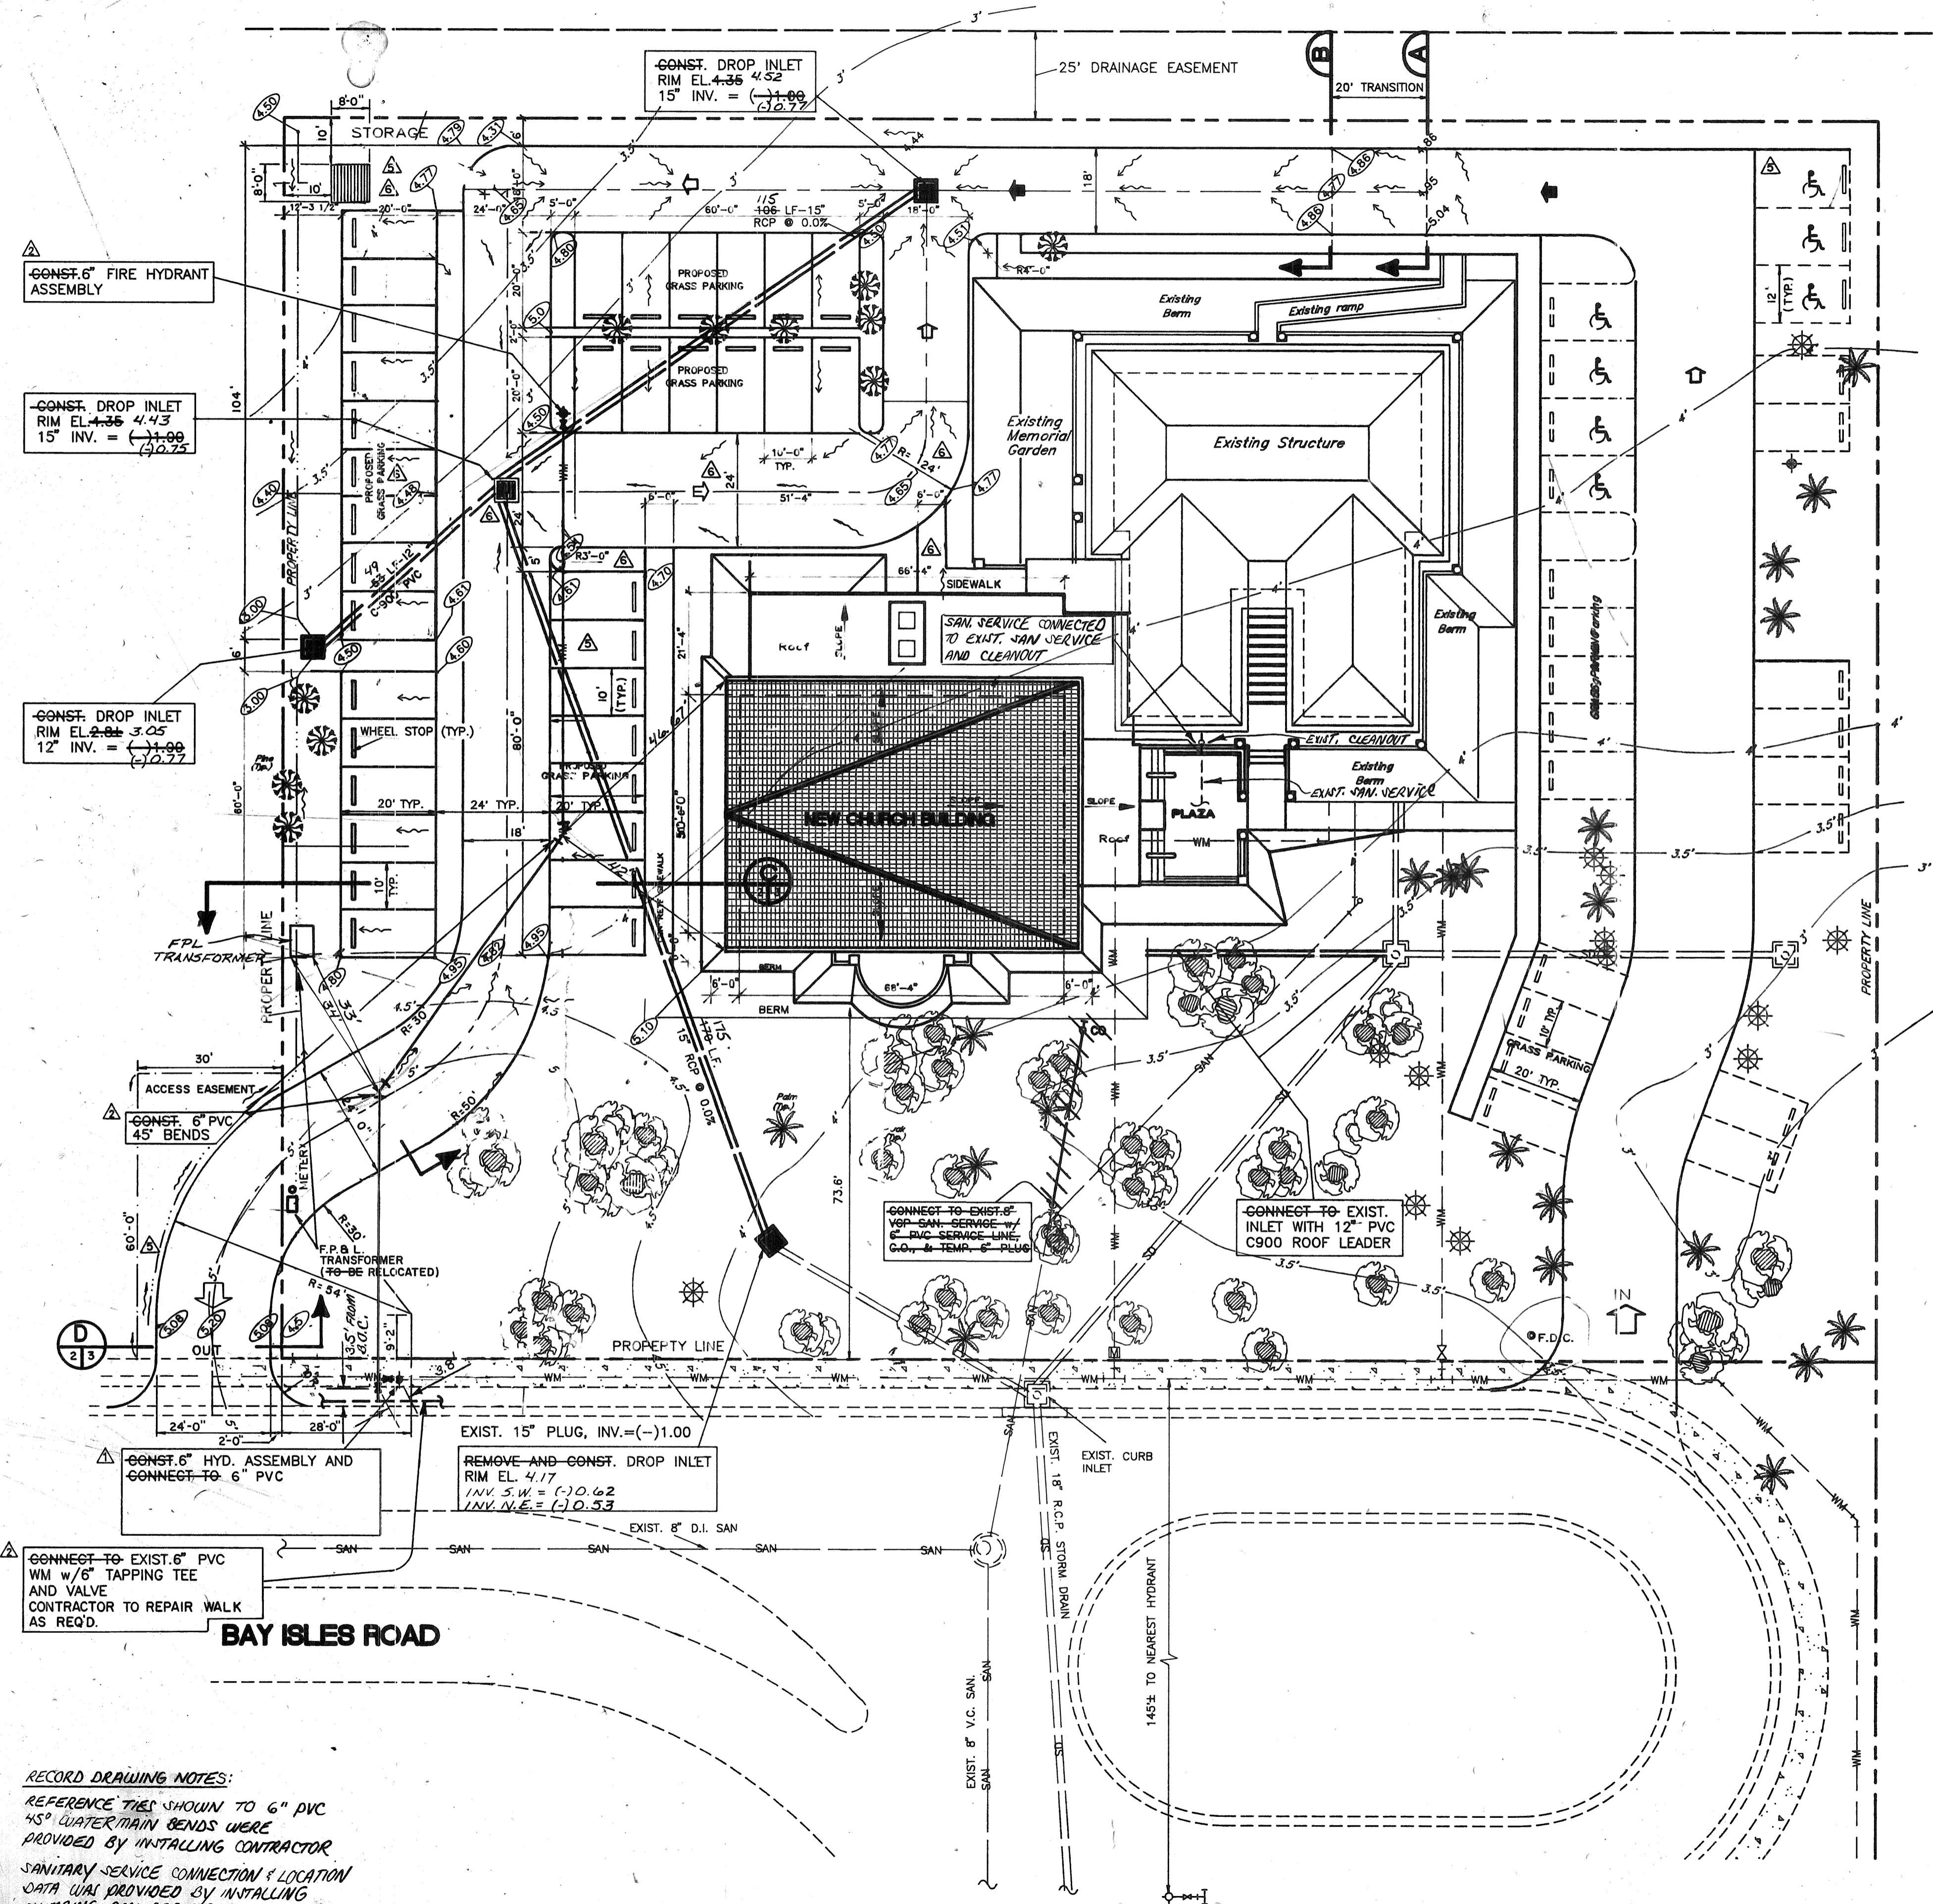

EXIST. ROAD SECTION A

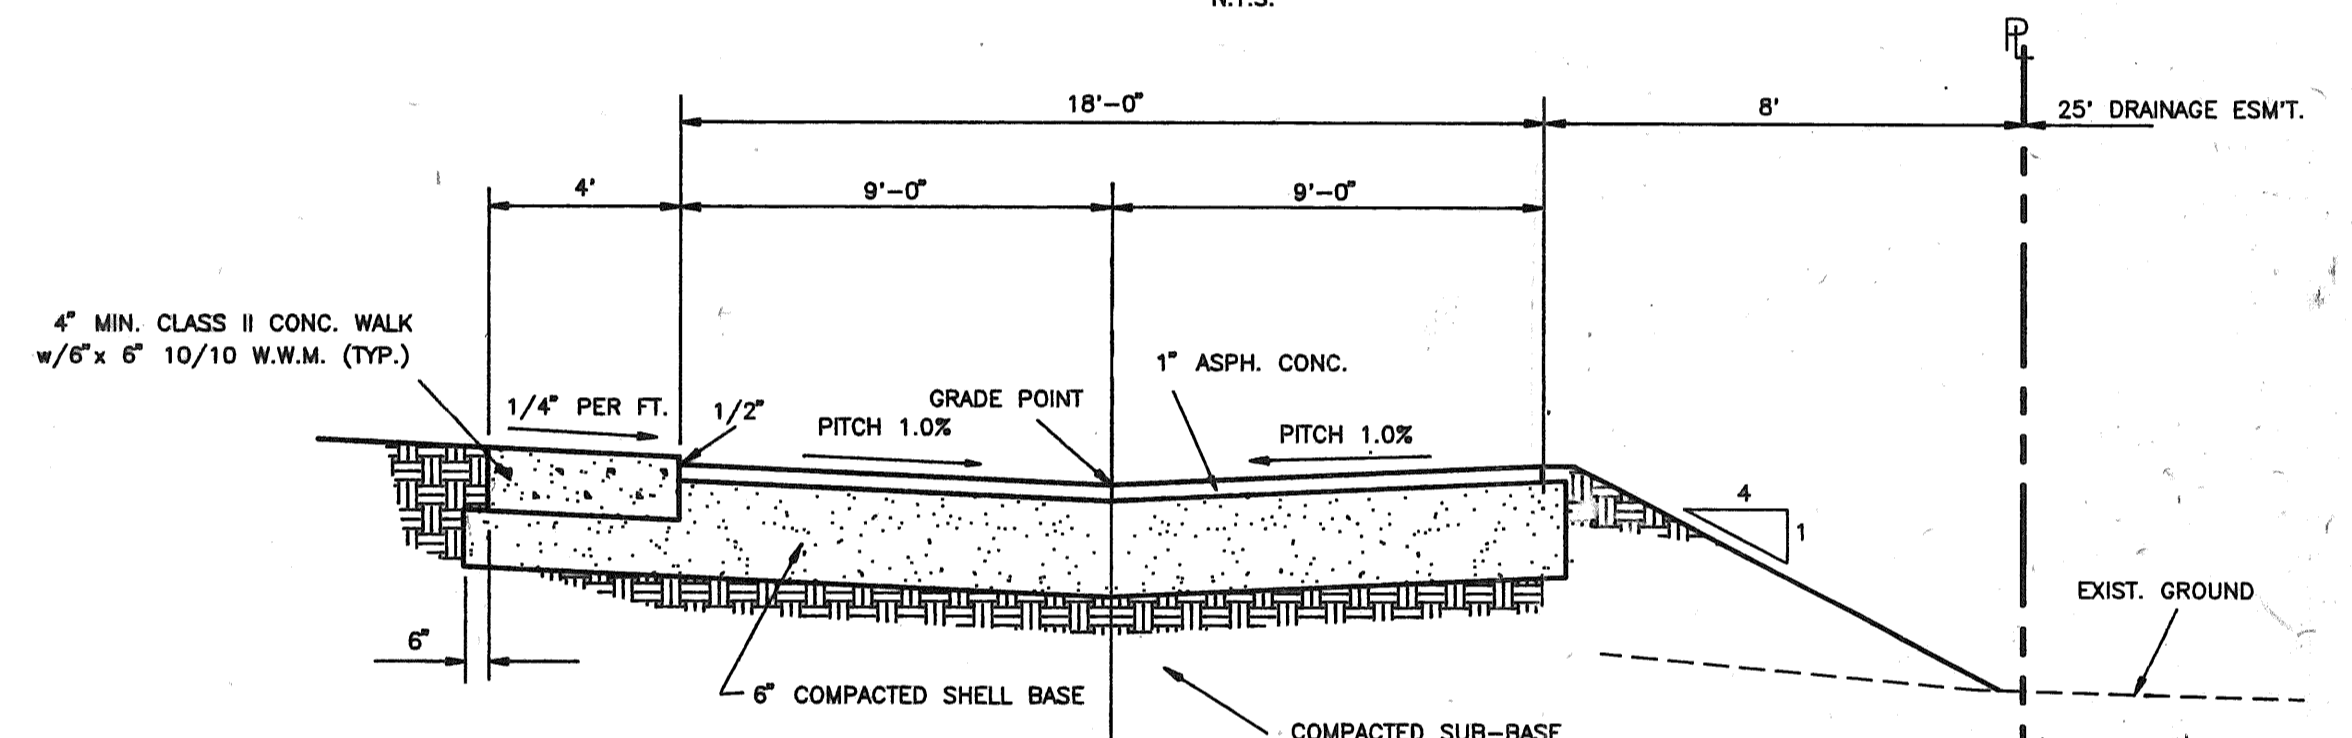

PROP. ROAD SECTION B

SITE PLAN AMENDMENT DATA

	PREVIOUSLY APPROVED	PROPOSED AMENDMENT
1. SITE AREA	2.0 ACRES	2.0 ACRES
2. SOCIAL HALL (EXISTING)	3,998 S.F.	3,998 S.F.
3. CHURCH (PROPOSED)	4,275 S.F.	4,350 S.F.
4. SOCIAL HALL HEIGHT/STORIES	32'/1	32'/1
5. CHURCH HEIGHT/STORIES	40'/1	40'/1
6. PARKING 140 SEATS/3 = 47 REQ'D.	59 SPACES	59 SPACES
7. SITE COVERAGE	ACRES/S.F./%	ACRES/S.F./%
A) SOCIAL HALL & CHURCH	0.19/8273/9.50	0.19/8348/9.58
B) PAVED PARKING, DRIVES, & WALKS	0.46/20,000/22.95	0.39/18,283/19.31
C) GRASS PARKING	0.25/10,000/12.40	0.28/12,000/13.32
D) LANDSCAPING & OPEN SPACE	1.10/48,047/55.15	1.14/50,489/57.79
8. FLOOD ZONE (FEMA) A13, ELEVATION 11, DATUM N.G.V.D.		

RECORD DRAWING NOTES:

1. REFERENCE TIES SHOWN TO 6" PVC 45° WATER MAIN BENDS WERE PROVIDED BY INSTALLING CONTRACTOR

2. SANITARY SERVICE CONNECTION & LOCATION DATA WAS PROVIDED BY INSTALLING PLUMBING CONTRACTOR

FIELD BOOK NO. _____
PAGE _____
DATE 3/15/92
CAD FILE: SEAZ19C
P.O. #: _____

BISHOP & ASSOCIATES
Consulting Engineers - Surveyors
AN EMPLOYEE OWNED COMPANY
78 SARASOTA CENTER BLVD., SARASOTA, FLORIDA 34240
813/371-8362 • Fax 813/378-3215

BY	DATE	Q.C.	DATE	DESCRIPTION
PL	3/30/93			
RWC	3/31/93			
RWC	2/16/93	OKL	2/16/93	ADDED RECORD SAN. SERVICE CONNECTION LOCATION
PSN	1/28/93			RECORD DRAWING
R.L.	4/02/93			REV. DRIVE, C.B., SIDEWALK, GRASS PARKING & STORAGE

BY	DATE	Q.C.	DATE	DESCRIPTION
PL	3/30/93			
RWC	3/31/93			
RWC	2/16/93	OKL	2/16/93	DEL FIRE SERVICE FROM BAY ISLES ROAD
PSN	1/28/93			REV PLAN PER ARCH. DRAWING
RWC	7/18/92			ADDED 6" FHYD. & 6" PVC WM w/ CALLOUTS
				ADDED NOTES

TASK	INITIALS	DATE
DESIGN	RWC	3/15/92
DRAWN	RWC	3/15/92
CHECKED		
QUALITY CONTROL		
SCALE	1" = 20'	

RECORD DRAWING

CLIENT/TITLE: **ALL ANGELS BY THE SEA**
ALL ANGELS BY THE SEA, EPISCOPAL CHURCH
DETAIL SITE PLAN

PROJECT NO: **ALL-02**
SHEET NO: **2**