




SECTION ELEV.  
NOT TO SCALE

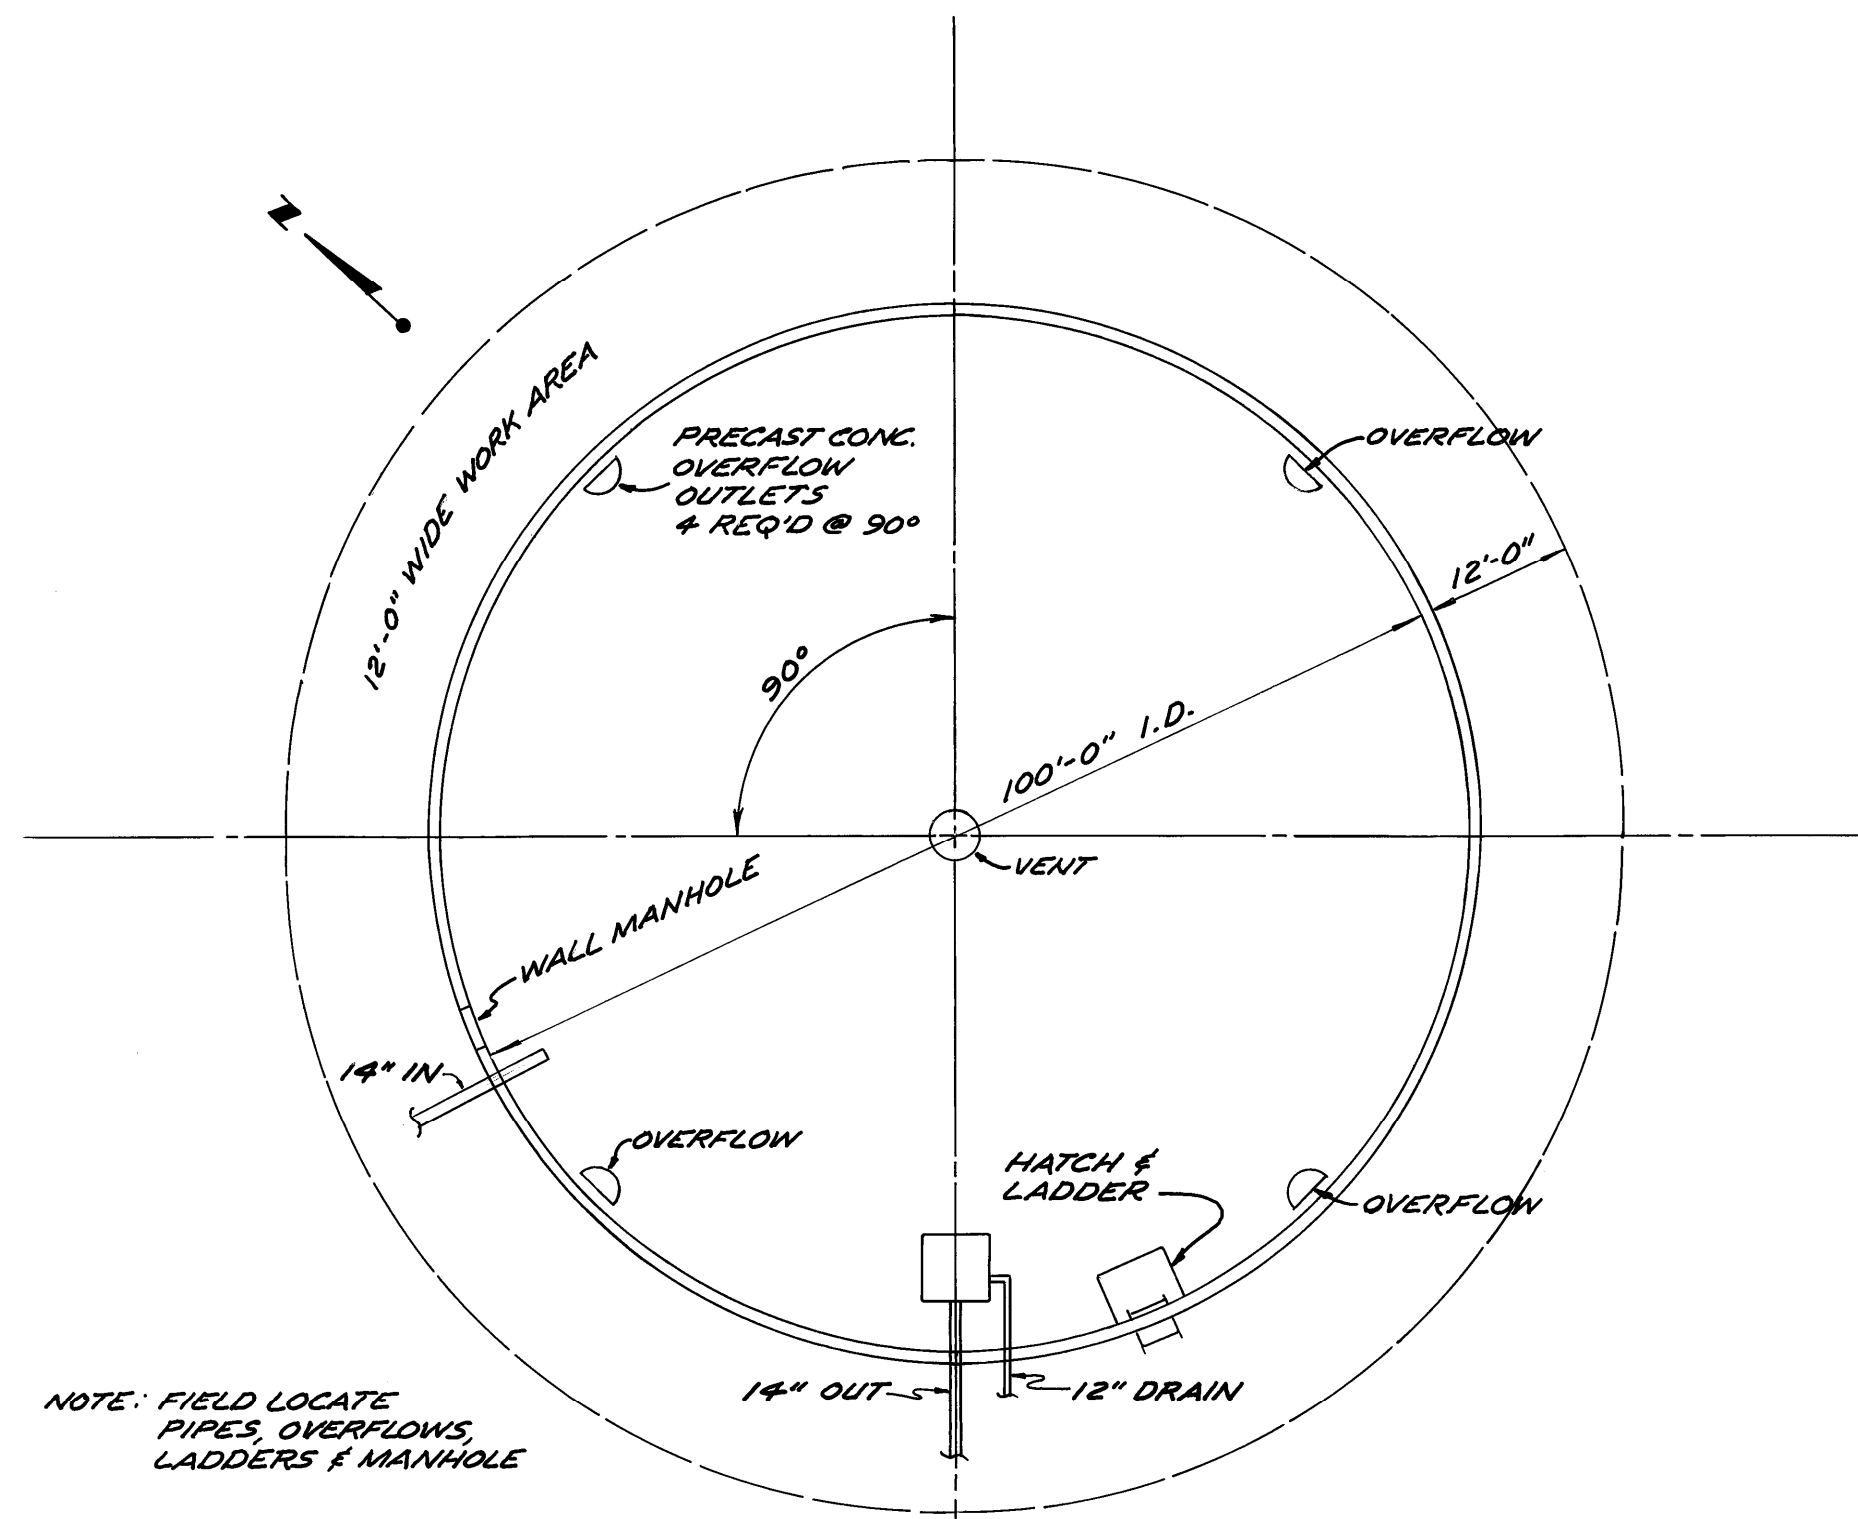

PLAN  
NOT TO SCALE

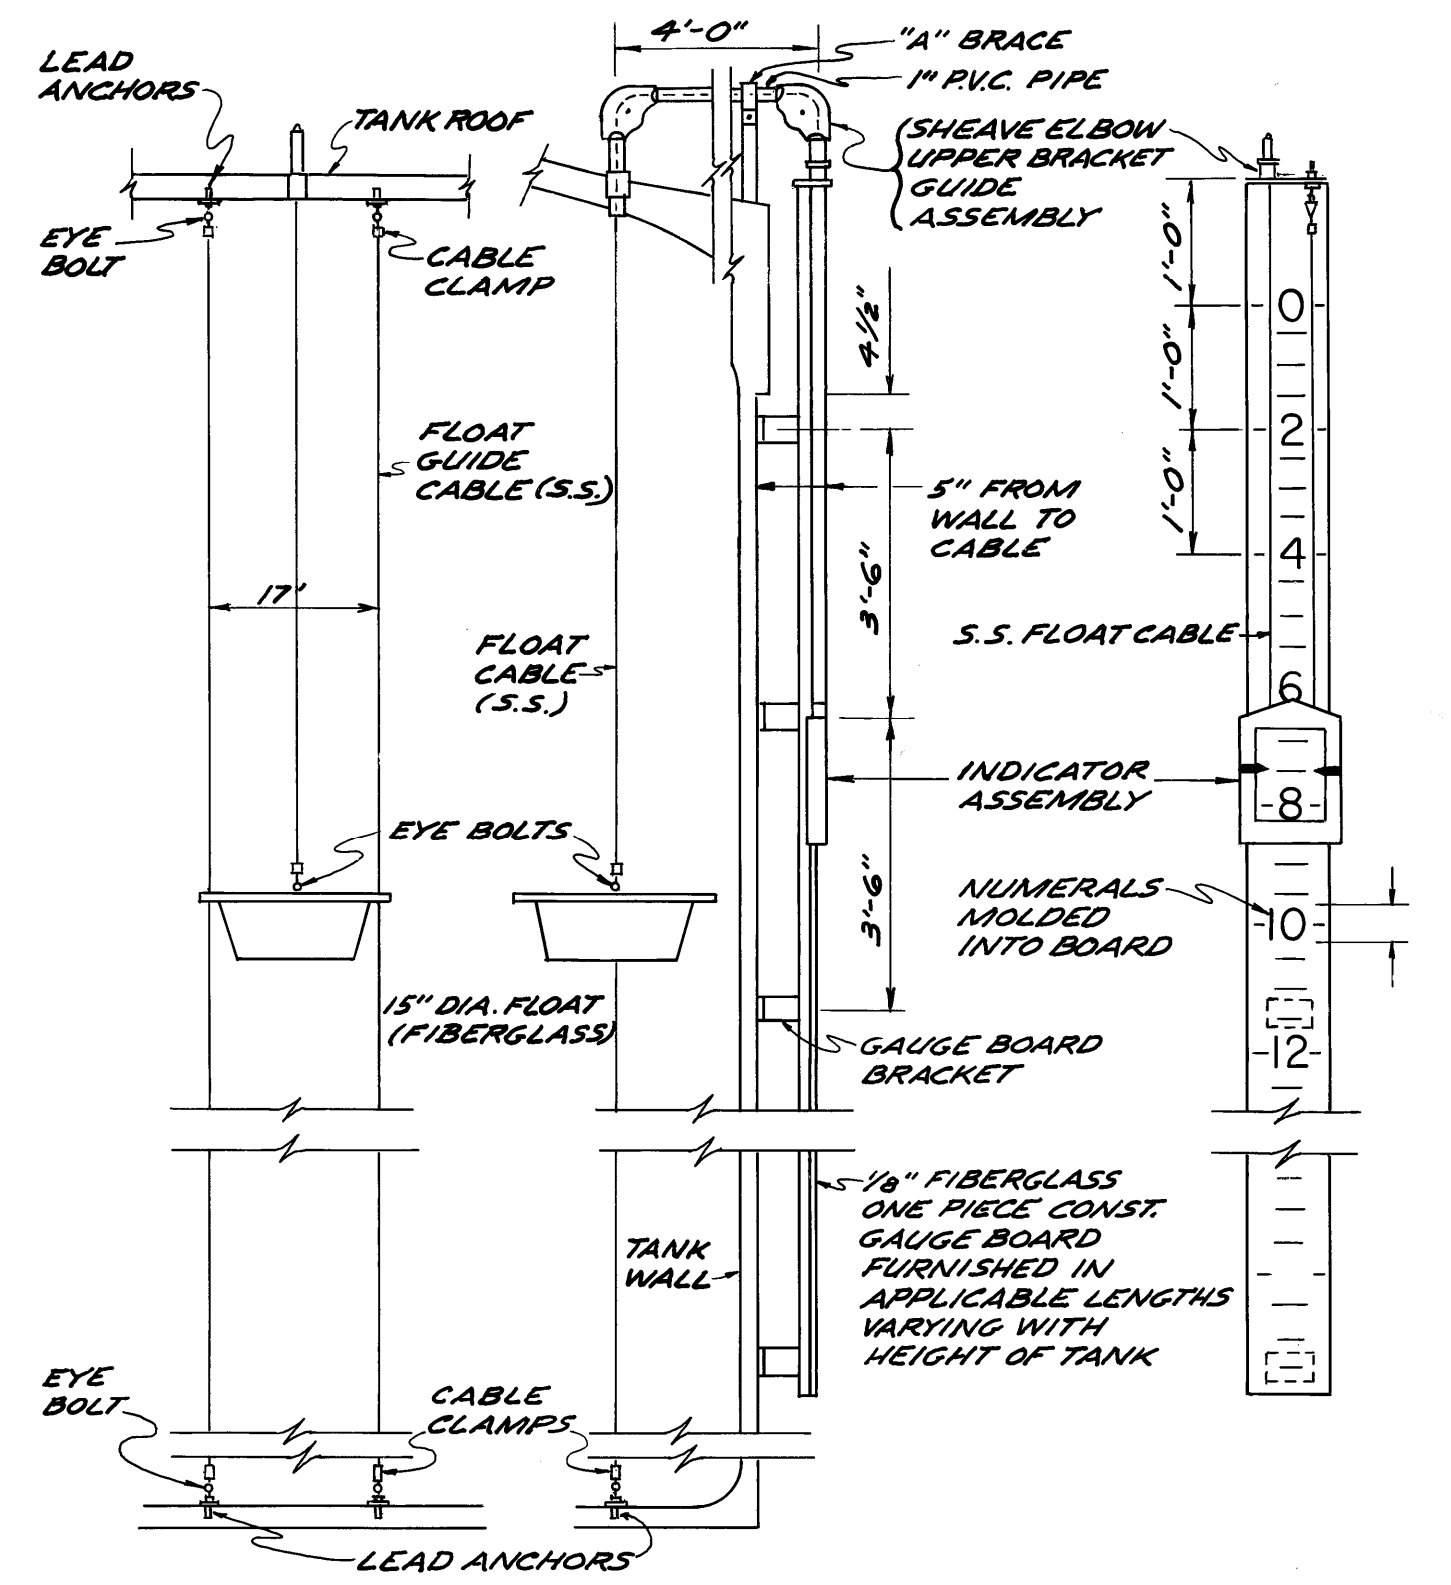

REAR SIDE TRAVEL BOARD  
LIQUID LEVEL INDICATOR  
ASSEMBLY  
NOT TO SCALE

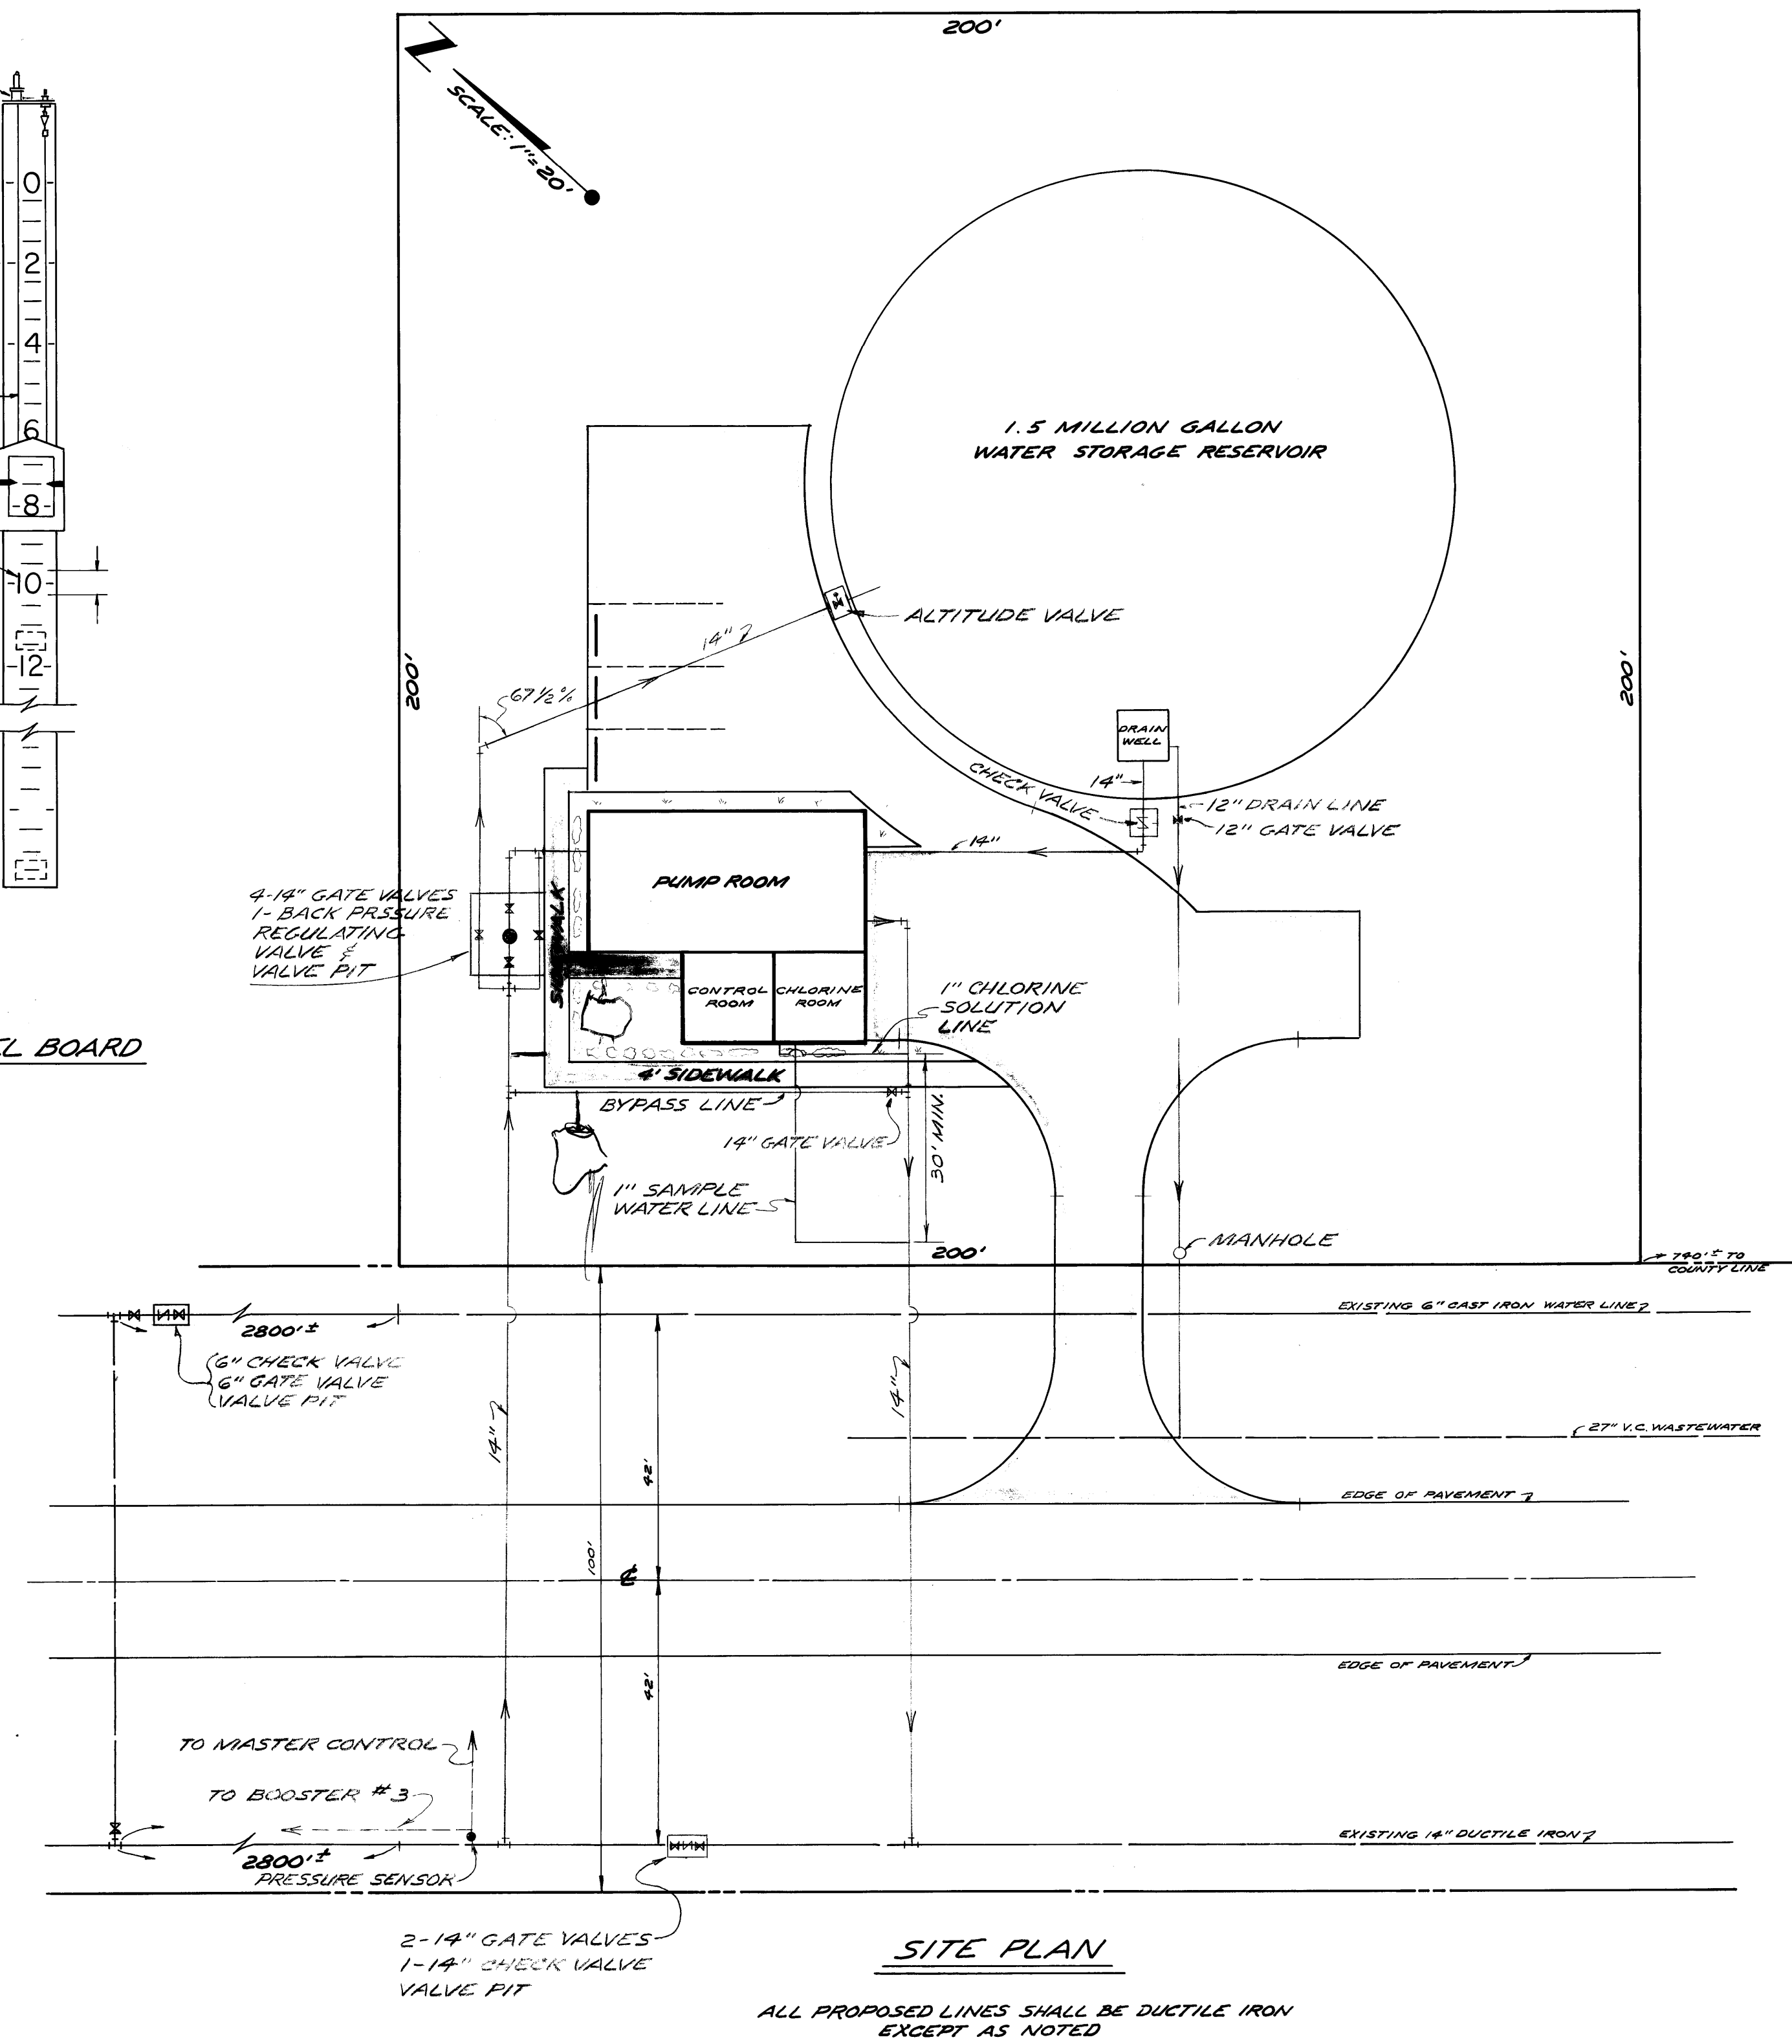

SITE PLAN

ALL PROPOSED LINES SHALL BE DUCTILE IRON  
EXCEPT AS NOTED

PROJECT ENGINEER	DESIGNED BY	DATE:	CHECKED BY
	L.D.L.		1638
BY	SCALE:	AS SHOWN	DRAWN BY
	1/8" = 1'-0"		A.H.L.
REVISION			
L.T.R.	DATE		
TOWN OF LONGBOAT KEY, FLORIDA			
SITE PLAN			
WATER PUMPING STATION AND			
1,500,000 GALLON WATER STORAGE RESERVOIR			
SHEET NUMBER	ENGINEER & LOCATION	T.L.K. FILE NO.	G-7-658-2
2			
REVISION			